



PLUMBING FIXTURE SCHEDULE

SYMBOL	QUANTITY	GENERAL FIXTURE DESCRIPTION	SUPPLY PIPING				DRAINAGE PIPING				REMARKS				
			COLD WATER	HOT WATER	GAS	VENT	TRAP	FIXT. DRAIN	DIRECT WASTE	INDR. WASTE					
A0100		DRIVE THRU BEVARIETY											12'	3,4,6,10	
A0200		SELF SERVE DRINK FREESTYLE (EXISTING)											12'	3,4,6,10	
G02##		ICE MAKER FOR DRINK STATION (EXISTING)												3,4,6,10	
WC-1		HDCP. HANDS FREE WATER CLOSET - SEE SPEC.	1"											2,4,9,11	
WC-2		HANDS FREE WATER CLOSET - SEE SPECIFICATIONS	1"											2,4,9,11	
LAV-1		HANDS FREE LAVATORY - SEE SPECIFICATIONS	1/2"	1/2"										2,4,9,11	
UR-1		HANDS FREE URINAL - SEE SPECIFICATIONS	3/4"											2,4,9,11	
T0302		HAND SINK - FAUCET	1/2"	1/2"										14'	3,4,12
T2101		HAND SINK												12'	3,4,12


FLOOR DRAINS

FD-1	5"x4" ADJUSTABLE STRAINER w/CAST IRON BODY, 3" BOTTOM OUTLET - JOSAM MODEL #30003-BR
------	--


- NOTES
- AS DIRECTED BY EQUIPMENT SUPPLIER
  - THIS EQUIPMENT FURNISHED BY PLUMBING CONTRACTOR
  - THIS EQUIPMENT FURNISHED BY OTHERS
  - PROVIDE VALVE AT EACH CONNECTION TO EQUIPMENT
  - AS DIRECTED BY PLUMBING CONTRACTOR
  - INDIRECT TO HUB DRAIN
  - PLUMBING CONTRACTOR TO PROVIDE INDIRECT DRAIN TO FLOOR DRAIN
  - NOT USED
  - REFER TO PLUMBING FIXTURE INFORMATION ON THIS SHEET.
  - PROVIDE WITH MATTS NO. 009 BACKFLOW PREVENTER
  - NEW FIXTURES CONNECTED TO EXISTING WATER LINES AND DRAINAGE SYSTEM
  - PLUMBING CONTRACTOR TO MAKE FINAL CONNECTIONS TO EQUIPMENT.

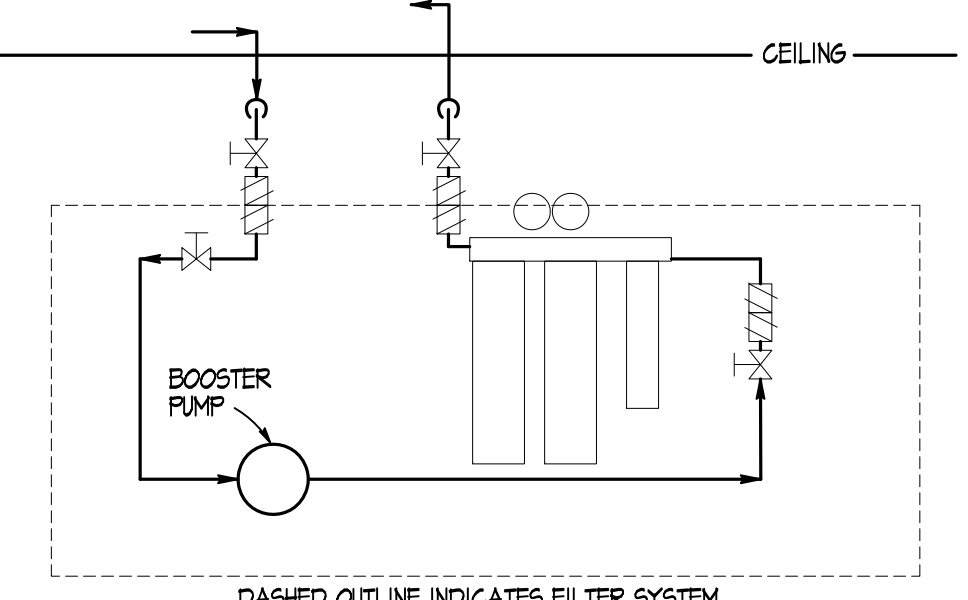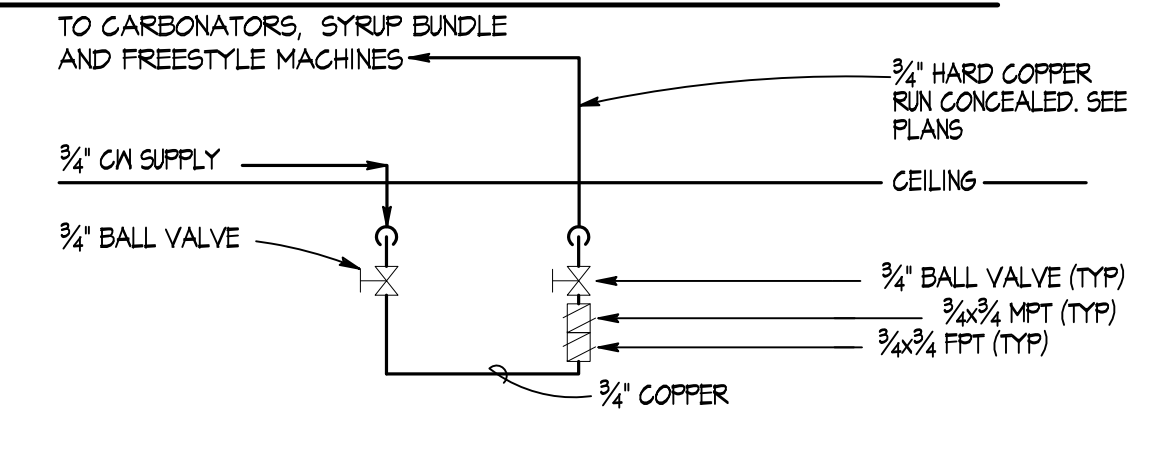

FILTER DETAIL

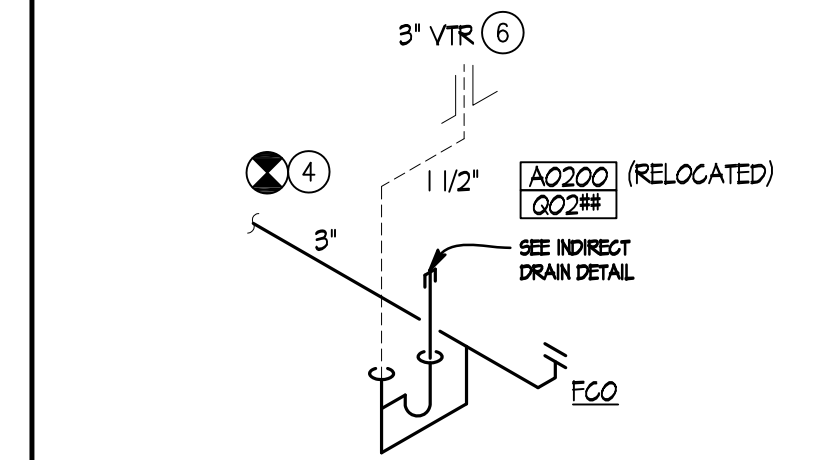

PARTIAL SANITARY ISOMETRIC  
NO SCALE

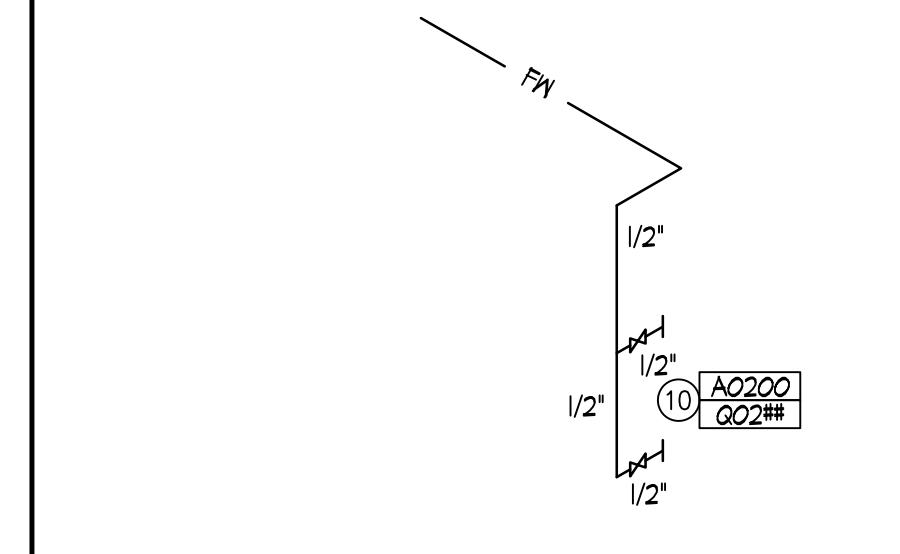

PARTIAL WATER SUPPLY ISOMETRIC  
NO SCALE

PLUMBING FIXTURE INFORMATION

WATER CLOSETS  
 NO. 2461016 AMERICAN STANDARD; ELONGATED "CADET" RIGHT HEIGHT VITREOUS CHINA TOILET 17" HIGH  
 NO. 184 MCGUIRE FLEXIBLE SUPPLY STOP  
 NO. 1055C ELONGATED "BEMIS" OPEN FRONT WHITE SEAT. NOT SELF-SUSTAINING HINGE.  
 NO. K-100101 "INTELLI-FLUSH" BATTERY OPERATED CHROME FINISH HANDS-FREE SYSTEM (1.6 GAL/FLUSH)

LAVATORY  
 AMERICAN STANDARD 0124024 VITREOUS CHINA WALL-HUNG SINK WITH REAR OVERFLOW, FAUCET LEDGE AND SUPPLIED MOUNTING KIT. INSTALL PER MANUFACTURER AND ADA REQUIREMENTS. DRAIN AND WATER SUPPLY TO BE INSULATED WITH TREBERO LAVGUARD INSULATION OR EQUAL.

WALL-HUNG LAVATORY, OVERALL SIZE 20"x18" VITREOUS CHINA BOWL (WHITE), OVERALL SIZE 15"x11". MOUNT PER ADA REQUIREMENTS. REFER TO ARCH PLANS FOR DETAILS.

NO.8872 MCGUIRE ADJUSTABLE CAST BRASS 1" TRAP WITH TUBING DRAIN TO WALL 1/4" INLET AND OUTLET, CLEANOUT PLUS ESCUTCHEON.  
 NO. 658VP 2DCBAMERICAN STANDARD "INSEROCK" ELECTRONIC AUTOMATIC FAUCET  
 OR  
 NO. 8301 MOEN ELECTRONIC FAUCET  
 OR  
 NO. 1340M.000.002 AMERICAN STANDARD METERING FAUCET WITH MIXING VALVE OR TC AUTOFAUCET IV SURROUND SENSOR TECHNOLOGY (SST) BY UNISOURCE.

NO. 167 MCGUIRE FLEXIBLE TUBE RISER, WHEEL HANDLE STOP, ESCUTCHEON, PROVIDE WITH WALL HANGERS

URINAL  
 NO. 6501010 AMERICAN STANDARD "WASHEROCK" VITREOUS CHINA WASHOUT, 3/4" (INCH) TOP SPRIDHALL HUNG  
 NO. 186-SFSM-0.25 SLOAN "ROYAL" BATTERY POWERED FLUSHMETER (0.25 GAL/FLUSH)

PLUMBING ABBREVIATIONS


AB	ABOVE	GPM	GALLONS PER MINUTE
AFF	ABOVE FINISHED FLOOR	HB	HOSE BIBB
ARCH	ARCHITECT	HC	HEATING CONTRACTOR
BEL	BELOW	HP	HORSEPOWER
BLDG	BUILDING	HW	HOT WATER RETURN
CLG	CEILING	HWR	HOT WATER RETURN
CO	CLEAN OUT	INV	INVERT
CONT	CONTINUATION	LAV	LAVATORY
CW	COLD WATER	MAX	MAXIMUM
CONTR	CONTRACTOR	MFR	MANUFACTURER
COORD	COORDINATE	MT	MOUNT
DISC	DISCONNECT	NTS	NOT TO SCALE
DNI	DOWN	PC	PLUMBING CONTRACTOR
EA	EACH	PLBG	PLUMBING
EC	ELECTRICAL CONTRACTOR	RD	ROOM DRAIN
EX	EXISTING	RTU	ROOFTOP UNIT
EWC	ELECTRIC WATER COOLER	SAN	SANITARY
FD	FLOOR CLEAN OUT	SS	SERVICE SINK
FD	FLOOR DRAIN	TYP	TYPICAL
FIXT	FIXTURE	TW	TEMPERED WATER
FLR	FLOOR	UR	URINAL
FPC	FIRE PROTECTION CONTRACTOR	V	VENT
FURN	FURNISH	VTR	VENT THRU ROOF
FV	FLUSH VALVE	WC	WATER CLOSET
G	GAS	WCO	WALL CLEAN OUT
GAL	GALLON	WH	WATER HEATER
GC	GENERAL CONTRACTOR	W/W	WITH
GPH	GALLONS PER HOUR		

GENERAL NOTES:


- PLUMBING CONTRACTOR SHALL MAKE ALL CONNECTIONS TO KITCHEN EQUIPMENT AND MECHANICAL EQUIPMENT UNLESS OTHERWISE NOTED.
- PROVIDE A TRAP PRIMER ON ALL NEW FLOOR DRAINS.
- COORDINATE LOCATION AND ROUGH-IN HEIGHT OF KITCHEN EQUIPMENT WITH KITCHEN EQUIPMENT SUPPLIER PRIOR TO ROUGH-IN.
- CONTRACTOR TO VISIT THE SITE PRIOR TO BID AND VERIFY ALL EXISTING CONDITIONS. VERIFY REMOVAL OF ANY FLOOR DRAINS WITH MENDY'S CONSTRUCTION MANAGER PRIOR TO START OF CONSTRUCTION.
- ANY DAMAGES TO ANY EXISTING WALLS, FLOORS, FINISHES ETC. BY THIS CONTRACTOR ARE TO BE REPAIRED AT THIS CONTRACTOR'S EXPENSE.

PLAN NOTES:

- ALL VENT PIPING ON ROOF TO BE HIGHER THAN ANY ROOFTOP AIR INTAKE. VERIFY IN FIELD AND EXTEND HEIGHT AS REQUIRED.
- COKE CONTRACTOR TO EXTEND TO BAG-IN-BOX SYSTEM. COORDINATE LOCATION OF BAG-IN-BOX EQUIPMENT WITH OWNER PRIOR TO ROUGH-IN.
- CONNECT TO EXISTING FILTER WATER SYSTEM. FIELD VERIFY NEAREST POINT OF CONNECTION.
- CONNECT TO NEAREST EXISTING SANITARY PIPING OF ADEQUATE SIZE AND CAPACITY. COORDINATE LOCATION, SIZE AND DIRECTION OF EXISTING SANITARY MAIN PRIOR TO ROUGH-IN.
- CONDIMENT STAND CONTAINS DRAIN LINES. NEW DRAIN LINE TO ACCEPT DRAIN FROM CONDIMENT STAND.
- VERIFY VTR IS INSTALLED 10'-0" FROM ANY AIR INTAKE.
- FILTERED WATER SYSTEM MODIFICATION BY COKE CONTRACTOR. PLUMBING CONTRACTOR TO CONNECT WATER TO SYSTEM. SEE DETAIL THIS SHEET.
- PLUMBING ROUGH-IN LOCATION WILL ACCOMMODATE FREESTYLE DRINK DISPENSER CONFIGURATION. SEE INDIRECT DRAIN DETAIL, THIS SHEET.
- COKE BUNDLE RIN IN CLG. AND DOWN WALL IN CHASE PROVIDED BY COKE FOR SYRUPS AND WATER IN COKE MACHINE.
- 3" FILTERED CW FROM FILTER BANK FOR ICE AND SODA MACHINE RIN IN CEILING. BOOSTER PUMP SYSTEM SHALL BE PROVIDED BY THE COKE CONTRACTOR WHERE FILTERED WATER PRESSURE IS BELOW RECOMMENDED PSI BY THE COKE CONTRACTOR.
- PROVIDE AND INSTALL NEW FIXTURE PER SPECIFICATION WHEN REQUIRED. CONNECT & EXTEND EXISTING WATER AND SANITARY PIPES TO NEW FIXTURE LOCATION AS REQ'D.
- PROVIDE AND INSTALL NEW FIXTURE PER SPECIFICATIONS. CONNECT AND EXTEND EXISTING WATER AND SANITARY PIPES TO FIXTURE LOCATION AS REQUIRED.

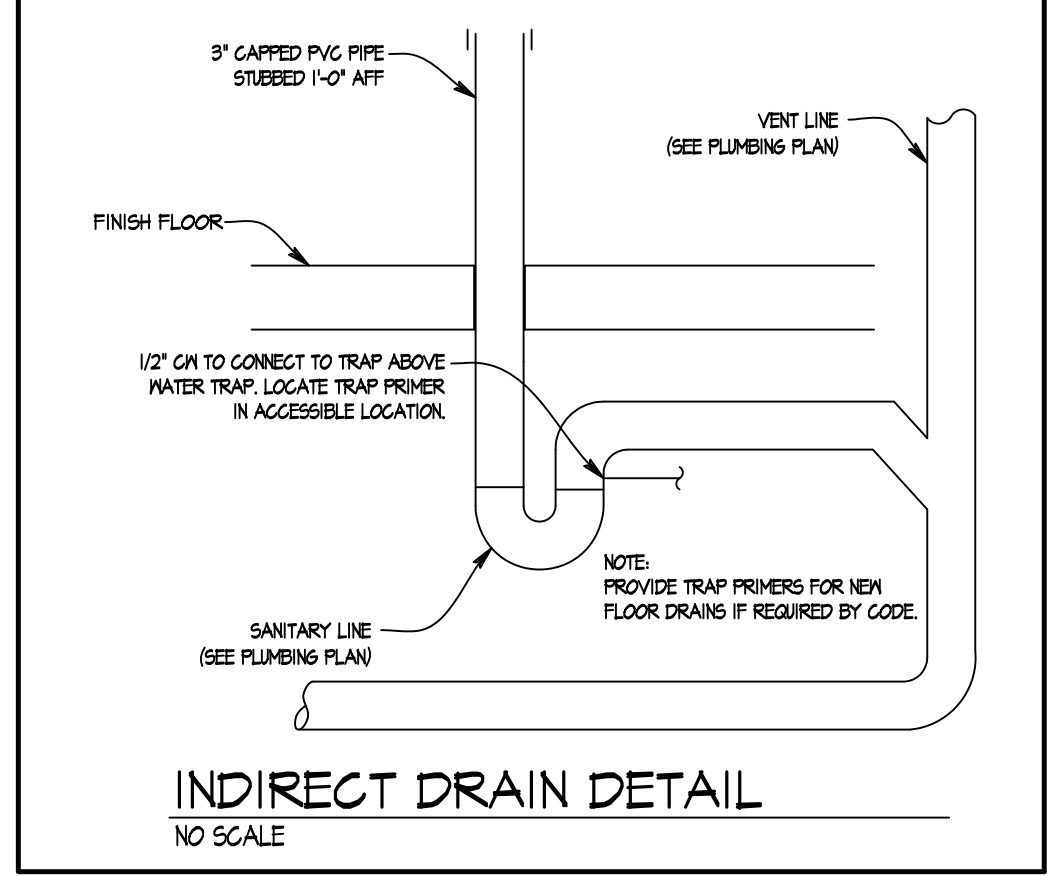

INDIRECT DRAIN DETAIL  
NO SCALE

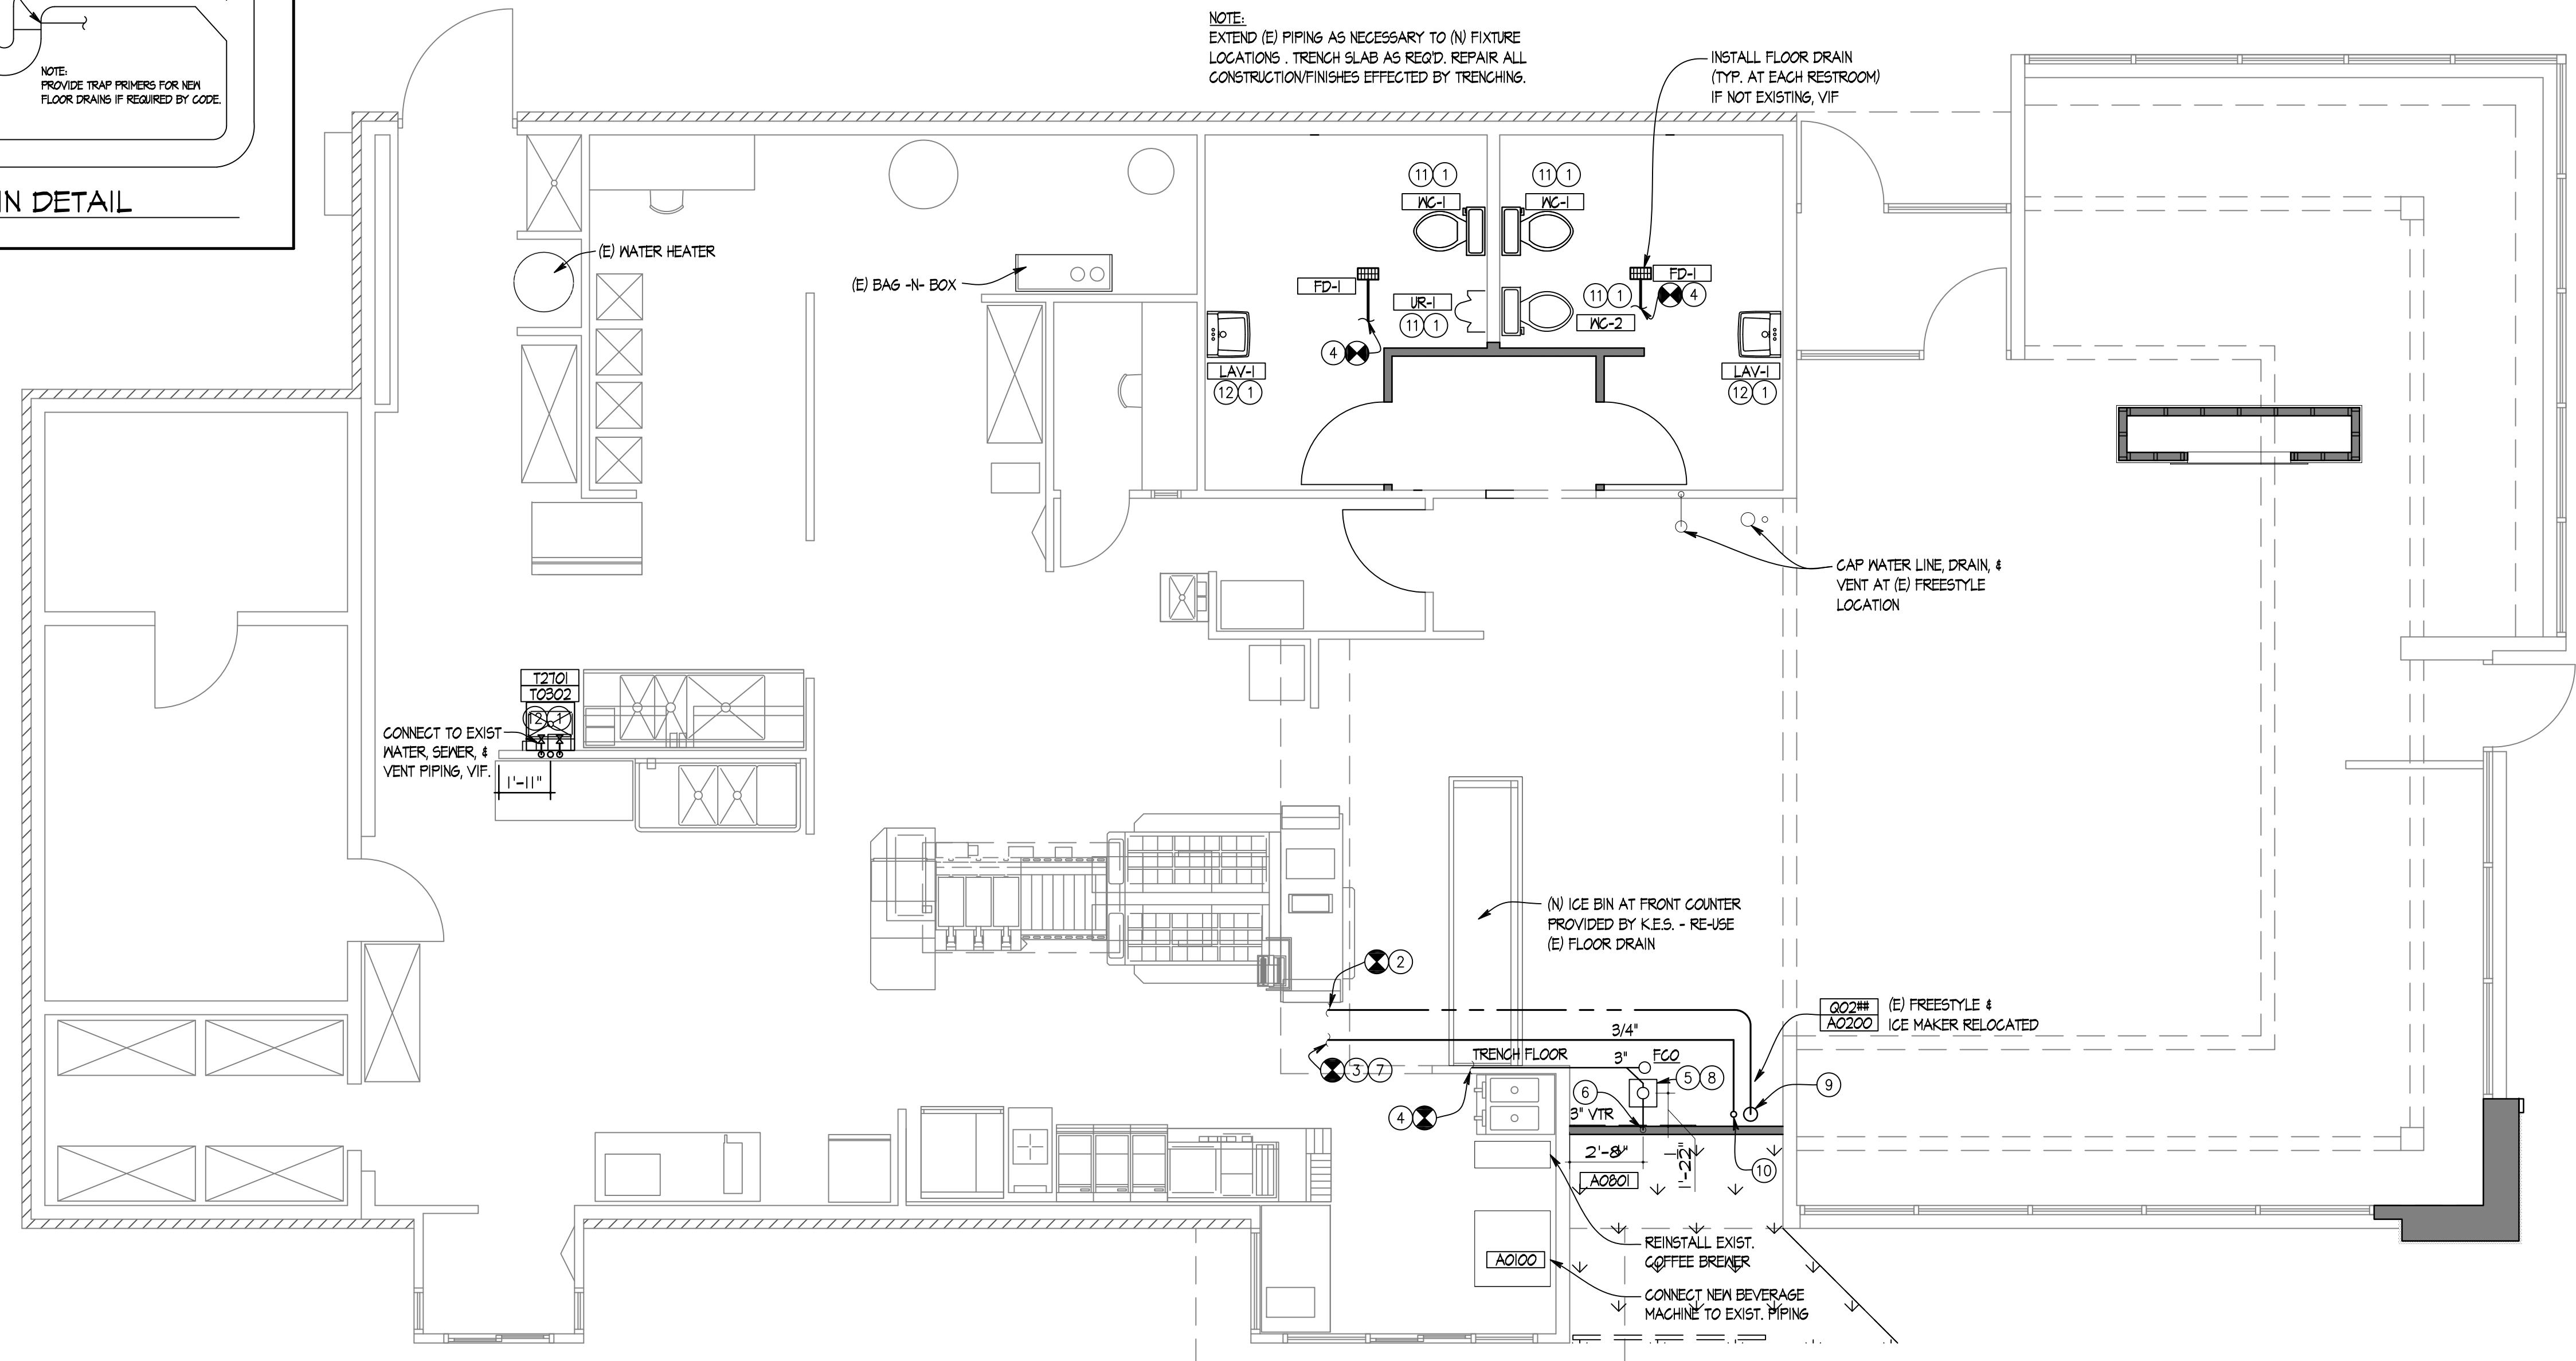

ATTENTION ALL BIDDERS  
 REFER TO MENDY'S APPROVED SUPPLIER LIST ON SHEET A6.2 TO OBTAIN NATIONAL ACCOUNT PHONE NUMBERS AND CONTACTS

ATTN ALL BIDDERS  
 COKE CONTRACTOR TO PROVIDE AND INSTALL ALL FILTERED WATER LINE FOR STORE REMODEL

NOTE:  
 EXTEND (E) PIPING AS NECESSARY TO (N) FIXTURE LOCATIONS. TRENCH SLAB AS REQ'D. REPAIR ALL CONSTRUCTION/FINISHES EFFECTED BY TRENCHING.

NORTH PLUMBING PLAN  
 SCALE: 1/4" = 1'-0"

LEGEND

— SAN	SANITARY WASTE LINE	VTR	VENT THRU ROOF LINE
— GW	GREASE WASTE LINE	—○—	PIPING RISE
— CW	DOMESTIC COLD WATER LINE	—○—	PIPING DROP
— HW	DOMESTIC HOT WATER LINE	—○—	VALVE
— HW	TEMPERED WATER LINE	— —H	WALL HYDRANT
— VENT LINE		—FCM—	FILTERED COLD WATER
		— G —	GAS LINE
		—○—	CONNECT TO EXISTING

Wallin • Gomez Architects, Ltd.  
 711 South Dearborn Street  
 Suite 606  
 Chicago, IL 60605  
 Tel: 312-427-4702  
 Fax: 312-427-6611  
 e-mail: admin@wgalt.com

Wendy's  
 STORE #07588  
 747 SOUTH STATE ROAD 135  
 GREENWOOD, IN

REV.	DATE	DESCRIPTION
01-08-16		ISSUED FOR PERMIT & BID

PLOT DATE: 1/14/2016  
 PROJECT NUMBER: 15130  
 DRAWN BY: CLAKH  
 CHECKED BY: DJW

NOTICE: THIS DOCUMENT CONTAINS PROPRIETARY INFORMATION. IT SHALL NOT BE USED OR REPRODUCED OR ITS CONTENTS DISCLOSED, IN WHOLE OR IN PART WITHOUT THE PRIOR WRITTEN CONSENT OF WALLIN / GOMEZ ARCHITECTS, LTD.

THESE DRAWINGS HAVE BEEN PREPARED AT AND/OR UNDER MY SUPERVISION AND TO THE BEST OF MY KNOWLEDGE AND BELIEF CONFORM AND COMPLY WITH THE REQUIREMENTS OF THE DEPARTMENT OF BUILDING AND CODES HAVING JURISDICTION.

STATE OF INDIANA  
 APR 10 2006  
 REGISTERED ARCHITECT  
 DONALD J. WALLIN  
 EXPIRATION DATE: 12/31/2017

PLUMBING PLAN AND SCHEDULE

SHEET NUMBER

**P1.1**