

1 REFLECTED CEILING PLAN  
SCALE: 1/4" = 1'-0"

LIGHT FIXTURE SCHEDULE

TYPE	MANUFACTURER	CATALOG NO.	WATTAGE	REMARKS	TYPE	MANUFACTURER	CATALOG NO.	WATTAGE	REMARKS
B2 	LSI	BESA CIERRO TYPE P4 "RUBBY MATTE" (1 PENDANT FIXTURE)	GU-24	DECORATIVE GLASS SINGLE PENDANT LIGHT. PENDANTS TO BE CENTERED OVER TABLES. HEIGHTS VARY. LOWEST BOTTOM OF LIGHT: 6'-6" A.F.F. AT DINING TABLE.	J 	HERMITAGE-SECURITY	SL-LED 48-DO-120-BL-ADJ	50	1.4' LINEAR LED GOOSE NECK EXTERIOR FIXTURE MARKED FOR WET LOCATION, TO BE MOUNTED ON 12" ARM
	SECURITY					CREE (RUDD) - HERMITAGE	LFL-A-4-DO-UL-BK-53K	35	2. COLOR TO MATCH EXISTING FIXTURES
	CREE (RUDD) - HERMITAGE								
B2 	TREND LIGHTING	BKP-003 W/ BULBLED	60W	DECORATIVE PENDANT LIGHT WITH PENDANTS TO BE CENTERED OVER TABLES PER DECOR DRAWINGS. COORDINATE LOCATION AND QUANTITY WITH DECOR SUPPLIERS BOTTOM OF LIGHT @ 6'-6" A.F.F.	K 	LSI	XSL2-S-LED-50-CW-120-WHT-CMT (RETROFIT)	62	EXTERIOR DROP DOWN SOFFIT LIGHT (MANSARD)
						SECURITY	851-42LED-FTP-OW-PS (RETROFIT)	42	
D 	LSI	PDL6L-LED-HO-WW-120-SD	14	6" OR 7" DIAMETER RECESSED LED DOWN LIGHT	L 	CREE (RUDD)-HERMITAGE	CPY250-A-DM-F-A-UL-SV	82	
	SECURITY	SLSDBXL-186LEDA30K-WH	14			LSI	XPWWS3-FT-LED-48-450-CW-UE-MSV R3-30WLED-DO-SV-120 (DOWN ONLY)	53	
	CREE (RUDD)-HERMITAGE	LRS-10L-30K-120-A-DR W/ RC6-12W-GU24	11			SECURITY	RWSC-30LED-WD-PS-MT (DOWN ONLY)	30	
E 	LSI	PEC14-LED-HO-RED-WW-UE	34	1x4 RECESSED LED	M 	CREE (RUDD)-HERMITAGE	R3-30WLED-DO-SV-120 (DOWN ONLY)	30	
	SECURITY	LLT1430LWGFSA12FE-C388	26.4			KONTECHUSA	KON-WS-40-XX (DOWN ONLY)	40	
	CREE (RUDD)-HERMITAGE	ZR14-40L-35K-10V	44			KONTECHUSA	KON-DVP-182-14-JY	36	TO BE USED AT AWNINGS ONLY
G 	LSI	GA24-LED-HO-WW-UE-P12	57	2x4 RECESSED LED (REQUIRED TO BE USED IN KITCHEN)	N 	LSI	XGBWM3-WT-LED-48-450-CW-UE-MSV	53	WALL MOUNTED SECURITY LIGHT
	SECURITY	LJT24-40LWG-FSA12-EU-C388	40.8			SECURITY	PGM3-30LU-SK-PS	69	
	CREE (RUDD)-HERMITAGE	CR24-40L-30K-S	45			CREE (RUDD)-HERMITAGE	EWP1X03I27	27	
C 	SECURITY	SLSF5741-31MOGU241SLED	15	6" DIAMETER SURFACE MOUNTED	EM 	LSI	LTEM-WH	(2) 1 LED	EMERGENCY LIGHT
	CREE (RUDD)-HERMITAGE	LR6-10L-30K-120-A-DR W/SC6-BK-GU24 W/ LT6	11			SECURITY	PE 6		
					EMX 	CREE (RUDD) - HERMITAGE	EMP22WH		
						LSI	PRX-R-U-WB-WH-PR50-R12	(2) 1.1 LED	EXIT/EMERGENCY LIGHT
						SECURITY	14104567		
						CREE (RUDD) - HERMITAGE	EXPCRWH		

GENERAL NOTES

- ALL DIMENSIONS SHOWN ON REFLECTED CEILING PLAN ARE FROM FACE OF WALL FINISH UNLESS NOTED OTHERWISE.
- THE REFERENCE HEIGHTS INDICATED ON PLAN ARE FROM APPROXIMATE FINISH FLOOR (A.F.F.)
- CONTRACTOR SHALL VERIFY FIXTURE QUANTITIES AND ALSO MAKE PROPER ADJUSTMENTS FOR ANY CHANGES IN PLAN DUE TO ADDITIONAL REQUIREMENTS, LOCAL CODES, ETC.
- ALL FIXTURES SHALL BE LOCATED IN THE CENTER OF CEILING TILES UNLESS NOTED OTHERWISE.
- DINING ROOMS ARE DESIGNED TO A 35-40 FOOT CANDLE LEVEL. KITCHENS ARE DESIGNED TO A 75 FOOT CANDLE LEVEL. RESTROOMS ARE DESIGNED TO A 50 FOOT CANDLE LEVEL.
- PROJECT SPECIFIC TYPES AND QUANTITIES.
- PENDANT FIXTURES "B2" MUST BE CENTERED OVER TABLE TOPS. COORDINATE WITH DECOR DRAWINGS.
- EXCEPT FOR DROPPED CEILING OPTION, ALL LIGHT FIXTURES IN DINING ROOM AREA AND RESTROOM CORRIDOR ARE TO BE SUPPORTED FROM EXPOSED ROOF TRUSSES. USE 2x4 BETWEEN BOTTOM CORDS FOR SURFACE MOUNTED FIXTURES.
- SEE INTERIOR DECOR PLAN FOR PENDANT LIGHT PLACEMENT.
- GC TO PROVIDE DUPLEX OUTLET EVERY 12'-0" @ WINDOW FACE, MAX. 18" FROM TOP OF WINDOW.

CEILING SPECIFICATIONS

ACT-1L	FINE FISSURED #1732
LOCATION:	DINING
MANUFACTURER:	ARMSTRONG
COLOR:	ADOBE
GRID:	2X2 ANGLED TEGULAR 15/16
DIMENSION:	2'X2'X3/4"
CONTACT:	ARMSTRONG STRATEGIC ACCOUNTS
	(800.442.4212)
ACT-2L	#BP670 ENVIROWALL
LOCATION:	SERVICE AISLE/BACK OF HOUSE
MANUFACTURER:	ARMSTRONG
COLOR:	WHITE
GRID:	PRELUD 15/16" EXPOSED TEE GRID
DIMENSION:	2'X4'X1/2"
CONTACT:	ARMSTRONG STRATEGIC ACCOUNTS
	(800.442.4212)
P-3L	PAINTED GYPSUM BOARD CEILING

SCOPE OF WORK PROPOSED


- A100 REPLACE HVAC GRILLES, DIFFUSERS AND THERMOSTATS.
- A101 REPLACE DINING RM AND SERVICE AISLE CEILING GRID & TILE
- A102 REPAIR AND CLEAN BOH CEILING GRID AND REPLACE TILES.
- A103 REPLACE EXISTING EXIT/EMERGENCY LIGHTS (EMX) (EM) WITH NEW AS PER SPECIFICATION. REFER TO LAYOUT FOR LOCATIONS.
- A104 INSTALL 2020 PENDANT LIGHTS AS PER DECOR DRAWINGS AND SPECIFICATION.
- A105 INSTALL NEW LED RECESSED LIGHTS IN DINING ROOM.
- A106 REPLACE RESTROOM EXHAUST FANS AS NEEDED AS PER SPEC.
- A107 INSTALL NEW LIGHT FIXTURES IN RESTROOMS PER LAYOUT.
- A108 INSTALL NEW CANOPIES, INCLUDING LIGHTING AS PER SPECIFICATIONS, REFERENCE A-2/A-6/A-7 FOR DETAILS & SIZES.
- A109 PAINT RESTROOM GYPSUM CEILING AS PER 2020 DECOR PACKAGE REQ. REPAIR CEILING AS NECESSARY FOR NEW LAYOUT.
- A110 INSTALL FLAT SCREEN TELEVISION AS PER DECOR DRAWINGS. G.C. TO PROVIDE POWER.
- A111 REPLACE BOH LIGHTING TO NEW LED 2X4 LIGHTS 1:1.
- A112 REPLACE LIGHTING ON EXISTING MANSARD ONE FOR ONE.

SYMBOLS LEGEND

SYMBOL	DESCRIPTION
	SUPPLY AIR DIFFUSERS (ALUMINUM TO MATCH CEILING COLOR)
	RETURN AIR GRILLES (ALUMINUM TO MATCH CEILING COLOR)
	EXHAUST FAN GRILLES (ALUMINUM TO MATCH CEILING COLOR)

No.	
Date	
Drawn By:	TC
Checked:	SB
Scale:	AS NOTED
Date:	04.01.16

Notes

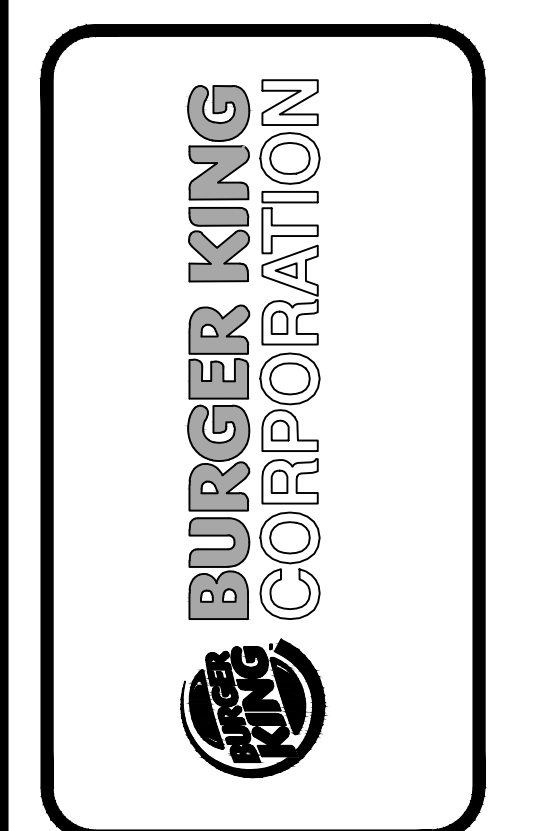

TECHNICAL GROUP, INC.  
37716 Hills Tech Drive  
Farmington Hills, MI 48331  
(248) 426-9000  
(800.442.4212)  
FAX (248) 426-7004



PROJECT  
BURGER KING #13914  
34897 GROSSBECK HWY.  
CLINTON TWP, MI 48035

SHEET TITLE  
REFLECTED CEILING PLAN

DO NOT SCALE THIS PRINT. USE FIGURED DIMENSIONS ONLY.

JOB #  
TG-16350

SHEET  
A-5