

DIRECTORY OF MANUFACTURERS AND SUPPLIERS

THIS LIST IS INTENDED TO ASSIST THE CONTRACTOR IN SOURCING BUILDING MATERIALS AND PRODUCTS. IN MANY CASES APPROVED BURGER KING MATERIALS AND PRODUCTS MAY BE PURCHASED DIRECTLY FROM THESE SOURCES AT A NATIONAL ACCOUNTS PRICE FOR A COMPLETE LISTING OF APPROVED MANUFACTURERS, SEE PLANS AND SPECIFICATIONS + VISIT RSI'S eREDBOOK

DIVISION 4 - MASONRY	DIVISION 9 - FINISHES	DIVISION 15 - MECHANICAL	SIGN, EQUIP, PLAYGROUND & DECOR	SIGN, EQUIP... (CONTINUED)
<p>ACME BRICK CO. (FACE BRICK) P.O. BOX 425 FT. WORTH, TX. 76101-0425 713-481-4651 800-792-1234 (IN TEXAS)</p> <p>BELDEN BRICK CO. (FACE BRICK) P.O. BOX 7001 700 WEST TUSCARAWAS CANTON, OH. 44702 330-456-0031</p>	<p>TRI-STATE BRICK & BLOCK, LLC. (TEXTURED BLOCK) 412 EAST ST. CATHERINE ST. LOUISVILLE, KY. 40203 502-587-7971</p> <p>GLEN GERY BRICK (FACE BRICK) P.O. BOX 7001 WYOMISSING, PA. 19160-6001 610-374-4011</p>	<p>D.J. PAINTING 789 LANDS AVE. BRIDGEFORD, NJ. 08307 DAN HARR: 609-685-0562 dan@djpainting.com</p> <p>UNIVERSAL MANUFACTURING (F.R.P.) 5366 CRESTVIEW RD. MEMPHIS, TN. 38134 901-458-5881 EXT. 105 800-821-1414 EXT. 105</p> <p>KEMITE (F.R.P.) JOLIET, IL. 800-435-0080</p> <p>WEATHER BARRIER, INC. (PAINT, COATINGS) 901 WASHINGTON ST. CONSHOHOCKEN, PA. 19428 800-843-9800 EXT. 302</p>	<p>LSI (MENU BOARDS) 3871 TURKEYFOOT ROAD ERLANGER, KY. 41018 RICK JORDON: 800-646-1513 EXT. 3607 972-497-0456</p> <p>FEDERAL HEALTH SIGN CO. (SIGNS) 3985 TAMPA ROAD OLDSMAR, FL. 34677 FIONA PAUL: 813-855-4415 800-284-3284 EXT. 19</p> <p>SELECTO SCIENTIFIC, INC. (WATER HEATERS) 5933 PEACHTREE IND. BLVD. SUITE B NORCROSS, GA. 30092 800-435-4017 IRVING, TX. 75062 800-447-1953 972-719-5900</p>	<p>INTEGRATED CONTROL CORP. (KITCHEN MINDER) 748 PARK AVENUE HUNTINGTON, NY 11743 ROBERTA SALERNO: 631-673-5100 OR 877-422-8788</p> <p>DUKE MANUFACTURING (PRODUCT FOLDING UNITS) 2305 NORTH BROADWAY ST. LOUIS MO. 63102 BILL ROSE 314-231-1130 EXR. 355 800-735-3853</p> <p>FRYMASTER CORPORATION (FRYERS) 9995 SW 72ND STREET SUITE 100 MIAMI FL. 33173 RICK GARCIA: 305-271-5035 800-221-4583</p>
<p>DIVISION 5 - METALS</p>	<p>SHERWIN WILLIAMS/DURON (PAINTS, COATINGS) 5790 HOFFNER AVENUE, SUITE 501 ORLANDO, FL. 32822 407-658-6280 (NATIONAL ACCTS. - LONN ROSELL)</p>	<p>WEATHER BARRIER, INC. (PAINT, COATINGS) 901 WASHINGTON ST. CONSHOHOCKEN, PA. 19428 800-843-9800 EXT. 302</p>	<p>CUMMINGS SIGNS, INC. (SIGNS) 15 CENTURY BLVD. SUITE 200 NASHVILLE, TN. 37214 ANN BAKER: 800-489-7446 EXT. 358 863-605-0339</p>	<p>CHARTER HOUSE INC. (SEATING & DECOR) 500 EAST 8TH STREET, SUITE 1000 HOLLAND, MI. 49426 BARB ZILM: 800-314-7659 317-774-8880</p>
<p>DIVISION 6 - WOOD/PLASTICS</p>	<p>JAMES HARDIE BUILDING PRODUCTS, INC. (SINKS, SOFFITS) 1255 LA QUINTA DRIVE SUITE 218 ORLANDO, FL. 32809 800-942-7343</p>	<p>WEATHER BARRIER, INC. (PAINT, COATINGS) 901 WASHINGTON ST. CONSHOHOCKEN, PA. 19428 800-843-9800 EXT. 302</p>	<p>ENTERA SIGNS (AWNINGS, CANOPIES & SIGNS) 1200 ENTERA DRIVE PANAMA CITY, FL. 32401 JOHN COLLINS 850-392-0823</p>	<p>SEATING CONCEPTS (SEATING & DECOR) 125 CONNELL STREET ROCKDALE, IL. 60436 BILLY OVERTON: 815-730-7980</p>
<p>DIVISION 7 - THERM MOISTURE PROTCT.</p>	<p>JAMES HARDIE BUILDING PRODUCTS, INC. (SINKS, SOFFITS) 1255 LA QUINTA DRIVE SUITE 218 ORLANDO, FL. 32809 800-942-7343</p>	<p>CARRIER CORPORATION (AIR CONDITIONING) 4304 CARRIER PARKWAY SYRACUSE, NY. 13221 DEBORAH ROY-JONES 315-432-7941 800-690-1086</p>	<p>LOREN COOK COMPANY (EXHAUST FANS) 2915 E. DALE SPRINGFIELD, MISSOURI 65803-4637 417-869-6474</p>	<p>CASABLANCA DESIGN GROUP (DECOR) 811 PICKENS INDUSTRIAL DRIVE MARIETTA, GA. 30026 COLLEEN SMITH: 770-672-6010 COLLEEN.SMITH@CDG.COM</p>
<p>DIVISION 8 - DOORS AND WINDOWS</p>	<p>ROCKWELL ROOFING (METAL ROOF) 1001 LUND BOULEVARD ANOKA, MN. 55303 800-426-7737</p> <p>TAMKO ROOFING PRODUCTS (FLAT ROOFING) P.O. BOX 1404 JOPLIN, MO. 64802 800-641-4691 (417) 624-6644</p> <p>SCHULLER (FLAT ROOFING) P.O. BOX 5108 DENVER, CO. 80217-5108 800-654-3103</p> <p>DURO-LAST ROOFING (FLAT ROOFING) 525 MURLEY DRIVE SAGINAW, MI. 48601 JOHN DEAL - 800-248-0280</p>	<p>INTERSTATE PAINTING LLC. (PAINT, COATINGS) 1759 BLACK OAK ROAD WILLIAMSTOWN, NJ 08094 DARRIN LAVIN: 856-625-4476 www.interstatepaintingonline.com</p> <p>OWENS CORNING (STONE EXTERIOR FINISH) 3 OWENS CORNING PARKWAY TOLEDO, OH. 43604 PATRICK LEACH 407-408-5477 PATRICK.LEACH@OWENSCORNING.COM</p> <p>LATICRETE (GROUT) ONE LATICRETE PARK NORTH BETHANY, ST. 06524-3423 DAVID MYERS 800-243-4788 203-376-8113 dameyers@laticrete.com www.laticrete.com</p>	<p>AMERICAN STANDARD (TOILET, URINAL, FAUCETS) 1 CENTENNIAL AVE. PISCATAWAY, NJ. 08855 RAY MYRABO: 480-797-0959 800-266-3400 EXT. 209 www.HDSupply.com</p> <p>EVERPURE, INC. (WATER FILTERS) 3691 COMMERCIAL AVENUE NORTHBROOK, IL. 60062 800-227-5432 847-291-7674</p>	<p>LANCER (DRINK DISPENSERS) 6655 LANCER BLVD. SAN ANTONIO, TX. 78219 TOM BRIGHTWELL: 770-331-7808 800-729-1500 EXT. 7255</p> <p>NIECO CORPRATION (BROILERS) 7950 CAMERON DRIVE WINDSOR, CA 95092 EDWARD BAKER SR. 707-284-7100 800-821-2141</p> <p>FRICO (FRYERS) 10 FERRY STREET CONCORD, NH. 03301 MARK MCCABE: 603-230-5563 800-238-3708</p>
<p>DIVISION 8 - DOORS AND WINDOWS</p> <p>U.S. ALUMINUM (STOREFRONT) 200 SINGLETON DRIVE WAXAHACHIE, TX. 75165-5094 800-627-6400</p> <p>KAWNEER CO., INC. (STOREFRONT) P.O. BOX 516 JONESBORO, GA. 30237 770-478-8841</p> <p>TUBELITE (STOREFRONT) P.O. BOX 1118 8200 MACKINAW TRAIL REED CITY, MI. 49677 972-551-6100</p> <p>VISTAWALL (STOREFRONT) P.O. BOX 629 803 AIRPORT RD. TERRELL, TX. 75160 800-869-4567</p> <p>QUIKSERV (DRIVE-THRU WINDOWS) 1144 BRITMORE PARK DRIVE HOUSTON, TX. 77041 800-388-8307 713-849-5882</p> <p>FULKERSON, LLC. (TOUCH FREE DOOR HANDLE) 4230 RHONA LANE CUMMING, GA. 30040 MATT FULDERSON: 404-693-5661 mfulderson@fuldersonline.com www.santigrasp.com</p> <p>READY ACCESS (DRIVE THRU WINDOWS & AIR CURTAINS) 1815 ARTHUR DRIVE WEST CHICAGO, IL. 60185 KIM MCKIBBEN 630-876-7767 800-621-5045 kim@ready-access.com</p>	<p>BOBRICK PRODUCTS (RESTROOM ACCESSORIES, TOILET PARTITIONS AND HARDWARE) FMP DISTRIBUTORS ROB KEISER 800-257-7737 EXT. 311 *GREEN PRODUCT</p> <p>AMERICAN STANDARD (RESTROOM ACCESSORIES) 1 CENTENNIAL AVENUE PISCATAWAY, NJ. 08854 888-294-2007 EXT. 3104 732-980-3234 betsy.swan@alennindustries.com</p> <p>ZURN INDUSTRIES (PLUMBING FIXTURES) 1801 PITTSBURG AVENUE ERIE, PA. 16502 PAT MCQUILLAN: 877-575-4483</p> <p>UNI-STRUCTURES, INC. (CANOPIES & AWNINGS) 8540 COBB CENTER DR. KENNESAW, GA. 30152 KRISTIN WATTS: 800-386-9864 EXT. 208 k.watts@unistructures.com</p> <p>SAN JAMAR (RESTROOM ACCESSORIES & SUPPLIES) 553 KOOPMAN LANE ELKHORN, WI. 800-248-9826 EXT. 113 262-723-6133 EXT. 113 www.sanjamar.com</p> <p>UNIVERSAL MANUFACTURING (RESTROOM ACCESSORIES) 5366 CRESTVIEW DR. MEMPHIS, TN. 38134 901-458-5881 EXT. 105 800-821-1414 EXT. 105</p> <p>WORLD DRYER, CO. (HAND DRYERS) 5700 MCDERMOTT DR. BERRKELY, IL. 60163 RICK STEFFEN: 708-449-6950</p>	<p>COLUMBIA VORTEX (HAND DRYERS) 825 GARLAND STREET COLUMBIA, SC. 29201 LISA FITZGERALD: 866-337-7286 EXT. 1136 OR EXT. 1120</p> <p>ALLEN INDUSTRIES, INC. (AWNINGS) 4100 SHERATON COURT GREENSBORO, NC. 27410 BETSY SWAN 888-294-2007 EXT. 3104 betsy.swan@alennindustries.com</p> <p>KOALA KARE PRODUCTS (BABY CHANGING STATIONS) 202-257-7737 btsales@tkmponline.com</p> <p>LSI INDUSTRIES INC. (INTERIOR AND EXTERIOR LIGHTING SURVEYS AND PHOTOMETRICS) 1343 SOUTH HENDERSON AVE CINCINNATI, OH. 45242 RON LARIMORE: 800-436-7800 EXT. 3375 513-793-3200</p> <p>HERITAGE LIGHTING NAT. ACCOUNTS (INTERIOR AND EXTERIOR LIGHTING, SURVEYS AND PHOTOMETRICS) 7201 WASHINGTON AVENUE KACINE, WI. 53406-3772 800-236-7000 EXT. 3129 262-884-3104</p> <p>SECURITY PRODUCTS, INC. (REAR DOOR ALARM) 30950 COREAL DRIVE SUITE B COARSEGOLD, CA. 93614 BOB BARR: 559-462-2710 800-452-5276</p> <p>N.C.A. NATIONAL HVAC PRODUCTS, LLC. (MASTER CONTROL SYSTEM) 4585 140 AVENUE NORTH CLEARWATER, FL. 33762 877-530-0078</p> <p>HILL PHOENIX POWER SYSTEMS DIVISION (FACTORY INTEGRATED SWITCH GEAR) 2050 EAST PARK DRIVE CONYERS, GA. 30013 PRICING: 770-285-3251 edpburgerking@hillphoenix.com</p>	<p>SECURITY LIGHTING (EXTERIOR SITE AND BUILDING LIGHTING, SURVEYS AND PHOTOMETRICS) 1085 JOHNSON DRIVE BUFFALO GROVE, IL. 60089 STEVE FRIEDMAN 847-279-0627 800-544-4848</p> <p>INTERNATIONAL COLD STORAGE (ICS) (WALK-IN COOLERS / FREEZERS, DRY STORAGE COMPARTMENTS) 215 EAST 13th STREET ANDOVER, KS. 67002 DAVE KONECNY: 800-835-0001 316-218-4135</p> <p>HIM ELECTRONICS, INC. (HME) (DRIVE-THRU WIRELESS INTERCOMS, DRIVE-THRU SPEED OF SERVICE TIMERS, DIGITAL SURVEILLANCE SYSTEMS.) 14110 STOWE DRIVE POWAY, CA. 92064 LISA JOXINEN: 800-848-4468</p> <p>SENSOMATIC(A/D) SECURITY SERVICES (BURGLAR ALARMS, CCTV, ACCESS CONTROL AND FIRE ALARMS) ONE TOWN CENTER ROAD BOCA RATON, FL. 33486 KERIAN WRORLEY 954-590-3083</p> <p>SUNCOAST ENVIRONMENTAL CONTROLS, INC. (ELECTRICAL SWITCH GEAR) 8655 15th AVENUE NORTH LARGO, FL. 34643 877-544-6679</p> <p>FRANE CO. (ENERGY MANAGEMENT PANEL) 2884 CORPORATE WAY MIRAMAR, FL. 33025 GORMAN RASMUSSEN 954-499-2290</p>	<p>KIDZ PLAY INC. (KIDSPACE) (PLAYGROUND MANUFACTURER) 55 SANFORD FLEMING DR. COLLINGWOOD, ONTARIO CANADA L9Y 4B2 ROB BUTLER: 800-668-0206 EXT. 223 800-940-4848 EXT. 122</p> <p>PLAY SYSTEMS (DIV. OF SUPERIOR INT. INDUSTRIES, INC.) (PLAYGROUND MANUFACTURER) 1050 COLUMBIA DR. CARROLLTON, GA. 30717 DAVID HYAMS: 800-327-8774</p> <p>SPI INDUSTRIES (PLAYGROUND MANUFACTURER) BOX 100, R.R. #2, JOINT ST. SHALLOW LAKE ON, NOH 2KO CANADA ROB WALKER 519-935-5543 EXT. 243 cccad@spiplastics.com</p> <p>SOFT PLAY, LLC. (PLAYGROUND MANUFACTURER) (SAFETY SURFACING) (NON-CONTAINED PLAY EQUIPMENT) 13620 EAST REESE BLVD. SUITE 300 HUNTERSVILLE, NC. 28078 KEN SCHOEBER: 800-782-5729 704-948-3448 kens@softplay.com</p> <p>SOFT PLAY EUROPE (PLAYGROUND MANUFACTURER) 704-948-3448</p>
				<p>MISCELLANEOUS</p> <p>HAINES, JONES, AND CADBURY (PACKAGE PRICING ON MULTIPLE ITEMS - PLUMBING, TILE, RESTROOM ACCESSORIES, ETC) 310 SW 24TH STREET BENTONVILLE, AR 72712 KATHERINE HARRIS 800-459-7099</p>

Notes

Date	By
No.	


Drawn By: TC

Checked: SB


Scale: AS NOTED

Date: 04.01.16

ALL RIGHTS RESERVED. NO PART OF THESE DRAWINGS OR SPECIFICATIONS MAY BE REPRODUCED OR USED IN CONNECTION WITH ANY WORK, OTHER THAN THE SPECIFIC PROJECT FOR WHICH THEY HAVE BEEN PREPARED, WITHOUT PRIOR WRITTEN AUTHORIZATION FROM THE ARCHITECT.

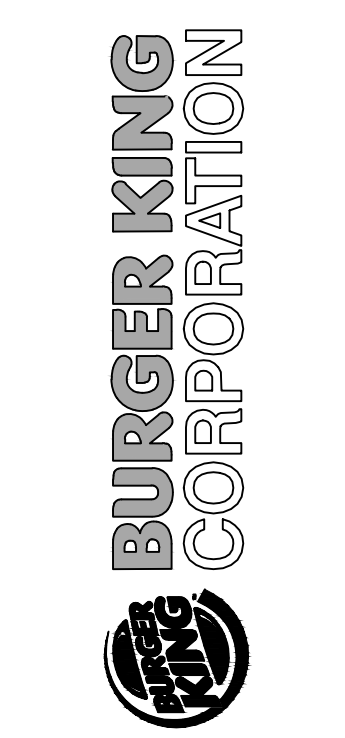

TECHNICAL GROUP, INC.
37716 Hills Tech Drive
Farmington Hills, MI 48331
(248) 426-8000
FAX (248) 426-7004

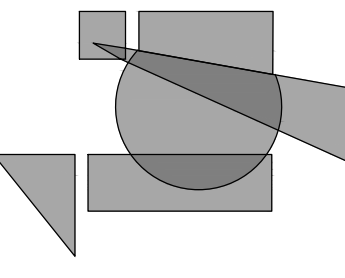

PROJECT
BURGER KING #13916
34897 GROESBECK HWY.
CLINTON TWP. MI 48035

SHEET TITLE
MANUFACTURES AND SUPPLIERS

DO NOT SCALE THIS PRINT. USE FIGURED DIMENSIONS ONLY.

JOB #
TG-16350

SHEET
A-8