
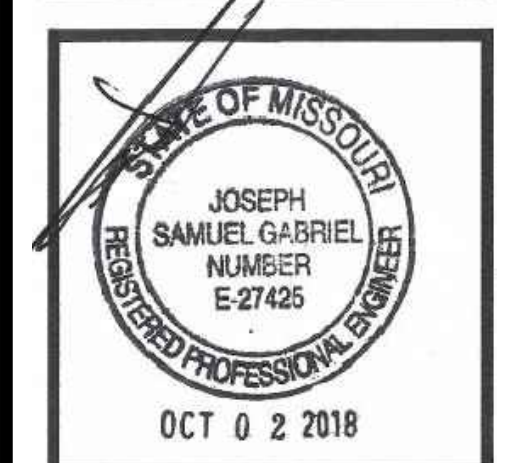


NO.	DATE	BY	NOTES
1	08.10.2018	DB	FOR SUBMITAL TO BIC
2	08.10.2018	DB	REVISIONS SUBMITAL TO BIC
3	08.10.2018	DB	REVISIONS SUBMITAL TO CITY
4	10.06.2018	DB	REVISIONS TO CITY
5	11.05.2018	DB	REVISIONS TO CITY

Drawn By: DB
Checked: SB
Scale: AS NOTED
Date: 08.01.18

ALL RIGHTS RESERVED. NO PART OF THESE DRAWINGS OR SPECIFICATIONS MAY BE REPRODUCED OR TRANSMITTED IN ANY FORM OR BY ANY MEANS, ELECTRONIC OR MECHANICAL, WITHOUT PRIOR WRITTEN AUTHORIZATION FROM THE ARCHITECT.

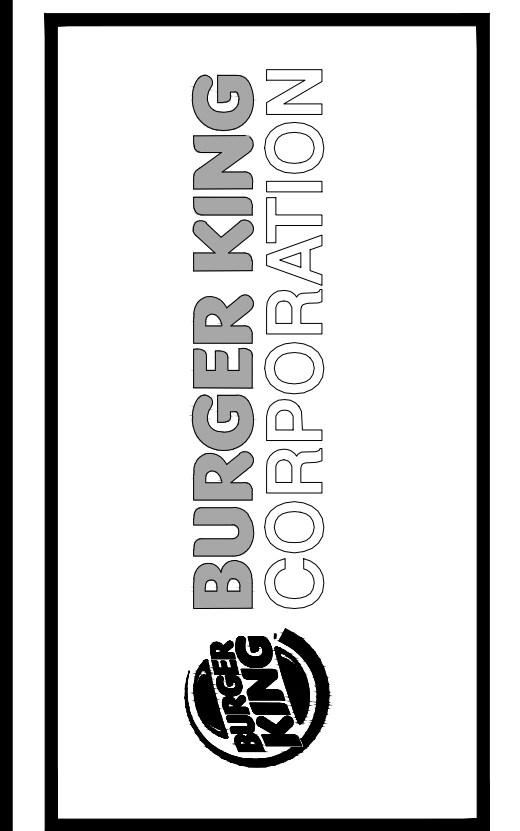


PROJECT: BURGER KING #123, 1517 S. BELL HWY, ST. JOSEPH, MO 64507

SHEET TITLE: PROPOSED REFLECTED CEILING PLAN

JOB #: TG-18531

SHEET: A-5

DO NOT SCALE THIS PRINT. USE FIGURED DIMENSIONS ONLY.

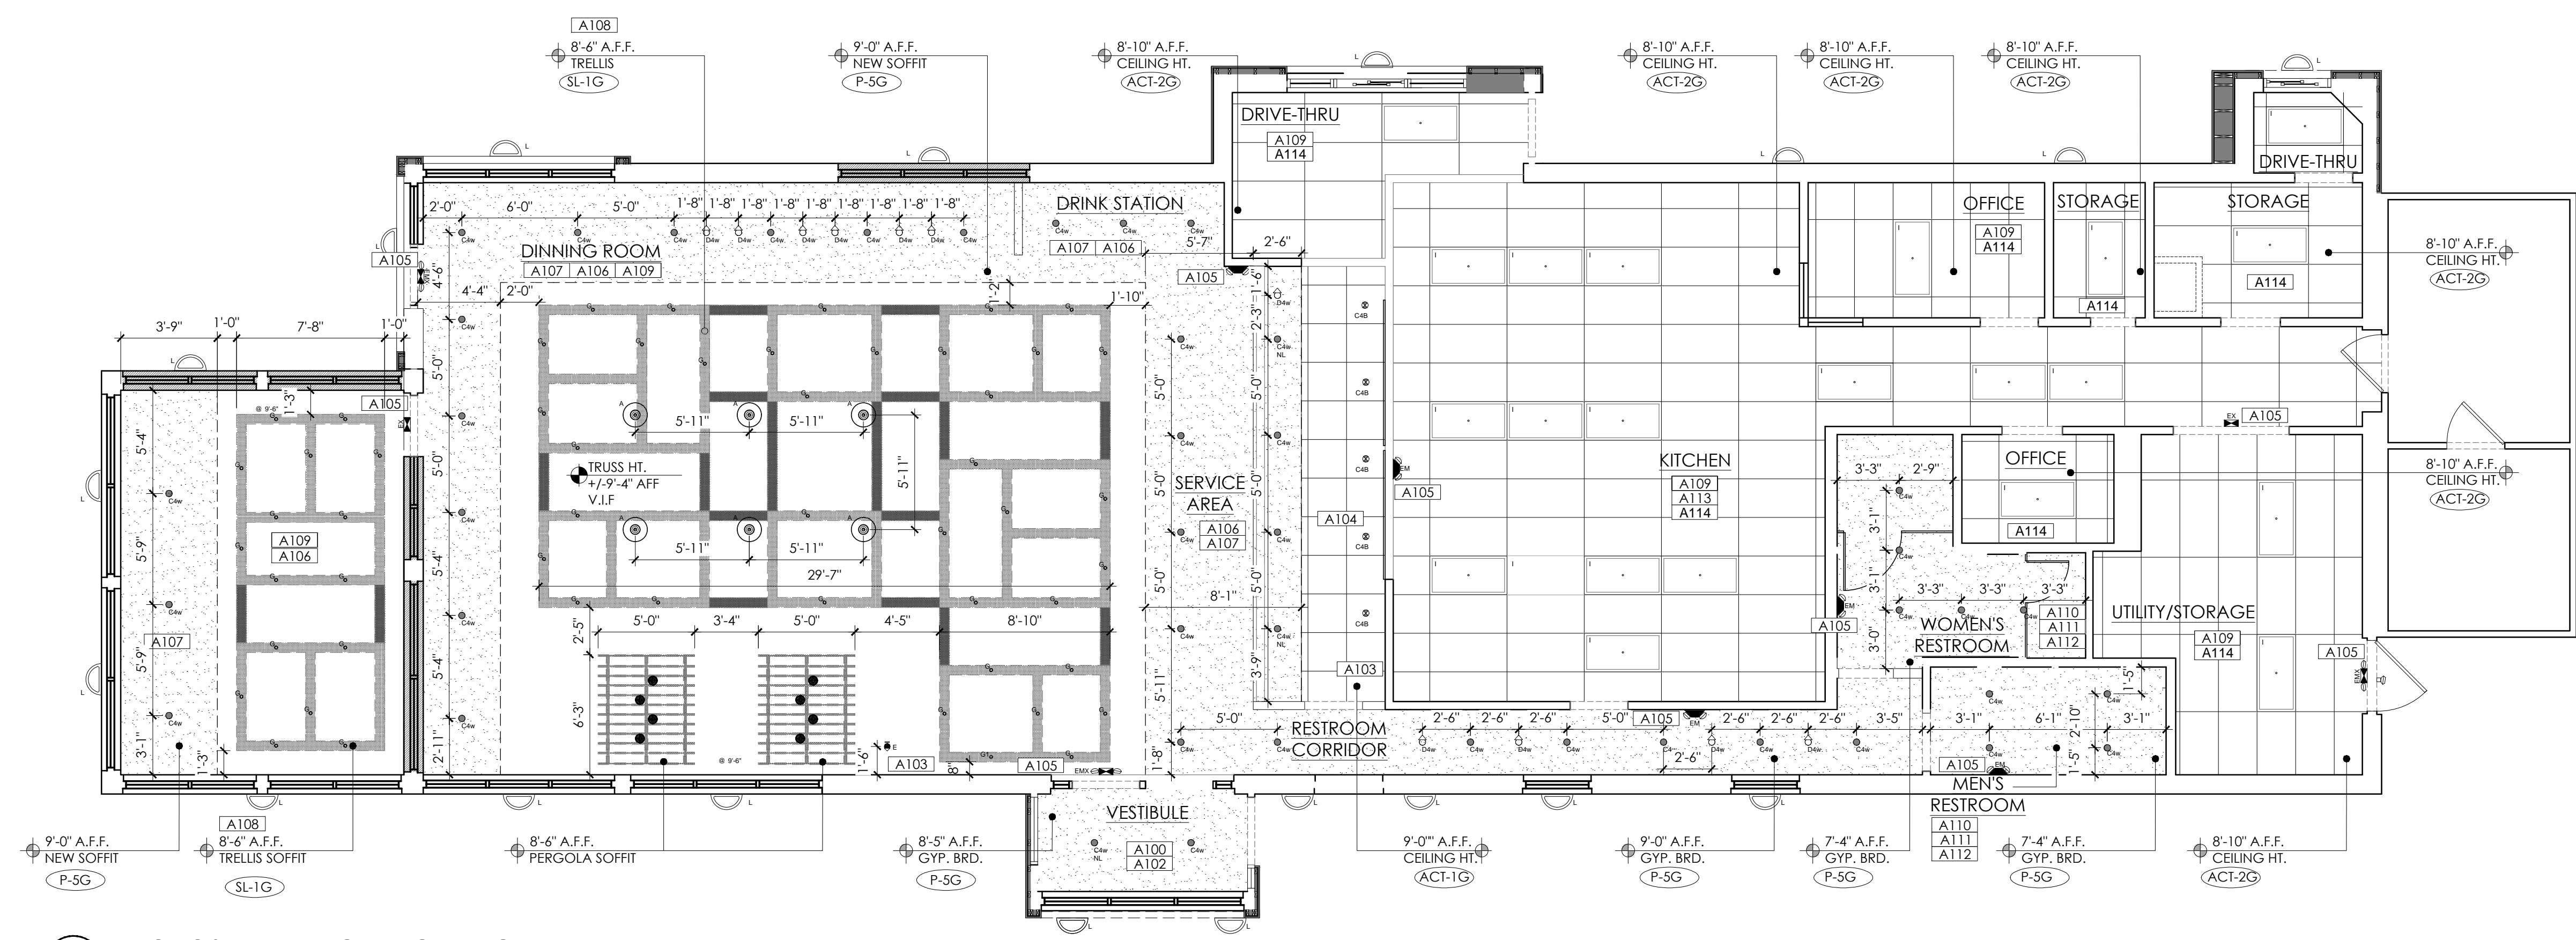

1 PROPOSED REFLECTED CEILING PLAN
SCALE: 3/16" = 1'-0"

- ### GENERAL NOTES
- ALL DIMENSIONS SHOWN ON REFLECTED PLAN ARE FROM FACE OF WALL FINISH UNLESS NOTED OTHERWISE.
 - THE REFERENCE HEIGHTS INDICATED ON PLAN ARE FROM APPROXIMATE FINISH FLOOR (A.F.F.)
 - CONTRACTOR SHALL VERIFY FIXTURE QUANTITIES AND ALSO MAKE PROPER ADJUSTMENTS FOR ANY CHANGES IN PLAN DUE TO ADDITIONAL REQUIREMENTS, LOCAL CODES, ETC.
 - ALL FIXTURES SHALL BE LOCATED IN THE CENTER OF CEILING TILES UNLESS NOTED OTHERWISE.
 - DINING ROOMS ARE DESIGNED TO A 30 FOOT CANDLE LEVEL. KITCHENS ARE DESIGNED TO A 75 FOOT CANDLE LEVEL. RESTROOMS ARE DESIGNED TO A 50 FOOT CANDLE LEVEL.
 - EXCEPT FOR DROPPED CEILING OPTION, ALL LIGHT FIXTURES IN DINING ROOM AREA AND RESTROOM CORRIDOR ARE TO BE SUPPORTED FROM EXPOSED ROOF TRUSSES. USE 2x4 BETWEEN BOTTOM CORDS FOR SURFACE MOUNTED FIXTURES.
 - SEE INTERIOR DECOR PLAN FOR PENDANT LIGHTS AND DECORATIVE CEILING ELEMENT PLACEMENT AND FINISHES.
 - GO TO PROVIDE DUPLEX OUTLET EVERY 12'-0" @ WINDOW FACE, MAX. 18" FROM TOP OF WINDOW.

- ### SCOPE OF WORK PROPOSED
- A100 | INSTALL GYPSUM IN VESTIBULE AS PER SPECIFICATION.
 - A101 | NOT USED
 - A102 | INSTALL NEW LIGHT FIXTURES IN VESTIBULE AS PER SPECIFICATION.
 - A103 | REPLACE THERMOSTATS IN SAME LOCATION.
 - A104 | REPLACE SERVER AREA CEILING GRID & TILE.
 - A105 | REPLACE EXISTING EXIT/EMERGENCY LIGHTS (EMX) (EM) WITH NEW AS PER SPECIFICATION. REFER TO LAYOUT FOR LOCATIONS.
 - A106 | INSTALL NEW LIGHT FIXTURES IN DINING ROOM AS PER LAYOUT. VERIFY WITH DECOR DRAWINGS AND SPECIFICATION.
 - A107 | INSTALL NEW SOFFITS ABOVE DRINK STATION, DINING AREA AND SERVICE AISLE. PAINT PER SPECIFICATION. REFER TO PLANS FOR LOCATION.
 - A108 | INSTALL NEW TRELLIS, INCLUDING LIGHTING AS LAYOUT. REFERENCE DECOR DRAWINGS FOR DETAILS.
 - A109 | INSTALL NEW DUCTS, DIFFUSERS AND GRILLES AS PER A-7 AND PAINT TO MATCH CEILING.
 - A110 | INSTALL NEW LIGHT FIXTURES IN RESTROOMS PER LAYOUT.
 - A111 | PAINT RESTROOM GYPSUM CEILING AS PER SPECIFICATION. REPAIR CEILING AS NECESSARY FOR NEW LAYOUT.
 - A112 | REPLACE RESTROOM EXHAUST FANS AS NEEDED.
 - A113 | INSTALL NEW BOH CEILING TILE AND GRID AS PER SPECIFICATION.
 - A114 | INSTALL ALL NEW BOH LIGHT FIXTURES 1:1 WITH NEW SPECIFICATION.

LIGHTING FIXTURE SCHEDULE

TYPES	MANUFACTURER	DESCRIPTION	WATTS	MOUNTING	DESCRIPTION
A	NAUTICAL FURNISHINGS, LLC	BK304 & SP305-18-60D-927-03 LED EDISON STYLE	10	SURFACE	SHAKER PENDANT LAMP
B	NAUTICAL FURNISHINGS	BK305 & LED 8W EDISON INCANDESCENT LED CLEAR ANTIQUE STYLE	6	SURFACE	BRONZE CAGE PENDANT LIGHT
B1	NAUTICAL FURNISHINGS	BK305 & LED 8W EDISON INCANDESCENT LED CLEAR ANTIQUE STYLE	6	SURFACE	BRONZE CAGE WALL SCONCE LIGHT
C4W	JUNO CREE ENERGYWISE SECURITY	SP36671-WHTRM CR4-575L-27K-12-E26 EWALLED-DL4N LBA4A 6L 30K 9 WH / 1BXQL	15 9.5 11 9	RECESSED	4" DIAMETER, WHITE, RECESSED DOWN LIGHT TO BE USED IN GWB CEILING
C4B	JUNO CREE	SP36671-BLTRM CR4-575L-27K-12-E26-MODBLK	15 9.5	RECESSED	4" DIAMETER, BLACK, RECESSED DOWN LIGHT TO BE USED WITH A.C.T.
D4W	JUNO SECURITY	SP36671G2 / 39 WHH LBA4A 6L 30K 9 WH / 1BXQL	12.5 9	RECESSED	4" DIAMETER, WHITE, RECESSED DOWN LIGHT WALL WASHER TO BE USED WITH A.C.T.
D4B	JUNO SECURITY	SP36671G2 / 39C BL RFD44875 LBA4A 6L 30K 9 WH / 1BXQL	12.5 9	RECESSED	4" DIAMETER, BLACK, RECESSED DOWN LIGHT WALL WASHER TO BE USED WITH A.C.T.
E	JUNO	R600L3KNBZ SP34378B-9-F1-SSN	10 10	SURFACE	TRACK LIGHT
G	ZANIBONI	D2LUN20930A3CSNPOBKOP SP34378A-930-F1-SN	9 10	RECESSED	2" DIAMETER DOWN LIGHT, @ TRELLIS SOFFIT SATIN NICKEL FINISH
G1	ZANIBONI	D2LUN20930A3CSNPOBKOD	9	RECESSED	2" DIAMETER WALL WASHER, @ TRELLIS SOFFIT SATIN NICKEL FINISH

TYPES	MANUFACTURER	DESCRIPTION	WATTS	MOUNTING	DESCRIPTION
I	CREE SECURITY	CL-E-TFA04A-24A-40N LIT24-40-MLG-FSA-12-EU-C388	42 45 50	RECESSED	2x4 RECESSED TO BE USED IN B.O.H.
J	VAOPTO ENERGYWISE	VO-PL-2XWW4-40 EWMLFP24EP4841	60 48	RECESSED	FOR REMODELS ONLY TO BE USED IN RESTROOMS 1x4 RECESSED
J	CREE SECURITY	CL-E-TR14L2402U LIT14-35LWG-FSA12-EU-C388	42 40	RECESSED	FOR REMODELS ONLY TO BE USED IN RESTROOMS 1x4 RECESSED
J	VAOPTO ENERGYWISE	VO-PL-1XWW4-40 EWMLFP24EP4841	60 48	RECESSED	FOR REMODELS ONLY TO BE USED IN RESTROOMS 1x4 RECESSED
PG	CREE SECURITY	CL-E-TFA03A-22R-40N LIT22-35MLG-FSA12-EU	32 35	RECESSED	TO BE USED IN PLAYGROUND 2x2 RECESSED
PG	VAOPTO ENERGYWISE	VO-PL-2XWW2-36 EWMLFP22EP3535	36 36	RECESSED	TO BE USED IN PLAYGROUND 2x2 RECESSED
EMX	CREE SECURITY	CL-E-TFA03A-22R-40N LIT22-35MLG-FSA12-EU	32 35	SURFACE	EMERGENCY EXIT LIGHT
EMX	VAOPTO ENERGYWISE	VO-PL-2XWW2-36 EWMLFP22EP3535	36 36	SURFACE	EMERGENCY EXIT LIGHT
EM	CREE SECURITY	EXDMBRWH CCRC	11 4	SURFACE	EMERGENCY LIGHT
EM	VAOPTO ENERGYWISE	VO-EMX-R1 EWCCR	2 4	SURFACE	EMERGENCY LIGHT
EX	CREE SECURITY	EX R U L WH COMPERABLE	4	SURFACE	EMERGENCY LIGHT
EX	VAOPTO ENERGYWISE	VO-WP-DW-N50 EWALD-WPDS240	50 40	SURFACE	EMERGENCY LIGHT
L	SECURITY	RS-30WLED-DO-SV-120 (DOWN ONLY)	12	SURFACE	EXTERIOR WALL FIXTURE
L	SECURITY	WP23LE9X157KSV (UP/DOWN)	24	SURFACE	OPTIONAL CLOSED CANOPY
L	SECURITY	RWSC30LED-WD-PS-MT (DOWN ONLY)	30	SURFACE	FIXTURE PROVIDED BY SIGN SUPPLIER WITH CANOPY
L	CREE (RUDD)-HERMITAGE	RS-30WLED-DO-SV-120 (DOWN ONLY)	30	SURFACE	FIXTURE PROVIDED BY SIGN SUPPLIER WITH CANOPY
L	KONTECHUSA	RS-42WLED-UD-PS-120-5300K (UP/DOWN)	40	SURFACE	FIXTURE PROVIDED BY SIGN SUPPLIER WITH CANOPY
L	VAOPTO ENERGYWISE	KON-40-WS (DOWN ONLY)	60	SURFACE	FIXTURE PROVIDED BY SIGN SUPPLIER WITH CANOPY
L	VAOPTO ENERGYWISE	VO-WS-DW40D (UP/DOWN)	40	SURFACE	FIXTURE PROVIDED BY SIGN SUPPLIER WITH CANOPY
L	VAOPTO ENERGYWISE	VO-WS-DW60D (UP/DOWN)	60	SURFACE	FIXTURE PROVIDED BY SIGN SUPPLIER WITH CANOPY
L	CREE	EWKON-40-WS (DOWN ONLY)	60	SURFACE	FIXTURE PROVIDED BY SIGN SUPPLIER WITH CANOPY
L	SECURITY	E-WPT1X3127 WGH-11U-M	27 41	SURFACE	WALL MOUNTED SECURITY LIGHT BRONZE FINISH
L	SECURITY	SFCMWBLEDPL150UEBRZ	33	SURFACE	WALL MOUNTED SECURITY LIGHT BRONZE FINISH
L	VAOPTO ENERGYWISE	VO-WP-DW-N50 EWALD-WPDS240	50 40	SURFACE	WALL MOUNTED SECURITY LIGHT BRONZE FINISH

CEILING SPECIFICATIONS

ACT-1G
LOCATION: CORTEGA #770 DINING
MANUFACTURER: ARMSTRONG
COLOR: SEPIA
GRID: 2X2 ANGLED TEGULAR 15/16 IN SEPIA 2'X2'X3/4"
DIMENSION: 2'X2'X3/4"
CONTACT: LOUIS J. JOHN-NL ACCOUNTS MANAGER (407) 697-6768 LJOHN@ARMSTRONG.COM

ACT-2G
LOCATION: KITCHENZONE #BP672 SERVICE AISLE/BACK OF HOUSE
MANUFACTURER: ARMSTRONG
COLOR: WHITE
GRID: PRELUDE 15/16" EXPOSED TEE GRID IN WHITE 2'X4'X1/2" (BOH) 2'X2'X1/2" (SERVICE ISLE)
DIMENSION: 2'X4'X1/2" (BOH) 2'X2'X1/2" (SERVICE ISLE)
CONTACT: ARMSTRONG STRATEGIC ACCOUNTS (800.442.4212)

P-3G
LOCATION: MENU BOARD AND FACE OF SOFFIT
MANUFACTURER: PPG 6-411 EGSSHELL
COLOR: WHITE STONE

P-5G
LOCATION: CORRIDOR SOFFIT AND RESTROOMS
MANUFACTURER: SHERWIN WILLIAMS
COLOR: WHITE ON WHITE

P-15G
LOCATION: SOFFIT ACCENT
MANUFACTURER: OMNOVA SOLUTIONS
COLOR: BUNGALOW BEIGE SW 7511

SL-1G
LOCATION: TRUSS ACCENT
MANUFACTURER: OMNOVA SOLUTIONS
PRODUCT: SURF(X) 3D LAMINATES ON SUNTRAIT
COLOR: ALMOND CHERRY
CONTACT: DUSTIN SMITH (314) 489-2374 DUSTIN.SMITH@OMNOVA.COM

SYMBOLS LEGEND

SYMBOL	DESCRIPTION
	SUPPLY AIR DIFFUSERS (ALUMINUM TO MATCH CEILING COLOR)
	RETURN AIR GRILLES (ALUMINUM TO MATCH CEILING COLOR)
	EXHAUST FAN GRILLES (ALUMINUM TO MATCH CEILING COLOR)