

**DIRECTORY OF MANUFACTURERS AND SUPPLIERS**


This list is intended to assist the contractor in sourcing building materials and products. In many cases, approved Burger King materials and products may be purchased directly from these sources at a national accounts price. For a complete listing of approved manufacturers, see plans and specifications, and visit RSI's eRebook.

UPDATE: 7-27-2018		DIVISION 9 - FINISHES		DIVISION 15 - MECHANICAL		SIGNS, EQUIPMENT, PLAYGROUNDS AND DÉCOR		
<b>DIVISION 4 - MASONRY</b> PINE HALL BRICK CO. (FACE BRICK) 2701 SHOREFAIR DRIVE, NW WINSTON-SALEM, NC 27105 THERESA BEANE: (800) 334-8689 TBEANE@PINEHALLBRICK.COM	EVOLUTION BRICK (FACE BRICK) 126 OLD HIGHWAY 60 EAST HARDINSBURG, KY 40143 GABE POWERS: (502) 558-4612	FOR FINISH MATERIALS, AND CONTACTS, REFER TO FINISH SCHEDULES FOUND IN THE "COMMON DOCUMENTS" SECTION OF THE WWW.DESIGNWITHBK.COM WEBSITE.		RINNAI (INSTANT WATER HEATERS) RINNAI NATIONAL ACCOUNT PRICING THROUGH HAINES, JONES, & CADBURY. CONTACT THE BURGER KING CSR AT HIC 800-458-7099 FOR RINNAI TANKLESS WATER HEATER PRICING (MISCELLANEOUS)	EVERPURE, INC. (WATER FILTERS) 1040 MURFIELD DRIVE HANOVER PARK, IL 60133 JEANNINE GAINE: 630-240-1298 jeanine.gaine@pentair.com	L.S.I. (MENU BOARDS) 10000 ALLIANCE ROAD CINCINNATI, OH 45242 BRITTANY KOESTER: 513-372-3391 OR 513-315-3725	INTEGRATED CONTROL CORP. (KITCHEN MINDER) 748 PARK AVENUE HUNTINGTON, NY 11743 JOHN PATTI: 631-673-5100 EXT 325	CHARTER HOUSE INC. (DECOR) 4650 136 AVENUE HOLLAND, MI 49424 BARB ZILM: 800-314-7659 OR 317-774-8880 barbara.zilm@charter-house.com www.gotochi.com
HC MUDDOX BRICK CO. (FACE BRICK) 4875 BRADSHAW ROAD SACRAMENTO, CA 95827 916-859-6320		SUMMITVILLE TILE CO (REPLACEMENT STRATA TILE) 330-223-1511		RHEEM (WATER HEATERS) 101 BELL ROAD MONTGOMERY, AL 36117 800-621-5622 OR CONTACT HAINES, JONES, & CADBURY (MISCELLANEOUS)	SELECTO SCIENTIFIC, INC (WATER FILTERS) 3980 LAKEFIELD COURT SUWANEE, GA 30024 EHUD LEVY: 678-475-1445 edlevy@selectoinc.com	Samsung (MENU BOARDS) CONTACT: SARA GROFCSIK (KEY ACCOUNT MANAGER) s.grofcsik@sea.samsung.com (214) 952-1242		SEATING CONCEPTS (DECOR) 125 CONNELL STREET ROCKDALE, IL 60436 ZACH DEPYSSLER: 815-483-2244 zdepysler@seating-concepts.com
<b>DIVISION 5 - METALS</b> ADDISON STEEL (STRUCTURAL STEEL) ADDISON, IL 256-747-1554		<b>DIVISION 10 - SPECIALTIES</b> BOBRICK PRODUCTS (RESTROOM ACCESSORIES, TOILET PARTITIONS* AND HARDWARE) CONTACT: HAINES, JONES, & CADBURY (MISCELLANEOUS) *GREEN PRODUCT	KOALA KARE PRODUCTS (BABY CHANGING STATIONS) CONTACT: HAINES, JONES, & CADBURY (MISCELLANEOUS)	A.O. SMITH (WATER HEATERS) 600 E. JOHN CARPENTER FREEWAY, SUITE 200 IRVING, TX 75062 800-447-1953 972-719-5900	N.C.A. NATIONAL HVAC PRODUCTS, LLC. (AIR CONDITIONING - FULL SERVICE) 4585 140 AVENUE NORTH CLEARWATER, FL 33762 877-530-0078	LG ELECTRONICS (MENU BOARDS) CONTACT: MICHAEL HA (BUSINESS DEVELOPMENT) (847) 309-4774	DUKE MANUFACTURING (PRODUCT HOLDING UNITS) 2305 NORTH BROADWAY ST. LOUIS MO. 63102 SUE SCIUTO: 800-735-3853 EXT 1260 ssciuto@dukemfg.com	FCI COMMERCIAL FURNITURE (DECOR) 8452 OLD HWY. 59 NORTH ROSEBURG, OR 97470 PRESTON O'HARA: 541-464-5284 OR 800-322-7328 EXT 284 preston.ohara@fcifurniture.com
		AMERICAN STANDARD (RESTROOM ACCESSORIES) 1 CENTENNIAL AVENUE PISCATAWAY, NJ 08854 CONTACT HAINES, JONES, & CADBURY (MISCELLANEOUS)	COLUMBIA VORTEX (HAND DRYERS) 825 GARLAND STREET 866-337-7286 EXT. 1136	CARRIER CORPORATION (AIR CONDITIONING) 6304 CARRIER PARKWAY SYRACUSE, NY 13221 DEBORAH ROY-JONES: 315-432-7941 800-690-1086	LOREN COOK CO (EXHAUST FANS) 2015 E. DALE SPRINGFIELD, MO 65803-4637 KEN DICKSON: 813-966-9200 ken.dickson@tampabay.rr.com	CUMMINGS SIGNS, INC (AWNINGS, CANOPIES AND SIGNS) 105 DALTON PLACE WAY KNOXVILLE, TN 37912 AMANDA HICKMAN: 865-862-4416 amanda.hickman@cummingsigns.com	FRYMASTER CORPORATION (FRYERS) 8700 LINE AVE SHREVEPORT, LA 71106 LAURA DODD: 713-865-1711 eqorders@frymaster.com	CASABLANCA DESIGN GROUP (DECOR) 811 PICKENS INDUSTRIAL DRIVE MARLETTA, GA 30026 JOHN HARRISON: 770-423-9575 John.Harrison@cdg.com
<b>DIVISION 7 - THERMAL MOISTURE PROTECTION</b> DURO-LAST ROOFING (FLAT ROOFING) 525 MORLEY DRIVE SAGINAW, MI 48601 LINDY BELTHIN: 800-432-9331 SAMANTHA PICKELMAN 989-758-1048 OR 989-930-9826	G.A.F. (FLAT ROOF) 1361 AINS ROAD WAYNE, NJ 07470 (201) 628-3000 800-766-3411	ZURN INDUSTRIES (PLUMBING FIXTURES) CONTACT: HAINES, JONES, AND CADBURY (MISCELLANEOUS)	WORLD DRYER, CO (HAND DRYERS) CONTACT: HAINES, JONES, AND CADBURY (MISCELLANEOUS)	TRANE (AIR CONDITIONING UNITS, RTU's/SPLIT SYSTEMS CONTROLS) 2884 CORPORATE WAY TRUSSVILLE, AL 35173-0081 USA JONES: 205-655-5760 AL MARTINEZ: 954-499-2289 OR 800-440-9554 bhvac@trane.com	AMEREX CORPORATION (FIRE PROTECTION SYSTEMS) 7595 GADSDEN HIGHWAY PANAMA CITY, FL 32401 850-797-1779	ENTERA SIGNS (AWNINGS, CANOPIES AND SIGNS) 1200 ENTERA DRIVE PANAMA CITY, FL 32401 850-797-1779	GAYLORD INDUSTRIES (HOODS) 10900 SOUTH AVERY STREET FLUJATIN, OR 97062 JOHN ANDERSON: 971-223-1238 john.anderson@gaylordusa.com	FACILITY CONCEPTS, INC (FCI) (DECOR) 7676 ZIONSVILLE ROAD INDIANAPOLIS, IN 46288 KEN WEAVER: 800-915-8890 EXT. 103 kweaver@fcibus.com CALVIN DURR: 800-915-8890 EXT 303 cdurr@fcibus.com
BERRIDGE ROOFING (METAL ROOF) TYLER HALL SAN ANTONIO, TX 210-650-7047	TAMKO ROOFING PRODUCTS (FLAT ROOFING) P.O. BOX 1404 JOPLIN, MO 64802 800-641-4691 www.sanjamarc.com OR CONTACT HAINES, JONES, & CADBURY (MISCELLANEOUS)	SAN JAMAR (RESTROOM ACCESSORIES & SUPPLIES) 555 KOOPMAN LANE ELKHORN, WI 262-723-6133 www.sanjamarc.com OR CONTACT HAINES, JONES, & CADBURY (MISCELLANEOUS)	AMERICAN STANDARD (TOILET, URINAL, FAUCETS) 1 CENTENNIAL AVE. PISCATAWAY, NJ 08855 800-442-1902 OR CONTACT: HAINES, JONES, & CADBURY (MISCELLANEOUS)	AMERICAN STANDARD (TOILET, URINAL, FAUCETS) 1 CENTENNIAL AVE. PISCATAWAY, NJ 08855 800-442-1902 OR CONTACT: HAINES, JONES, & CADBURY (MISCELLANEOUS)	AMERICAN STANDARD (TOILET, URINAL, FAUCETS) 1 CENTENNIAL AVE. PISCATAWAY, NJ 08855 800-442-1902 OR CONTACT: HAINES, JONES, & CADBURY (MISCELLANEOUS)	SIGN RESOURCE (AWNINGS, CANOPIES AND SIGNS) 6135 DISTRICT BLVD. TULSA, OK 74145 KEVIN RUBBOTOM RAMON ORTIZ: 323-326-6463 rortiz@signresource.com	LANCER (DRINK DISPENSERS) 6655 LANCER BLVD SAN ANTONIO, TX 78219 MIKE KRATWETZKE: 817-692-5094 michael.kratwetzke@lancercorp.com	INTERIOR SYSTEMS, INC (DECOR) 241 NORTH BROADWAY, SUITE 600 MILWAUKEE, WI 53202 JIM ZIELINSKI: 414-232-3502 Jzielinski@isiamerica.com JASON FREDRICKSON: 414-224-0972 Jfredrickson@isiamerica.com
FIRESTONE METAL PRODUCTS (METAL ROOF) 250 WEST 96TH STREET INDIANAPOLIS, IN 46260 YUSUKE KOREEDA: 615-345-9991 koreedayusuke@firestonebp.com	BASF CORPORATION (POLYURETHANE ROOFING SYSTEMS) 1703 CROSS POINT AVE HOUSTON, TX 77054 MOSES M CLARK, JR.: 315-263-4665	UNIVERSAL MANUFACTURING (RESTROOM ACCESSORIES) 5366 CRESTVIEW DR. MEMPHIS, TN 38134 901-458-5881 800-821-1414			ALLEN INDUSTRIES, INC (AWNINGS, CANOPIES AND SIGNS) 11351 49TH STREET NORTH CLEARWATER, FL 33762 THERESA TRIMMER: 800-677-3075 EXT. 3422 theresa.trimmer@allenindustries.com	NIECO CORPORATION (BROILERS) 7950 CAMERON DRIVE WINDSOR, CA 95492 CHRISTINA NEAT: 707-284-7100 sales@nieco.com	COMMERCIAL INTERIOR MANUFACTURERS, INC (LIMITED DÉCOR ITEMS) 158 HOLLY STREET JASPER, GA 30143 706-253-4761 STEVE BOUDREAU steve@cimgbiz.com AUSTIN HOLAN austin@cimgbiz.com	
<b>DIVISION 8 - DOORS AND WINDOWS</b> QUIKSERV (DRIVE-THRU WINDOWS) 11441 BRITTON MOORE PARK DRIVE HOUSTON, TX 77041 800-388-8307 STEVEN BERT sbert@quikserv.com	MARLITE (DOOR, ALUMINUM FRAMES) 202 HARGER STREET DOVER, NH 04822 800-377-1221 KURT HORSTMANN khorstmann@marlite.com			<b>DIVISION 16 - ELECTRICAL</b> LSI INDUSTRIES INC. (INTERIOR AND EXTERIOR LIGHTING, SURVEYS AND PHOTOMETRICS) 10000 ALLIANCE ROAD CINCINNATI, OH 45242 BRITTANY KOESTER: 513-372-3391 OR 513-315-3725	SECURITY LIGHTING SYSTEMS (EXTERIOR SITE AND BUILDING LIGHTING, SURVEYS AND PHOTOMETRICS) 2100 COLF ROAD, SUITE 460 ROLLING MEADOWS, IL 60008 ERIC HILLESLAND: 630-636-8493 ehillesland@securitylighting.com	LEKTRON, INC (PARAPET LIGHT BANDS) 7450 E. 46th PLACE TULSA, OK 74145 KEVIN RUBBOTOM 800-634-4059 OR 918-622-4978 EXT 309 krubottom@lektroninc.com	PITCO (FRYERS) 10 FERRY STREET CONCORD, NH 03301 BONNIE BOLSTER: 603-230-5529 bbolster@pitco.com	NAUTICAL FURNISHINGS, LLC (LIMITED DÉCOR ITEMS) 60 NW 60TH STREET FT. LAUDERDALE, FL 33309 MICHAEL HOGUND: 954-771-1100 mhogund@nauticalfurnishings.com
READY ACCESS (DRIVE THRU WINDOWS & AIR CURTAINS) 1815 ARTHUR DRIVE WEST CHICAGO, IL 60185 KELLY MCGOLDRICK: 800-621-5045 EXT 113 kelly@ready-access.com	UNIVERSAL MANUFACTURING CO (HOLLOW METAL FRAMES & DOORS, WOOD DOORS, HARDWARE (HINGES, LOCKS, ETC)) 5366 CRESTVIEW RD. MEMPHIS, TN 38134 901-458-5881 OR 800-821-1414			3M SOUND PRODUCTS (DRIVE-THRU SOUND SYSTEM & SATELITE ANTENNA) 3M CENTER BLDG. 223-2N-20 ST. PAUL, MN 55144-1000 JOE CIAMPI: 704-771-2449 jciamp@mnm.com	CREE / HERMITAGE LIGHTING NATIONAL ACCOUNTS (INTERIOR AND EXTERIOR LIGHTING, SURVEYS AND PHOTOMETRICS) 3640 TROUSDALE DRIVE NASHVILLE, TN 37204 STEVE FRIEDMAN: 847-830-1444 OR WYATT CULVER: 615-843-3379 800-264-3383	FRANKE (KITCHEN EQUIPMENT, SMALLWARES, HOODS) 800 AVIATION PARKWAY SMYRNA, TN 37086 CUSTOMER SERVICE: 800-877-5178 fr-bkparts.us@franke.com	TAYLOR ULTIMATE SERVICES, INC (SHAKE MACHINE, FROZEN BEVERAGE MACHINE) 1780 NORTH COMMERCE PKWY WESTON, FL 33326 TINA SMART: 954-217-9100 tina@taylorus.com	ARMSTRONG STRATEGIC ACCOUNTS (CEILING TILE) 2500 COLUMBIA AVENUE LANCASTER, PA 17604 LOUIS JOHN: 407-697-6768 800-442-4212 ljohn@armstrongceilings.com OR ARMSTRONG STRATEGIC ACCOUNTS (800) 442-4212
	3M COMMERCIAL CORE DIVISION (WINDOW FILM) 3M CENTER ST. PAUL, MN 704-771-2449 OR 800-328-0033			SECURITY PRODUCTS, INC (REAR DOOR ALARM) 30950 COREAL DRIVE, SUITE B COARSEGOLD, CA 93614 BOB BARR OR EMILY BEACH: 800-452-5276 orders@securityproductsinc.com	HM ELECTRONICS, INC (HME) (DRIVE-THRU SOUND SYSTEM) 14110 STOWE DRIVE POWAY, CA 92064 PAUL KOOSER: 800-848-4468 paulk@hme.com	QUALSERV SOLUTION (KITCHEN EQUIPMENT, SMALLWARES) 7400 SOUTH 28th STREET FORT SMITH, AR 72908 BECKY DUBOSE: 479-221-1467 bdbouse@qualserveolutions.com	PLAY SYSTEMS (DIV. OF SUPERIOR INT. INDUSTRIES, INC) (PLAYGROUND MANUFACTURER) 1050 COLUMBIA DR. CARROLLTON, GA 30717 JUAN CUELLAR: 770-832-6660 EXT. 1517 jcuel@allbrands.com	USG INTERIORS (CEILING TILE) CHRIS BENJAMIN: 312-436-5458 cbenjamin@usg.com
				N.C.A. NATIONAL HVAC PRODUCTS, LLC. (MASTER CONTROL SYSTEM) 4585 140 AVENUE NORTH CLEARWATER, FL 33762 877-530-0078	SUNCOAST ENVIRONMENTAL CONTROLS, INC. (ELECTRICAL SWITCH GEAR) 2200 SKYLINE DR LARGO, FL 34643 877-544-6679	H & K INTERNATIONAL KITCHEN EQUIPMENT, (SMALLWARES, HOODS) 2200 SKYLINE DR DALLAS, TX 75223 HEATHER VALVERDE: 214-818-3521 heather.valverde@hik.com	SPI INDUSTRIES (PLAYGROUND MANUFACTURER) BOX 100, R.R. #2, JOINT ST. SHALLOW LAKE, ON, NOH 2K0 CANADA CYNTHIA MASTERS: 519-935-2174 OR 519-378-4356 cmasters@spiplastics.com www.spiplastics.com	MITYLITE (2020 LIGHT CHAIRS AND BARSTOOLS) 1301 WEST NORTH OREM, UT KAREN EDWARDS: 561-213-2810
				HILL PHOENIX POWER SYSTEMS DIVISION (FACTORY INTEGRATED SWITCH GEAR) 8166 INDUSTRIAL BLVD COVINGTON, GA 30014 PAUL BROWN: 678-699-0129 paul.brown@hiphoenix.com	TRANE CO. (ENERGY MANAGEMENT PANEL) 2884 CORPORATE WAY MIRAMAR, FL 33025 AL MARTINEZ: 954-499-2289 amartinez@trane.com	INTERNATIONAL COLD STORAGE (ICS) (WALK-IN COOLERS / FREEZERS, DRY STORAGE COMPARTMENTS) 215 EAST 13th STREET ANDOVER, KS 67002 LISA MIDORE: 800-835-0001 EXT 4177 lisa.midore@icso.com	SOFT PLAY, LLC (PLAYGROUND MANUFACTURER, SAFETY SURFACING, NON-CONTAINED PLAY EQUIPMENT) 13620 EAST REESE BLVD, SUITE 300 HUNTERSVILLE, NC 28078 JIM SWINTEK: 704-948-3448 jim.swintek@softplay.com	TWENTY FOUR 7 GLOBAL SOLUTIONS, INC. (2020 LIGHT AND GARDEN GRILL CHAIRS AND BARSTOOLS) 898 NORTH SEPULVEDA BLVD, SUITE 465 EL SEGUNDO, CA 90245 BARRY WOON: 323-319-2722
				3M FOOD SERVICE BUSINESS (DRIVE-THRU COMMUNICATION PRODUCTS, MAINTENANCE PRODUCTS, MATTING AND TRACTION PRODUCTS, MONITOR STRIPS, TAPES AND DISPENSERS, LAMINATING SYSTEMS) 3M CENTER BLDG. 223-2N-20 ST. PAUL, MN 55144-1000 JOE CIAMPI: 704-771-2449 jciamp@mnm.com			MOSS RETAIL AND ENVIRONMENTS (GRAPHICS) 2643 WEST CHICAGO AVE CHICAGO, IL 60622 DJ SCANDIFF: 773-435-7600 EXT 617 ROB LORTS: 773-435-7600 EXT 655 rlorts@mossinc.com	WAUSAU TILE, INC (EXTERIOR DÉCOR) P.O. BOX 1520 WAUSAU, WI 54402-1520 STEVE THUT: 800-388-8728 EXT 320 stthut@wausautile.com
				HM ELECTRONICS, INC (HME) (DRIVE-THRU WIRELESS INTERCOMS, DRIVE-THRU SPEED OF SERVICE TIMERS, DIGITAL SURVEILLANCE SYSTEMS) 14110 STOWE DRIVE POWAY, CA 92064 PAUL KOOSER: 800-848-4468 paulk@hme.com			VGS, INC (GRAPHICS) 1696 MARYBETH MILL DRIVE, SW NORTH CANTON, OH 44709 GREG MOROZ: 201-528-9680 ORDER EMAIL: BURGERKING@VGS-INC.COM	<b>MISCELLANEOUS</b> HAINES, JONES, AND CADBURY (PACKAGE PRICING ON MULTIPLE ITEMS PLUMBING, TILE, RESTROOM ACCESSORIES, ETC) 310 SW 24TH STREET BENTONVILLE, AR 72712 BARRY BRYANT: 479-899-3555 barry.bryant@bjcnc.com


NO.	DATE	BY	NOTES
1	08/14/18	DB	FOR SUBMITTAL TO BKC
2	08/30/18	DB	REVISIONS SUBMITTAL TO BKC
3	09/19/18	DB	REVISIONS SUBMITTAL TO CITY
4	10/09/18	DB	REVISIONS TO CITY
5	11/05/18	DB	REVISIONS TO CITY
6	11/05/18	DB	REVISIONS TO CITY

Drawn By: DB  
Checked: SB  
Scale: AS NOTED  
Date: 08.01.18

ALL RIGHTS RESERVED. NO PART OF THESE DRAWINGS OR SPECIFICATIONS MAY BE REPRODUCED OR TRANSMITTED IN ANY FORM OR BY ANY MEANS, ELECTRONIC OR MECHANICAL, INCLUDING PHOTOCOPYING, RECORDING, OR BY ANY INFORMATION STORAGE AND RETRIEVAL SYSTEM, WITHOUT PRIOR WRITTEN AUTHORIZATION FROM THE ARCHITECT.

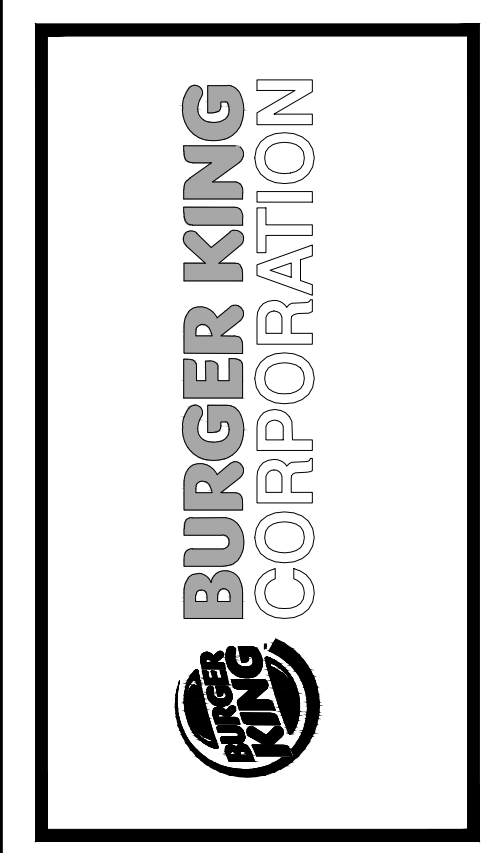

**TGI GROUP INC**  
3771 CALHOUN DRIVE  
FARMINGTON HILLS, MI 48331  
P: (248) 496-9000 F: (248) 426-7004

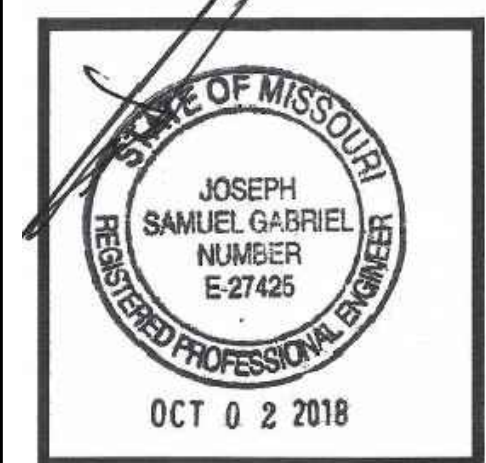

PROJECT: BURGER KING #123  
1517 S. BELT HWY  
ST. JOSEPH, MO 64507

SHEET TITLE: MANUFACTURES AND SUPPLIERS