

 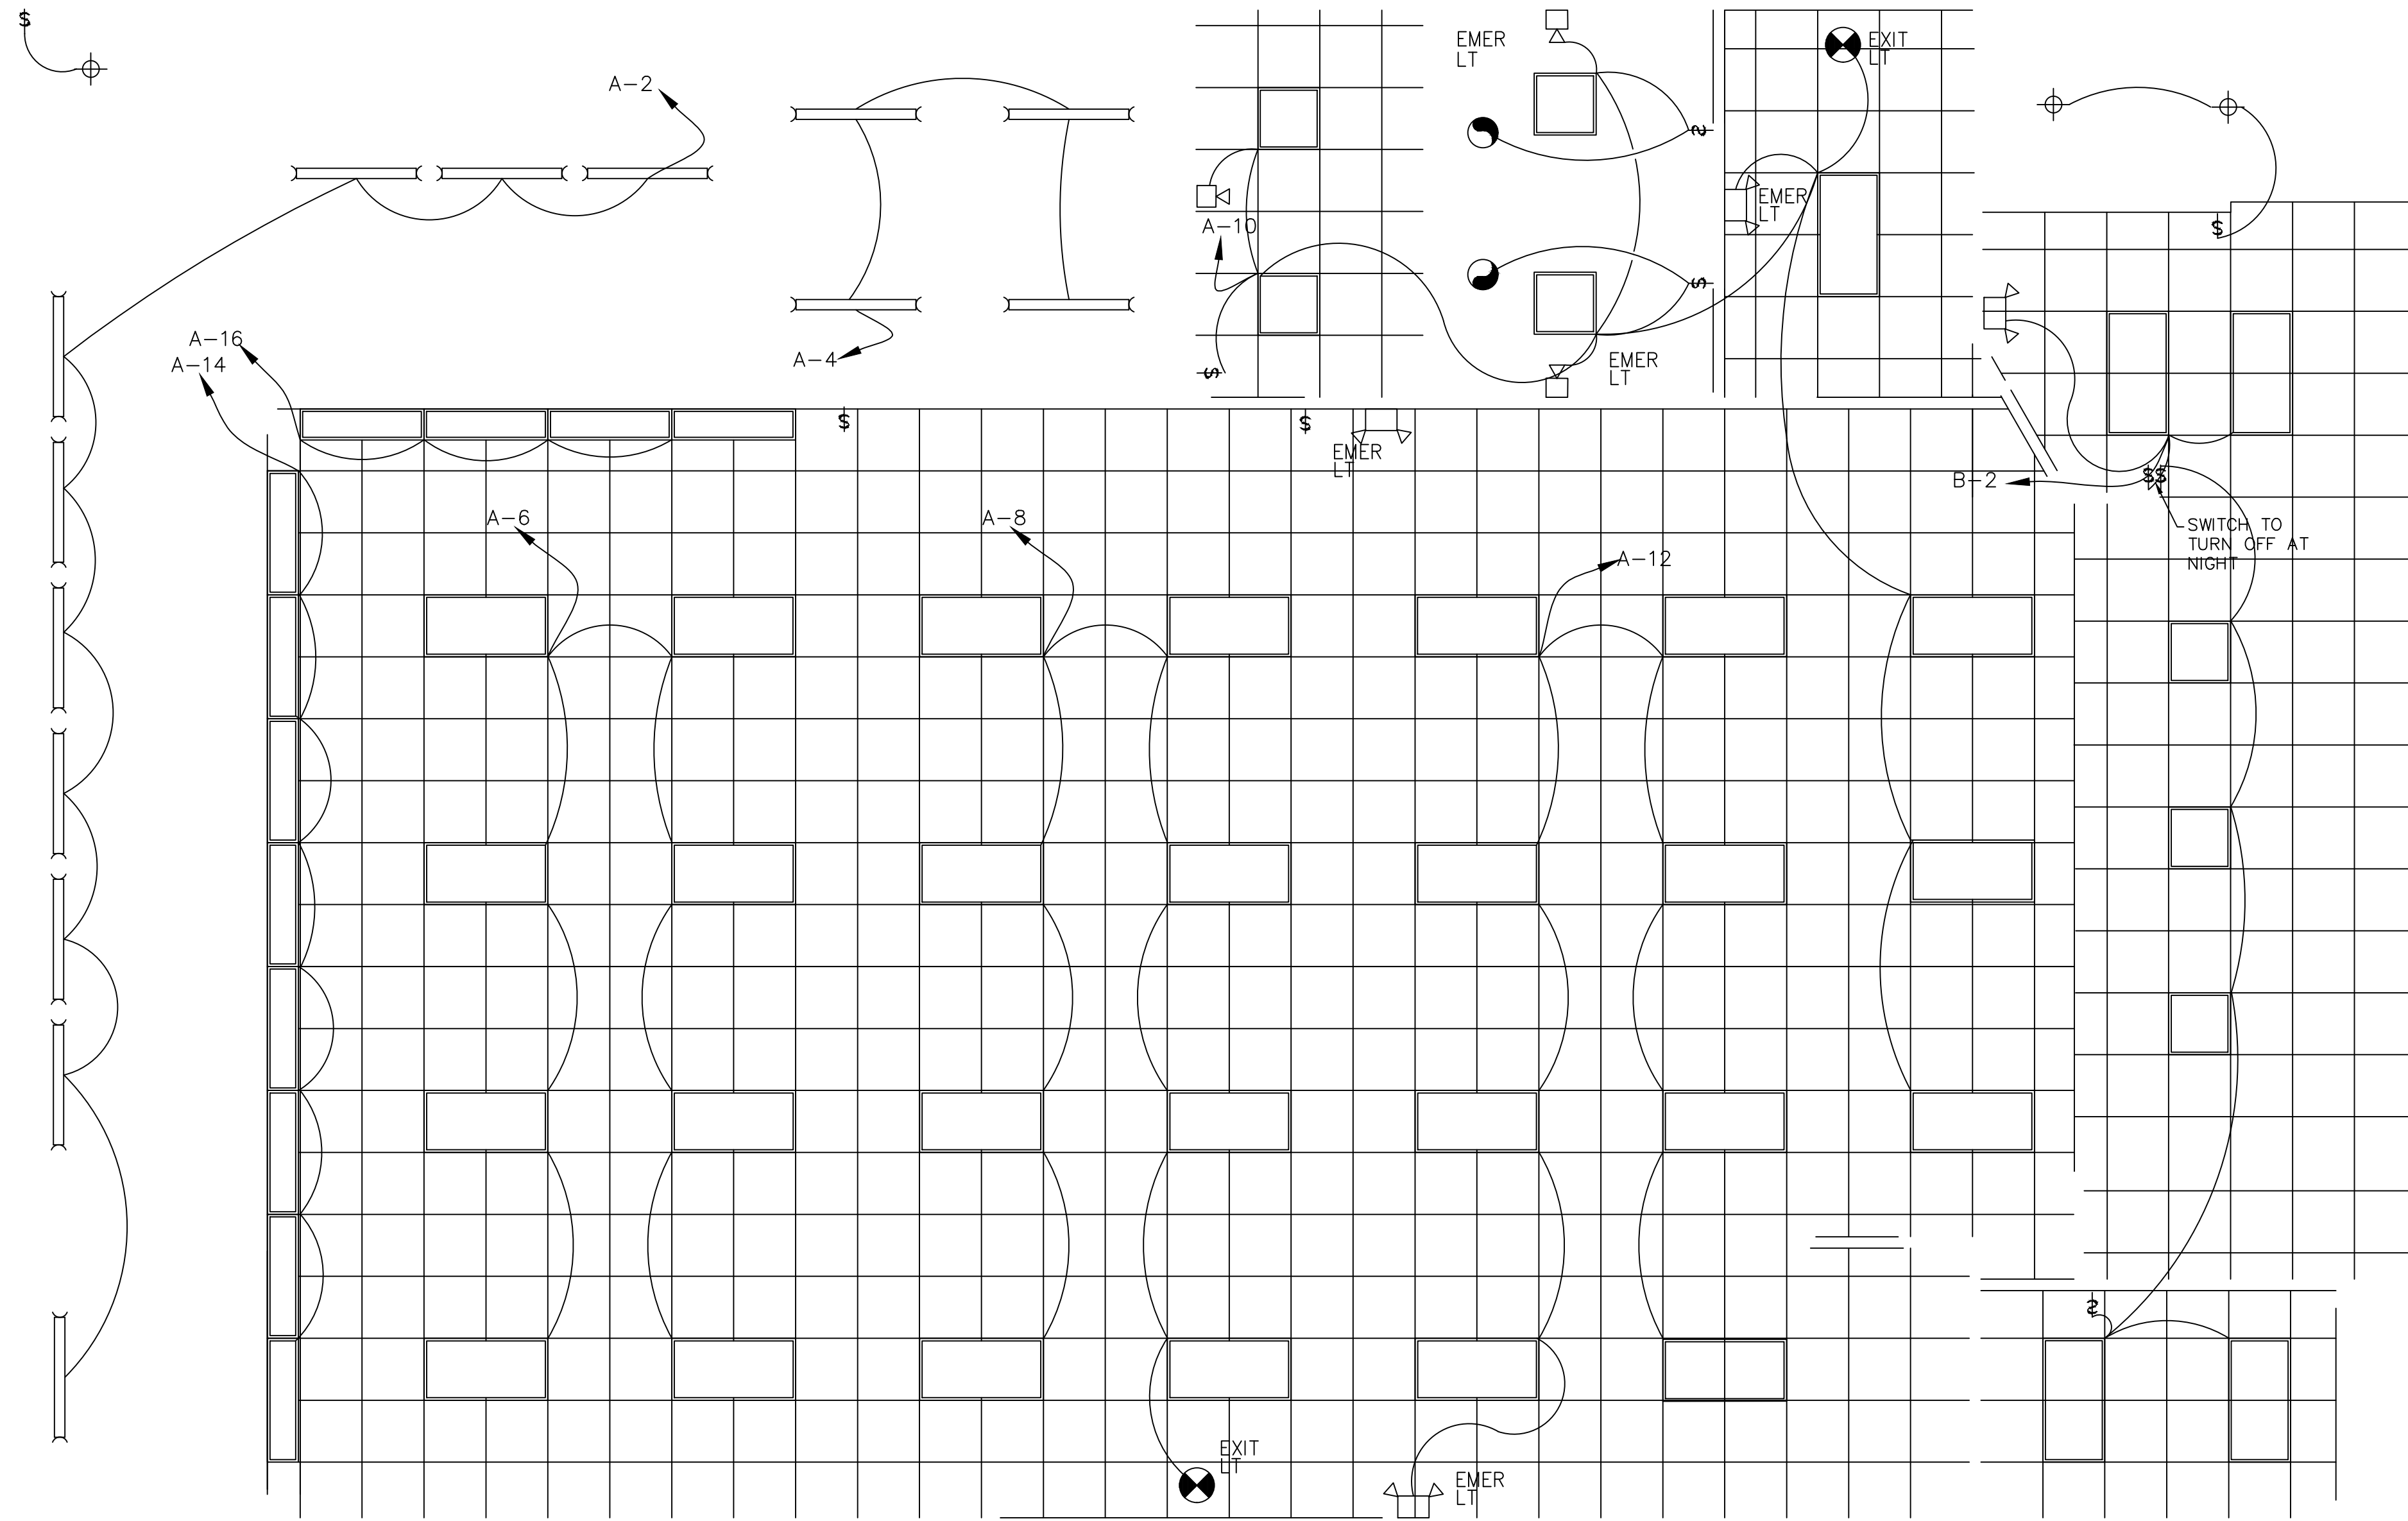


ELECTRICAL LEGEND:	
	ELECTRICAL POWER DISCONNECT
	TOILET EXHAUST FAN TO LIGHT CRT
	DUPLEX OUTLET 125V 15A
	DUPLEX OUTLET - CEILING HEIGHT
	ELECTRICAL JUNCTION BOX
	LAY-IN LIGHT FIXTURE
	BATTERY OPERATED EXIT WAY LIGHTING
	EXIT SIGN BATTERY OPERATED
	SWITCH SINGLE POLE 125V 15A(3 FOR 3-WATTS)
	CONDUITS CONCEALED WHERE POSSIBLE
	HOME RUN TO PANEL
	120 /240V 1Ø OR 3Ø AS NOTED TO 6'-0" AFF
	REFER TO LIKE NUMBERED NOTES
	FLUORESCENT STRIP LIGHT

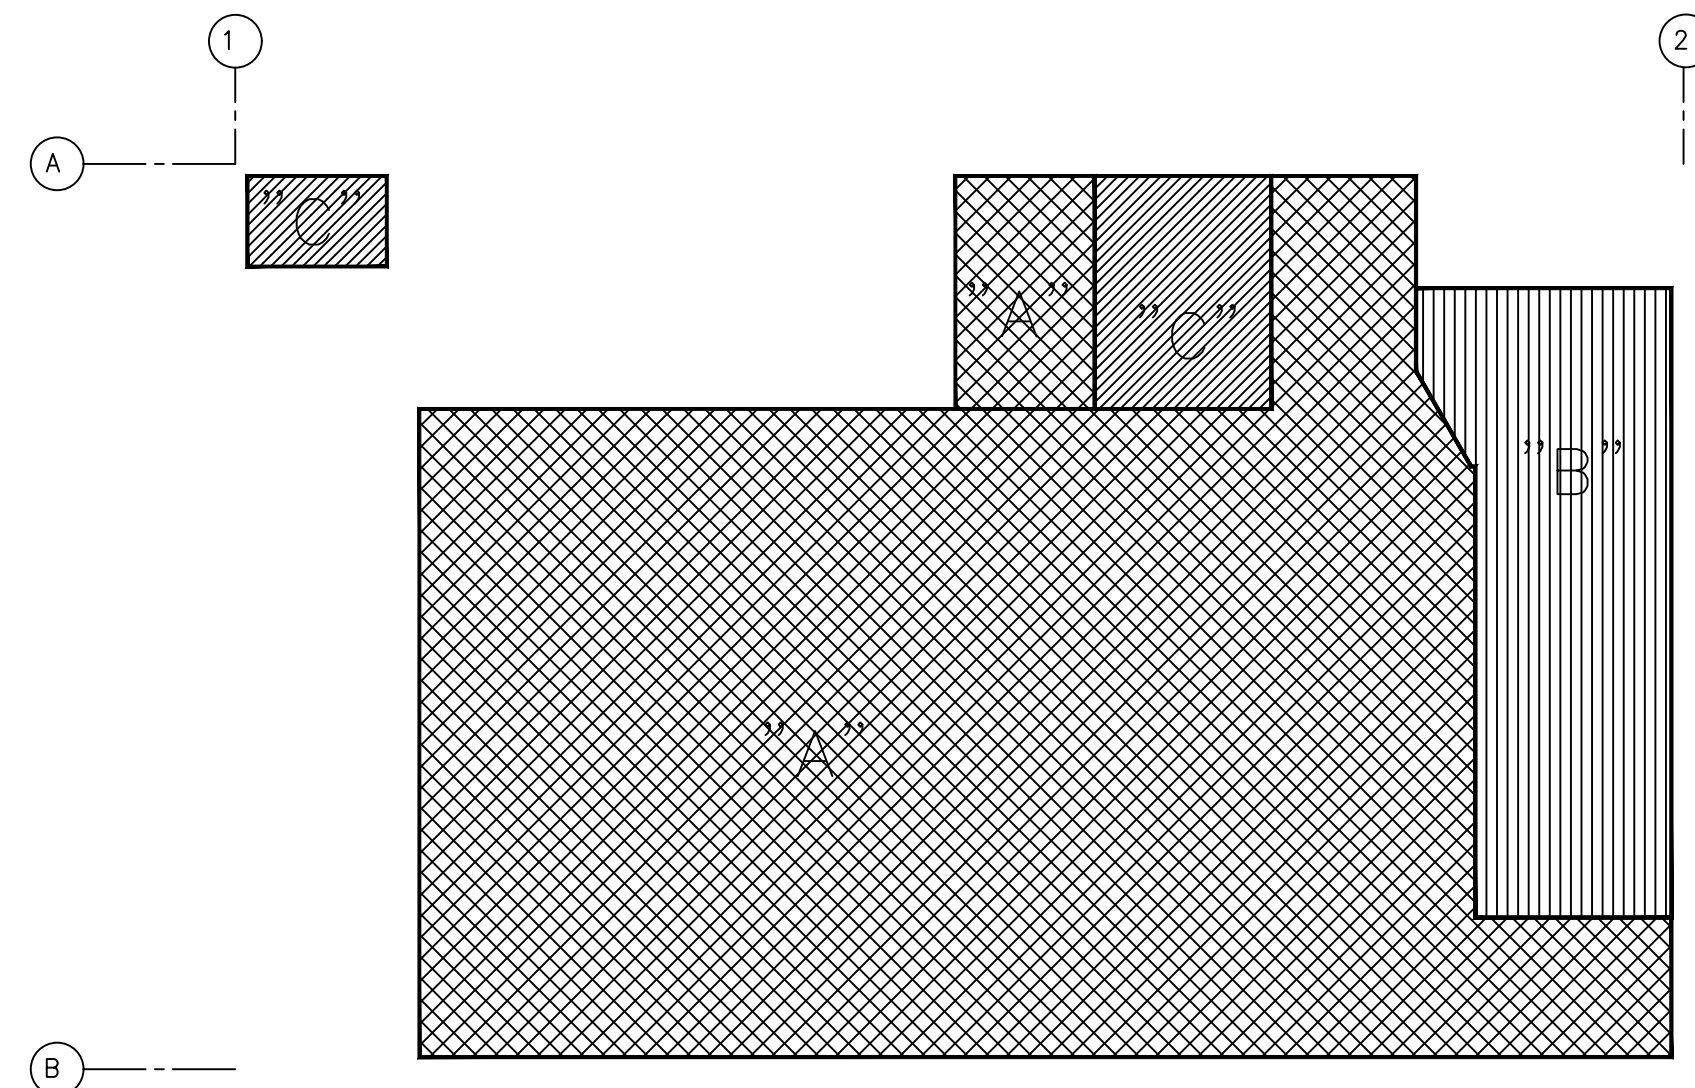

ELECTRICAL FLOOR PLAN / LIGHTING


SCALE: 1/4" = 1'-0"



LEGEND:	
	AREA "A" TRAY CEILING
	AREA "B" VINYL CEILING
	AREA "C" DRYWALL CEILING

CEILING PLAN KEY

SCALE 3/32" = 1'-0"

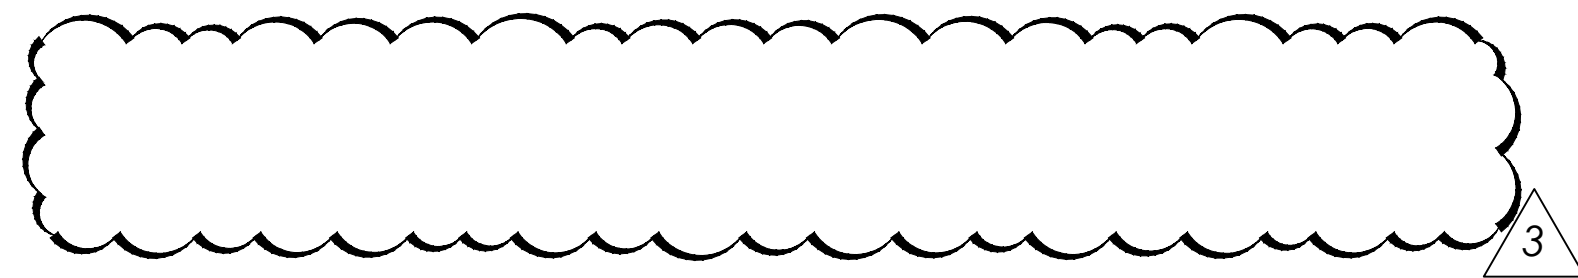

3