



3 FRENCH DRAIN FOR WALK-IN COOLER CONDENSATE

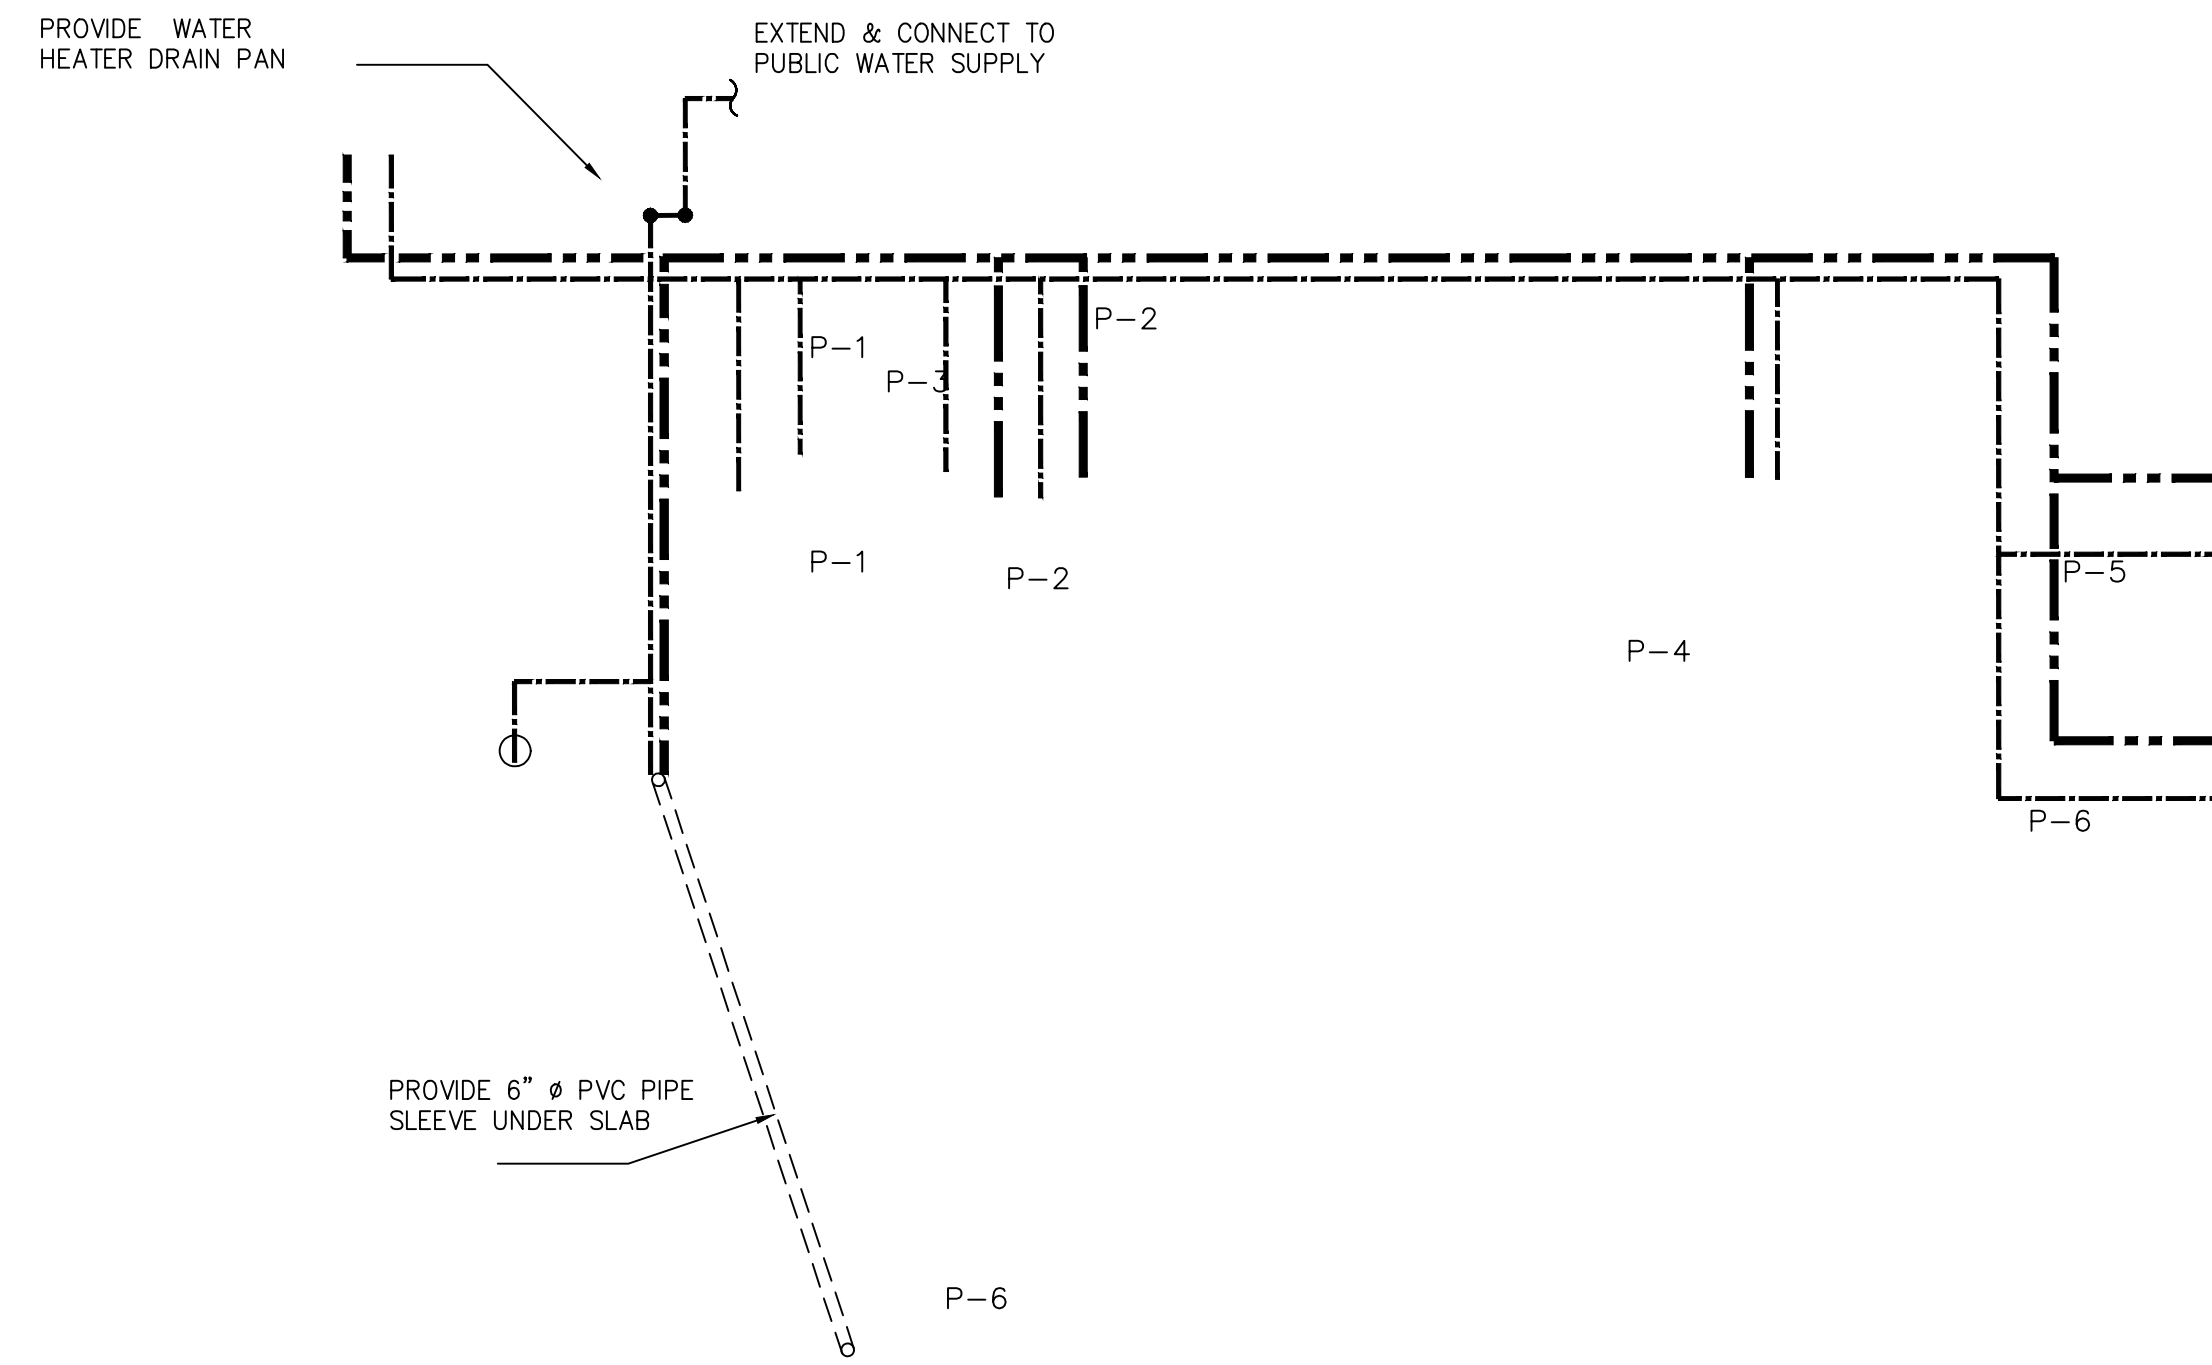

NOTE:

1. PROVIDE THERMAL EXPANTION PROVISION FOR A WATER HEATER TO COMPLY WITH FBC SEC 504 & 607.3
2. PROVIDE 8" X 12" DEEP PVC FRENCH DRAIN FOR COOLER/FREEZER CONDENSATE LINES. LOCATION TO BE AS CLOSE TO DISCHARGE AS POSSIBLE.

3

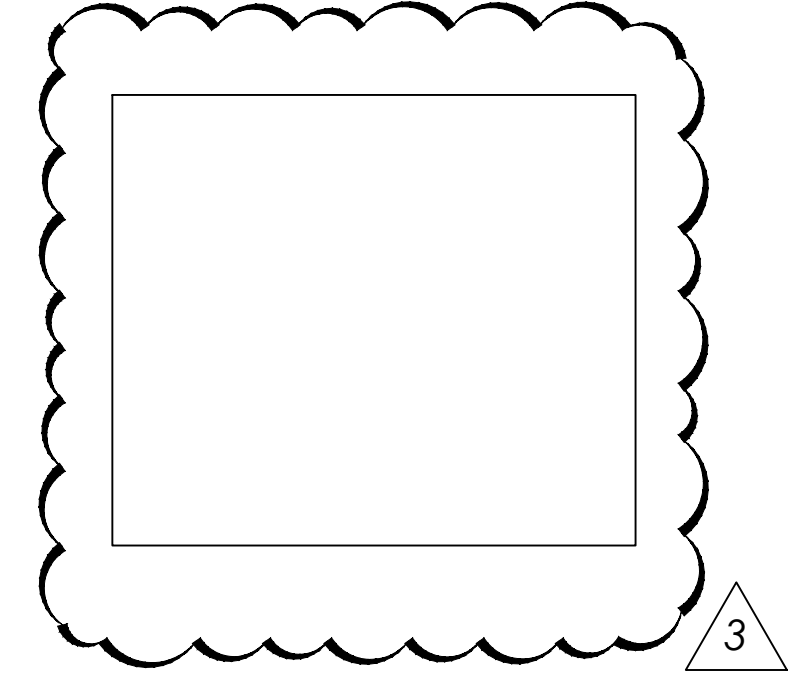

PLUMBING PLAN PIPING

SCALE: 1/4" = 1'-0"

3