


1 REFLECTED CEILING PLAN
 SCALE: 1/4" = 1'-0"

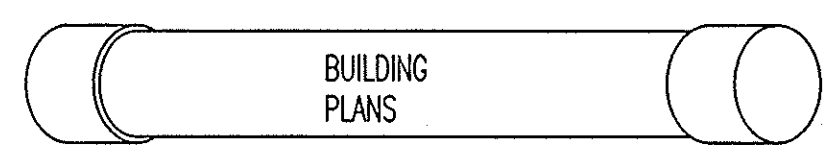

BUILDING PLANS

2 BUILDING PLAN CONTAINER
 SCALE: NOT TO SCALE

- GENERAL NOTES:**
- GENERAL CONTRACTOR TO COORDINATE DINING ROOM LIGHTING WITH APPROVED INTERIOR DECOR PLANS.
 - CONTRACTOR SHALL VERIFY FIXTURE QUANTITIES AND ALSO MAKE PROPER ADJUSTMENTS FOR ANY CHANGES IN PLAN DUE TO ADDITIONAL REQUIREMENTS, LOCAL CODES, ETC.
 - SEE FINISH SCHEDULE AND FINISH MATERIALS LIST FOR MATERIALS, CEILING HEIGHTS, SPECIFICATIONS, AND ADDITIONAL INFORMATION.
 - SEE MECHANICAL DRAWINGS FOR INFORMATION REGARDING THE HVAC SYSTEM.
 - ALL FIXTURES SHALL BE LOCATED IN CENTER OF CEILING TILES UNLESS OTHERWISE NOTED.
 - SEE SHEET E101 FOR LIGHTING LAYOUT REQUIREMENTS AND ADDITIONAL INFORMATION.

LEGEND		
SYMBOL	DESCRIPTION	REMARKS
[Symbol]	1' x 4' FLUORESCENT FIXTURE	RECESSED (SEE SHEET E101 FOR SPECS.)
[Symbol]	2' x 4' FLUORESCENT FIXTURE	RECESSED (SEE SHEET E101 FOR SPECS.)
[Symbol]	2 x 4 ACOUSTICAL TILE	SEE ROOM FINISH SCHEDULE AND FINISH MATERIAL LIST FOR SPEC.
[Symbol]	2 x 2 ACOUSTICAL TILE	SEE ROOM FINISH SCHEDULE AND FINISH MATERIAL LIST FOR SPEC.
[Symbol]	EXIT SIGN	WALL MOUNTED
[Symbol]	EXIT SIGN	CEILING MOUNTED (IF VEST. IS USED AND REQUIRED BY CODE)
[Symbol]	RETURN AIR GRILLE	SEE SHEET M101 FOR SPECS.
[Symbol]	SUPPLY AIR GRILLE	SEE SHEET M101 FOR SPECS.
[Symbol]	8' x 16" VENT GRILLE	
[Symbol]	EMERGENCY LIGHT FIXTURE, BATTERY BACK-UP	SEE SHEET E101 FOR SPECS.
[Symbol]	6" RECESSED CAN LIGHT FIXTURE	SEE SHEET E101 FOR SPECS, COORDINATE FINAL LOCATIONS WITH DECOR DRAWINGS

BY		DATE	
REV.		DESCRIPTION	
 WIGHTMANPETRIE SURVEYING ENGINEERING ENVIRONMENTAL LANDSCAPE ARCHITECTURE 412 South Lafayette Blvd. South Bend, IN 46601 p: 574.232.4388 f: 574.232.4333			
Burger King Restaurant Kentwood, Michigan BRAYOKILO, INC.		Mishawaka, Indiana 4220 Edison Lakes Parkway REFLECTED CEILING PLAN	
DESIGNED BY:	STEVE LACLUYSE		
REVIEWED BY:	MATT SCHUSTER		
DRAWN BY:	MATT SCHUSTER		
DATE:	MAY 2, 2011		
JOB NUMBER:	2010-5068		
SCALE:	AS SHOWN		
X-1710-A201			

I:\A\2010 Projects\2010-5068\A\A201-1710-A201-REF CEILING.dwg, 12/5/2011 11:39:08 AM