
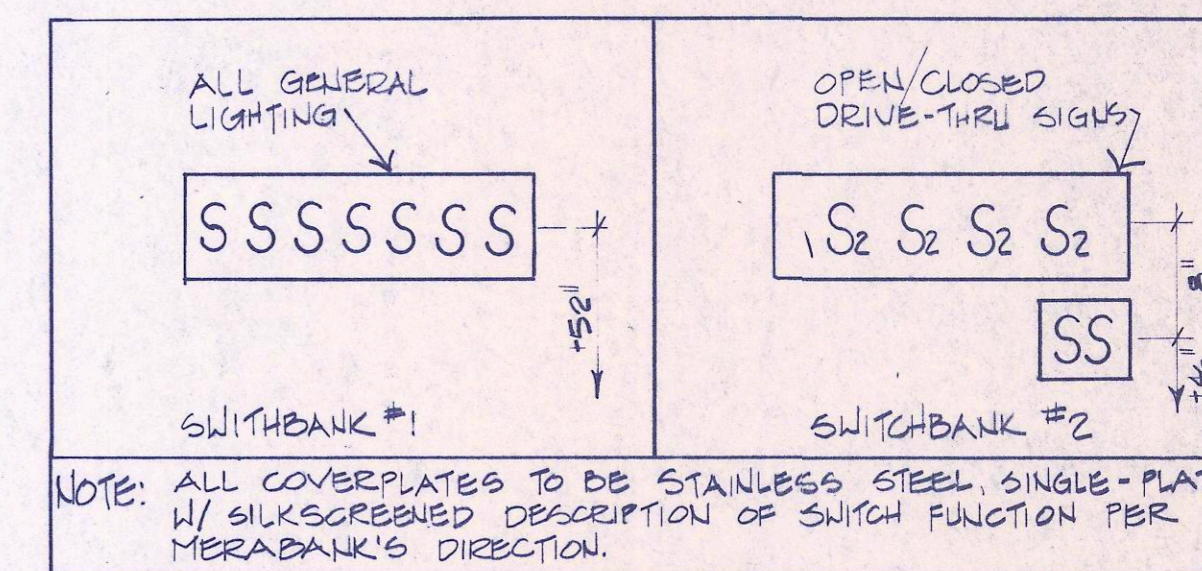


**ELECTRICAL LIGHTING PLAN**  
1/8"=1'-0"

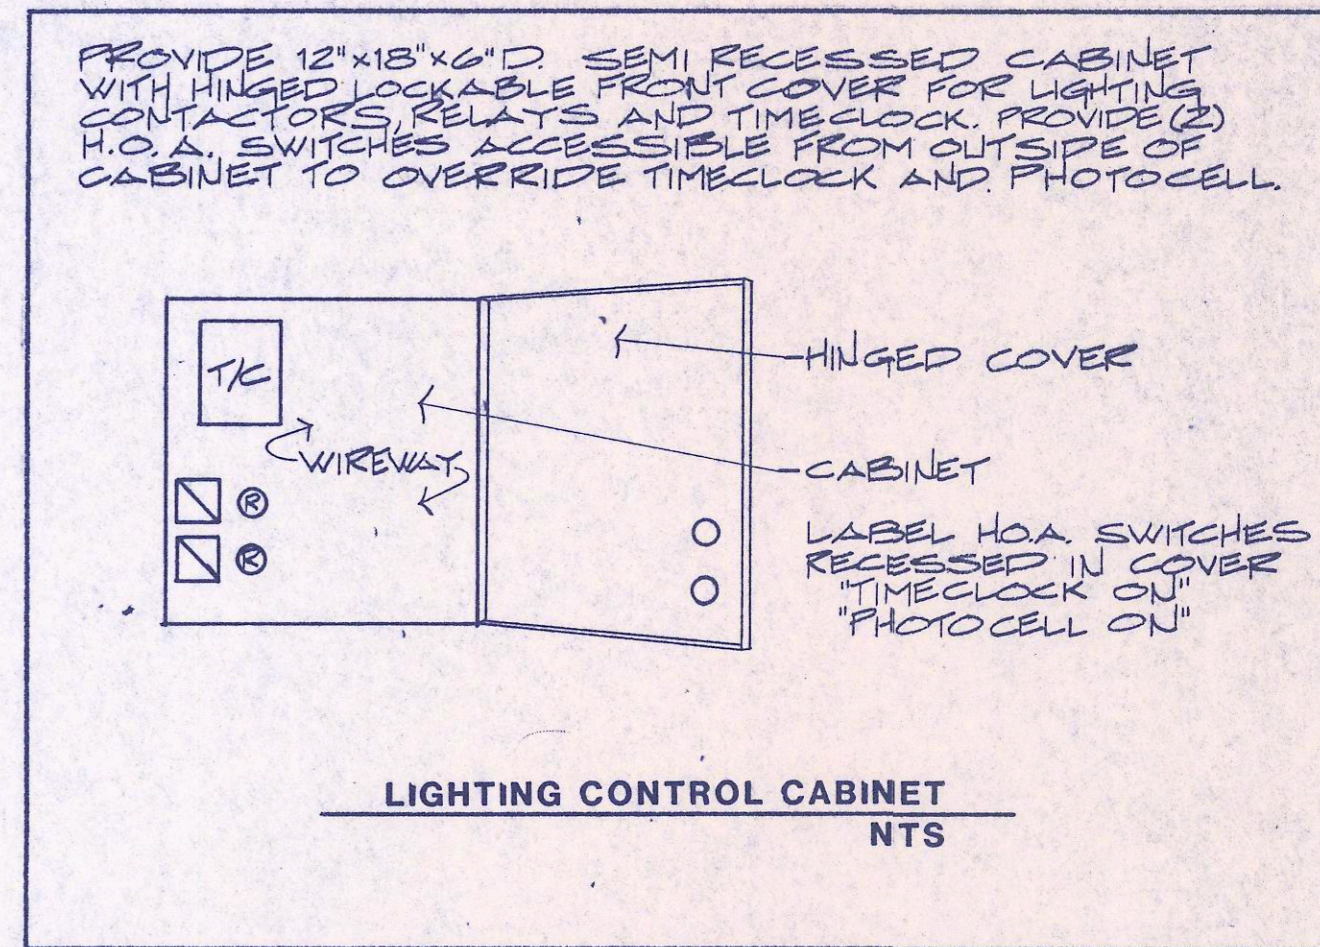

LIGHTING FIXTURE SCHEDULE		
A	LITHONIA #2PM3-G-440-32-ES	(4)F40/W/W/M 2'x4' RECESSED GRID FLUORESCENT PARABOLIC TROFFER.
B	LITHONIA #2SP-440-A12.125-ES	(4)F40/W/W/M 2'x4' RECESSED GRID FLUORESCENT TROFFER.
C	LITHONIA #2PM3-F-440-32-ES	(4)F40/W/W/M 2'x4' RECESSED FLANGED FLUORESCENT.
D	LITHONIA #PM3-P-240-16-ES	(2)F40/W/W/M 1'x4' RECESSED FLANGED FLUORESCENT PARABOLIC TROFFER.
E	PRESCOLITE #CFR813-572-HPF	(2)F13/TT/27K RECESSED FLUORESCENT DOWNLIGHT.
F	LITHONIA #2PM3-G-440-32-ES-EL	(4)F40/W/W/M 2'x4' RECESSED GRID FLUORESCENT PARABOLIC (EMERG.)
G	VISA #CB450-SHT	(2)F13/TT/27K 'PL' FLUORESCENT WALL SOUNDR MTD. 6'-0" A.F.F.
H	LITHONIA #SS-230-120-ES	(2)F30/W/W/M 3'-4" STAGGERED STRIP FLUORESCENT MTD. IN COVE.
K	LITHONIA #SS-240-120-ES	(2)F40/W/W/M 4'-4" STAGGERED STRIP FLUORESCENT MTD. IN COVE.
L	ACTRON #2-614-OCRG	FURN. WITH FIXT. CEILING MTD. OPEN/CLOSED DRIVE-THRU SIGN.
M	MARCO #LES-20386-DL	(1)175 W.M.H. EXTERIOR RECESSED H.I.D. SQUARE DOWNLIGHT.
N	LIGHTOLIER #3345348	(1)100 W.M.H. EXTERIOR RECESSED H.I.D. DOWNLIGHT.
P	PRESCOLITE #7009	(1)75W A19 SURFACE MTD. SQUARE INCANDESCENT DRUM
R	EMCO #PAD-175H-120-DB-SSA14	(1)175 W.M.H. PARKING LOT H.I.D. POLE MTD. LUMINAIRE-SEE DETAIL SHEET E1.0
S	ALKO #SP-213-S	(2)T5-13W UNDER COUNTER FLUORESCENT TASK LIGHT
T	HUBBELL #2-308	(2)150 PAR 38/FL DOUBLE CLUSTER FLOOD WALL MTD. AT #7'-6" A.F.F.
X	LITHONIA #ESIR-EL-120	FURN. WITH FIXT. EMERGENCY EXIT SIGN
U	EMCO #BR8L-100H-DB	(1)100W M.H. BOLLARD LUMINAIRE-SEE MTC. DETAIL SHEET E1.0

NOTE: ALL FLUORESCENT FIXTURES SHALL HAVE ENERGY SAVING LAMPS & BALLASTS  
ALTERNATE FIXTURE MANUFACTURERS ARE ACCEPTABLE WITH PRIOR APPROVAL FROM ARCHITECT, ENGINEER & MERRABANK.

ALL CONCEPTS, DESIGNS, AND DATA INDICATED ON THESE DOCUMENTS ARE THE SOLE PROPERTY OF PETERSON ASSOCIATES ENGINEERS, INC. AND SHALL NOT BE USED FOR ANY OTHER PURPOSE THAN ORIGINALLY INTENDED WITHOUT THE WRITTEN PERMISSION OF THE ENGINEER.

PETERSON ASSOCIATES  
CONSULTING ENGINEERS INC.

1717 East Morten, Suite 100  
Phoenix, Arizona 85020  
602-943-4116  
Job No 88875

Architecture/Planning/Interior Design  
**LENDRUM DESIGN GROUP**  
3033 North Forty-fourth Street  
Phoenix, Arizona 85018  
602/955-2100

*Charles O. Lendrum*  
Principal

**MeraBank**  
KINGMAN, ARIZONA  
BRANCH BANK

JOB NUMBER  
DATE  
11-11-88  
DRAWN  
JKS  
CHECKED  
JJS  
SHEET TITLE  
ELECTRICAL  
LIGHTING PLAN

SCALE  
1/8"=1'-0"  
REVISIONS

DRAWING NUMBER  
**E2.0**