


ELECTRICAL FLOOR PLAN

1/8"=1'-0"

PLAN NOTES

- 1 PAD MOUNT TRANSFORMER
- 2 UNDERGROUND PULL SECTION
- 3 SERVICE ENTRANCE SECTION (S.E.S.)
- 4 PANEL "A"
- 5 PANEL "B"
- 6 OUTDOOR LIGHTING CONTROL CABINET (SEE DETAIL - SHEET E2.0)
- 7 TELEPHONE MOUNTING BOARD (T.M.B)
- 8 WATER HEATER - 2KW, 120V, 1PH.
- 9 STUB CONDUIT INTO ACCESSIBLE CEILING SPACE (SIZE AS NOTED)
- 10 ALL FEEDERS AND CABLE AT TELLERLINE TO BE ROUTED IN UNDER COUNTER RACEWAY (RACEWAY FURNISHED WITH MILLWORK).
- 11 PROVIDE 4"x4"x4" DEEP J-BOXES AT FLOOR FOR POWER, TELEPHONE, DATA/SECURITY FEEDS TO TELLERLINE. COORDINATE LOCATION WITH MILLWORK.
- 12 4"x4"x4" DEEP PULL BOXES IN WALL AT +12"
- 13 3/4"C. TO KIOSK CONTROL J-BOX AND 1"C. TO AUDIO J-BOX. COORDINATE EXACT REQUIREMENTS WITH KIOSK SUPPLIER.
- 14 A/C UNIT #1
- 15 A/C UNIT #2
- 16 CONDENSING UNIT - 11.1 FLA, 208V, 1PH.
- 17 FAN COIL UNIT - 1.6 FLA, 208V, 1PH.
- 18 AUDIO J-BOX SEE SHEET SV-1 FOR ADDITIONAL INFORMATION.

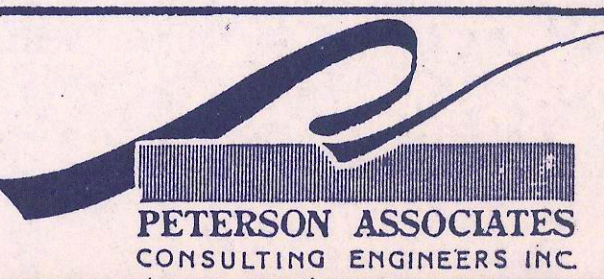

1717 East Morten, Suite 100
Phoenix, Arizona 85029
602-943-4116
Job No 88875

Architecture/Planning/Interior Design
LENDRUM DESIGN GROUP
3033 North Forty-fourth Street
Phoenix, Arizona 85018
602/955-2100

John D. ...
10/28/88

MeraBank
BRANCH BANK KINGMAN, ARIZONA

JOB NUMBER
DATE 11-11-88
DRAWN JKS
CHECKED JJS
SHEET TITLE
ELECTRICAL FLOOR PLAN

SCALE 1/8"=1'-0"
REVISIONS

DRAWING NUMBER
E3.0

ALL CONCEPTS, DESIGNS, AND DATA INDICATED ON THESE DOCUMENTS ARE THE SOLE PROPERTY OF PETERSON ASSOCIATES ENGINEERS, INC. AND SHALL NOT BE USED FOR ANY OTHER PURPOSE THAN ORIGINALLY INTENDED WITHOUT THE WRITTEN PERMISSION OF THE ENGINEER.