

**BURGER KING 20/20 GARDEN GRILL INTERIOR
INTERIOR LIGHT FIXTURE SCHEDULE**

06.01.21 STANDARD TRELIS (6" x 6")						
TYPE	VENDOR	CATALOG No.	New Part Number	WATTAGE	COLOR TEMP	REMARKS
A	NAUTICAL	BK304 & SP305-18-60D-927-03 LED EDISON STYLE 10 WATT		10	2700	SHAKER PENDANT LAMP
A1	NAUTICAL	BK-GG-A2 CUSTOM PENDANT LIGHT RED LED CLEAR ANTIQUE STYLE 6 WATT		10	2700K	RED PENDANT LIGHT
A2	NAUTICAL	BK-LT-11				GREEN CAST GUARD WAREHOUSE LIGHT
B	NAUTICAL	BK305 & LED 8W EDISON INCANDESCENT LED CLEAR ANTIQUE STYLE 6 WATT		6	2700K	BRONZE CAGE PENDANT LIGHT
B1	NAUTICAL	BK305 & LED 8W EDISON INCANDESCENT LED CLEAR ANTIQUE STYLE 6 WATT		6	2700K	BRONZE CAGE WALL SCONCE LIGHT
C6w	CREE	LR6-10L-30K-120V-A-DR-RC6-12W-GU24	LR6K-10L-30K/ RC6-UNI	12.5	3000	6" DIAMETER, WHITE, RECESSED DOWN LIGHT
	SECURITY	SLSD8XQL-LB6LEDA30KWH		14	3000	
	LSI	LCD6 13 LED 30 48 UE TR6RL HAZ WH		13	3000	
	JUNO	SP34505-93D-6-WWH		11	3000	
	VAOPTO	VO-DL-6WW20-85E26-110-WHITE		18	3500	
D6w	CREE	L66C-GU24W-RR6-GU24	CR6T-G-825L-27K-1227/RR6-UNI	12	3000	6" DIAMETER, WHITE, RECESSED DOWN LIGHT & WALL WASHER
	SECURITY	PDL6KADJ-LED-07-30-120-PDL6KADJHSGNC		14	3000	
	VAOPTO	VO-DL-6WW13-90K9DA		13	3000	
	JUNO	SP34506-27K-6WWH		11	3000	
	ENERGYWISE	EWRR61130W-L7		10	3000	
E	JUNO	R600L3KNBZ		10	2700	TRACK LIGHT
F	CREE	SCG-CM-BL-GU24-CR6-800L-30K-120V-GU24CTGA	SC6CMBL-GU24/CR6T-825L-30K/CR6T-TRMBKBB-1			PENDANT LIGHT
	SECURITY	LBC6CM-LB6LEDA1030KBL		12	3000	
	ENERGYWISE	EWLBC6BLK			3000	
G	JUNO	SP34378B-9-F1-SSN		10	3000	2" DIAMETER DOWN LIGHT, SATIN NICKEL FINISH
	ZANIBONI	D2LUNA20930A3CNP0BKOP		9	3000	
G1	JUNO	SP34378A-930-F1-SN		10	3000	2" DIAMETER WALL WASHER, SATIN NICKEL FINISH
	ZANIBONI	D2LUN200930A3CNP0BKOD		9	3000	
I	CREE	CL-E-TFA04A-24R-40N	C-TR-FP24-50L-340K-WH	42	4000	1. TO BE USED IN KITCHEN 2. 2x4 RECESSED
	SECURITY	LJT24-40-MLG-FSA12-EU-C388		45	4000	
	LSI	SFP24 LED 50 UE DIM 40		50	4000	
	VAOPTO	VO-PL-2NW4-60		60	4000	
	ENERGYWISE	EWMLFP24EP4841		48	4100	
J	CREE	CL-E-TR14L2404U	C-TR-FP14-37L-40K-WH	42	3500	1. FOR REMODELS ONLY 2. TO BE USED IN RESTROOMS 3. 1x4 RECESSED
	SECURITY	LJT14-35LWG-FSA12-EDU-C388		27	3500	
	LSI	SFP14 LED 40 UE DIM 35 FK14		40	3500	
	VAOPTO	VO-PL-1XW14-50		50	3000	
	ENERGYWISE	EWMLFP14EP3535		35	3500	
PG	CREE	CL-E-TFA03A-22R-40N	C-TR-FP22-31L-40K-WH	32	3500	1. TO BE USED IN PLAYGROUND 2. 2x2 RECESSED
	SECURITY	LJT22-35MLG-FSA12 EU		35	3500	
	LSI	SFP22 LED 30 UE DIM 35 FK22		30	3500	
	VAOPTO	VO-PL-2XW22-36		36	3000	
	ENERGYWISE	EWMLFP22EP3535		36	3500	
EM	CREE	EM22RWH	C-EE-A-EMG-2L-BB-REM-WH	11		EMERGENCY LIGHT
	SECURITY	CU2		1	3000	
	LSI	LTEMWH		(2) 1 LED		
	VAOPTO	VO-EM		2	5000	
	ENERGYWISE	EWCU2		1	3000	
EMX	CREE	EXDMBRWH	C-EE-A-EX-2LDF-RED-BB	11		EXIT / EMERGENCY LIGHT
	SECURITY	CCRC		4		
	LSI	LPRXRUBWBHLD11R		(2) 1 LED		
	VAOPTO	VO-EMX-R1		2	5000	
	ENERGYWISE	EWCCR		4	3000	
T	TOOSHLIGHTS	MASTER FORMAT 26 55 10 Light: Full color, RGB LEDs Power: Power Over Ethernet (POE), Low Voltage DC. Use CAT 5 or CAT 6, shielded cable.				RESTROOM WALL MOUNTED OCCUPANCY INDICATOR LIGHT
	CREE	WS4-50L-57K-10V-FD	WS4C-60L-LFA-50K-8-UL	55	5300	
	SECURITY	LXEM4-50ML-RFA-EU		53	5000	
	LSI	EG34LEDHOCWUE		52	5300	
	VAOPTO	VO-TF-14W		32	5000	
O	CREE	LS4-25L-35K-10V		23	3500	PLAYGROUND PENDANT LIGHT
	CREE	LS8-80L-35K-10V		88	3500	

CONTACT INFORMATION			
CREE ELVIR SULJIC 262-884-3332 esuljic@creelighting.com	HERMITAGE "MASTER CONSOLIDATOR" WYATT CULVER 615-843-3379 wyatt@hig.co	ENERGYWISE JENNIFER WADDICK 877-225-1336 jennifer@energywisemail.com	JUNO / ACUTY BRANDS BRETT D KINZLER o 847-813-8350 m 847-312-1578 brett.kinzler@acuitybrands.com
SECURITY LIGHTING WHITNEY WATSON 630-550-9320 quotations@securitylighting.com	NAUTICAL FURNISHINGS MICHAEL HOGGLUND 954-771-1100 mhogglund@naughtalfurnishings.com	VaOpto LINDA XU 702-517-5789 linda@vaopto.com	ZANIBONI LIGHTING JENNIFER MORRIS 727-213-0410 southeastusa@zanibonilighting.com
LSI BOB LUCAS 800-436-7800 Ext 4052 bob.lucas@lsi-industries.com			

NOTES

- NOT ALL LIGHT FIXTURES TYPES SHOWN ON SCHEDULE MAY BE USED ON THIS PROJECT. REFER TO LIGHTING PLAN FOR PROJECT SPECIFIC TYPES AND QUANTITIES.
- PENDANT FIXTURES "A" MUST BE CENTERED OVER TABLE TOPS. COORDINATE WITH DECOR DRAWINGS.
- EXCEPT FOR DROPPED CEILING OPTION, ALL LIGHT FIXTURES IN DINING ROOM AREA & RESTROOM CORRIDOR ARE TO BE SUPPORTED FROM EXPOSED ROOF TRUSSES.
- CONTRACTOR TO NOTIFY LIGHTING SUPPLIER OF THE FOLLOWING: FIXTURE TYPES "C" AND "D" WILL BE REQUIRED TO BE LENS AT THE LOCATIONS OVER THE SERVICE AREA AND OVER THE SELF-SERVE DRINK AREA. FIXTURE TYPE "I" WILL REQUIRE A LENS OR TUBE GUARD AT THOSE LOCATIONS.

**BURGER KING 20/20 GARDEN GRILL EXTERIOR
EXTERIOR LIGHT FIXTURE SCHEDULE**

9/4/2019 ALL REMODELS & NEW CONSTRUCTION						
TYPE	VENDOR	CATALOG No.	WATTAGE	COLOR TEMP.	REMARKS	
K (NEW CONST.)	CREE				RECESSED SOFFIT LIGHT	
	SECURITY	851/852-60-U-WH	42	5000		
	LSI	XSPS 5 LED SS CW 120 GWT DFL	43	5000		
	VAOPTO					
K (REMODELS)	CREE				1. FOR REMODELS ONLY	
	SECURITY	851/852-60-U-WH	42	5000	2. RECESSED SOFFIT LIGHT	
	LSI	XSPS 5 LED SS CW 120 GWT DFL	43	5000		
	VAOPTO					
L (DOWN ONLY)	CREE	RS-30WLED-DO-SV-120-5300K	30	5300	1. OPTIONAL CLOSED CANOPY FIXTURE PROVIDED BY SIGN SUPPLIER WITH CANOPY	
	SECURITY	RWSC30LED-WD-PS-MT	30	5000		
	LSI	WP35F3X9U57KMSV	12	5700		
	KONTECH	KON-40-WS	40	5000		
	VAOPTO	VO-WS-DW40D	40	5000		
	ENERGYWISE	EWKON-40-WS	40	5000		
	CREE	RS-42WLED-UD-SV-120-5300K	30	5300	1. EXTERIOR WALL FIXTURE	
L (UP/DOWN)	SECURITY	RWSC30LED-UD-PS-MT	30	5000	2. OPEN CANOPY FIXTURE	
	LSI	WP36L13X9U57KMSV	12 UP / 12 DOWN	5700	3. PROVIDED BY SIGN SUPPLIER WITH CANOPY	
	KONTECH	KON-60-WS-DU	60	5000		
	VAOPTO	VO-WS-DW60UD	60	5000		
	ENERGYWISE	EWKON-60-WS-DU	60	5000		
	KONTECH	KON-DVP-182-14-IY	40	5000	1. TO BE USED AT AWNINGS	
	VAOPTO	VO-RP-40DW277-4	40	5000	2. OPTIONAL CLOSED CANOPY FIXTURE PROVIDED BY SIGN SUPPLIER WITH AWNING/CANOPY	
M	CREE	E.WP1X03127	27	4000	1. WALL MOUNTED SECURITY LIGHT	
	SECURITY	WGH-1LU-M	41	5000	2. BRONZE FINISH	
	LSI	SFCMWBLEDPL150UEBRZ	33	5000		
	VAOPTO	VO-WP-DW-N50	50	5000		
	ENERGYWISE	EWALED-WPDS240	40	5000		
N	CREE	LFL-A-(3,4,6,8)-DO-UL-BZ-53K-EA	3' 26 / 4' 35 52 / 8' 70	5300	1. CONTINUOUS ARCHON TOWER LIGHTING	
	SECURITY	HIRAF-HE-LED(96,72,48,36)DO-120-DB	8.5 / FT.	5200	2. DOWNLIGHT ONLY	
					3. TO BE PLACED AT TOP OF ARCHON TOWER	
					4. TO BE BRONZE FINISH	
O	CREE	LFL-A-(3,4)-UO-UL-BZ-53K	3' 18 / 4' 23	5300	1. CONTINUOUS ARCHON TOWER LIGHTING	
	SECURITY	HIRAF-HE-LED(48,36)UO-120-DB	50	5200	2. UPLIGHT ONLY	
					3. TO BE PLACED ABOVE ARCHON TOWER CANOPY	
					4. TO BE BRONZE FINISH	
P	CREE	OSQ-A-DA AA-X-T-57K-UL-COLOR	166	5700	1. FINISH TO BE BLACK, BRONZE OR SILVER	
	SECURITY	VP-L-80NB-180-5K-T4-UNV-RA-COLOR	180	5000		
	LSI	XLCMFTLEDHOCWUE-COLOR	276	5104		
	VAOPTO	VO-SL-NW-A56	120	5000		
	ENERGYWISE	EWEC724M2	209	5000		
ACING STRIP	LEKTRON	HLG-240H-24A	120-140	4000	1. TO BE PLACED BETWEEN DRIVE THRU TOWERS	
					2. TO BE PLACED AT READ ELEVATION	

CONTACT INFORMATION			
CREE EVE FRIEDMAN 847-830-1444 steve.friedman@cree.com	HERMITAGE "MASTER CONSOLIDATOR" WYATT CULVER 615-843-3379 wyatt@hig.co	ENERGYWISE JENNIFER WADDICK 877-225-1336 jennifer@energywisemail.com	KONTECHUSA MIGUEL MARTINEZ 866-236-8701
SECURITY LIGHTING ERIC HILLESLAND 630-636-8493 quotations@securitylighting.com	LEKTRON INC. KEVIN RUBOTTOM (800) 634-4059 OR (918) 622-4978 krubottom@lektroninc.com	VaOpto ERIC DE RAMOS 702-517-5789 eric@vaopto.com	DAVE VAN DER BEEK 727-919-1816 DAVIDV2009@ATT.NET
LSI CURT GOOD 404-655-8440 curt.good@lsi-industries.com			JIM MILES 727-560-7985 JIM@FLORIDAELECTRONIC.NET

 

NOTES

- NOT ALL LIGHT FIXTURES TYPES SHOWN ON SCHEDULE MAY BE USED ON THIS PROJECT. REFER TO LIGHTING PLAN FOR PROJECT SPECIFIC TYPES AND QUANTITIES.
- NOT ALL LIGHT FIXTURES TYPES SHOWN ON SCHEDULE MAY BE USED ON THIS PROJECT. REFER TO LIGHTING PLAN FOR PROJECT SPECIFIC TYPES AND QUANTITIES.

No.	Date	By	Notes
3	5/26/21	DB	PLANNING SUBMITTAL
4	7/07/21	DB	BUILDING SUBMITTAL
5	8/27/21	AS	BUILDING REVISIONS
6	10/29/21	AS	ENGINEERING REVISIONS
7	12/10/21	AS	BUILDING REVISIONS 2

Drawn By: CP
Checked: SB
Scale: AS NOTED
Date: 03.24.21

ALL RIGHTS RESERVED. NO PART OF THESE DRAWINGS OR SPECIFICATIONS MAY BE REPRODUCED OR USED IN CONNECTION WITH ANY WORK OTHER THAN THE SPECIFIC PROJECT FOR WHICH THEY HAVE BEEN PREPARED, WITHOUT PRIOR WRITTEN AUTHORIZATION FROM THE ARCHITECT.

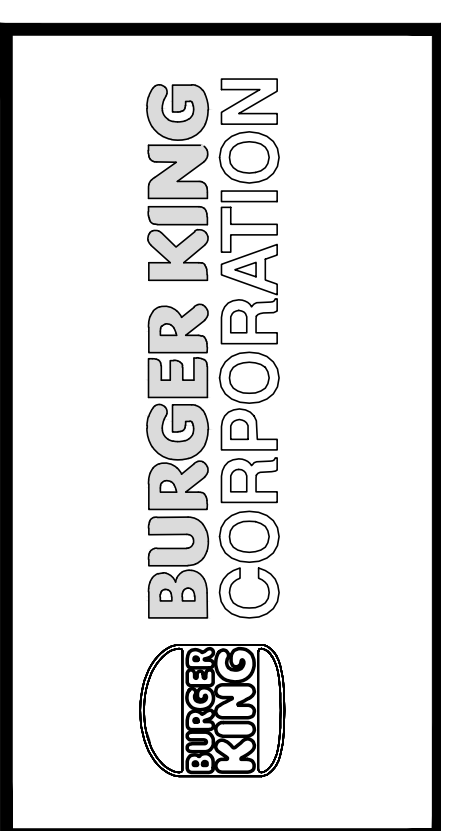

PROJECT BURGER KING #2930 GARDEN GRILL GARDEN CITY, OH 43024	SHEET TITLE LIGHTING SCHEDULE
DO NOT SCALE THIS PRINT. USE FIGURED DIMENSIONS ONLY.	
JOB # TG-21657	
SHEET E-1.1	