


12/21/2021, 12:42 PM, C:\Users\pkmerrill\OneDrive - Philip Kemery, Architect\Projects\Wendy's\123 Starboard\402\2021\Drawings\Reflected Ceiling Plan\A1.2 Reflected Ceiling Plan.rvt

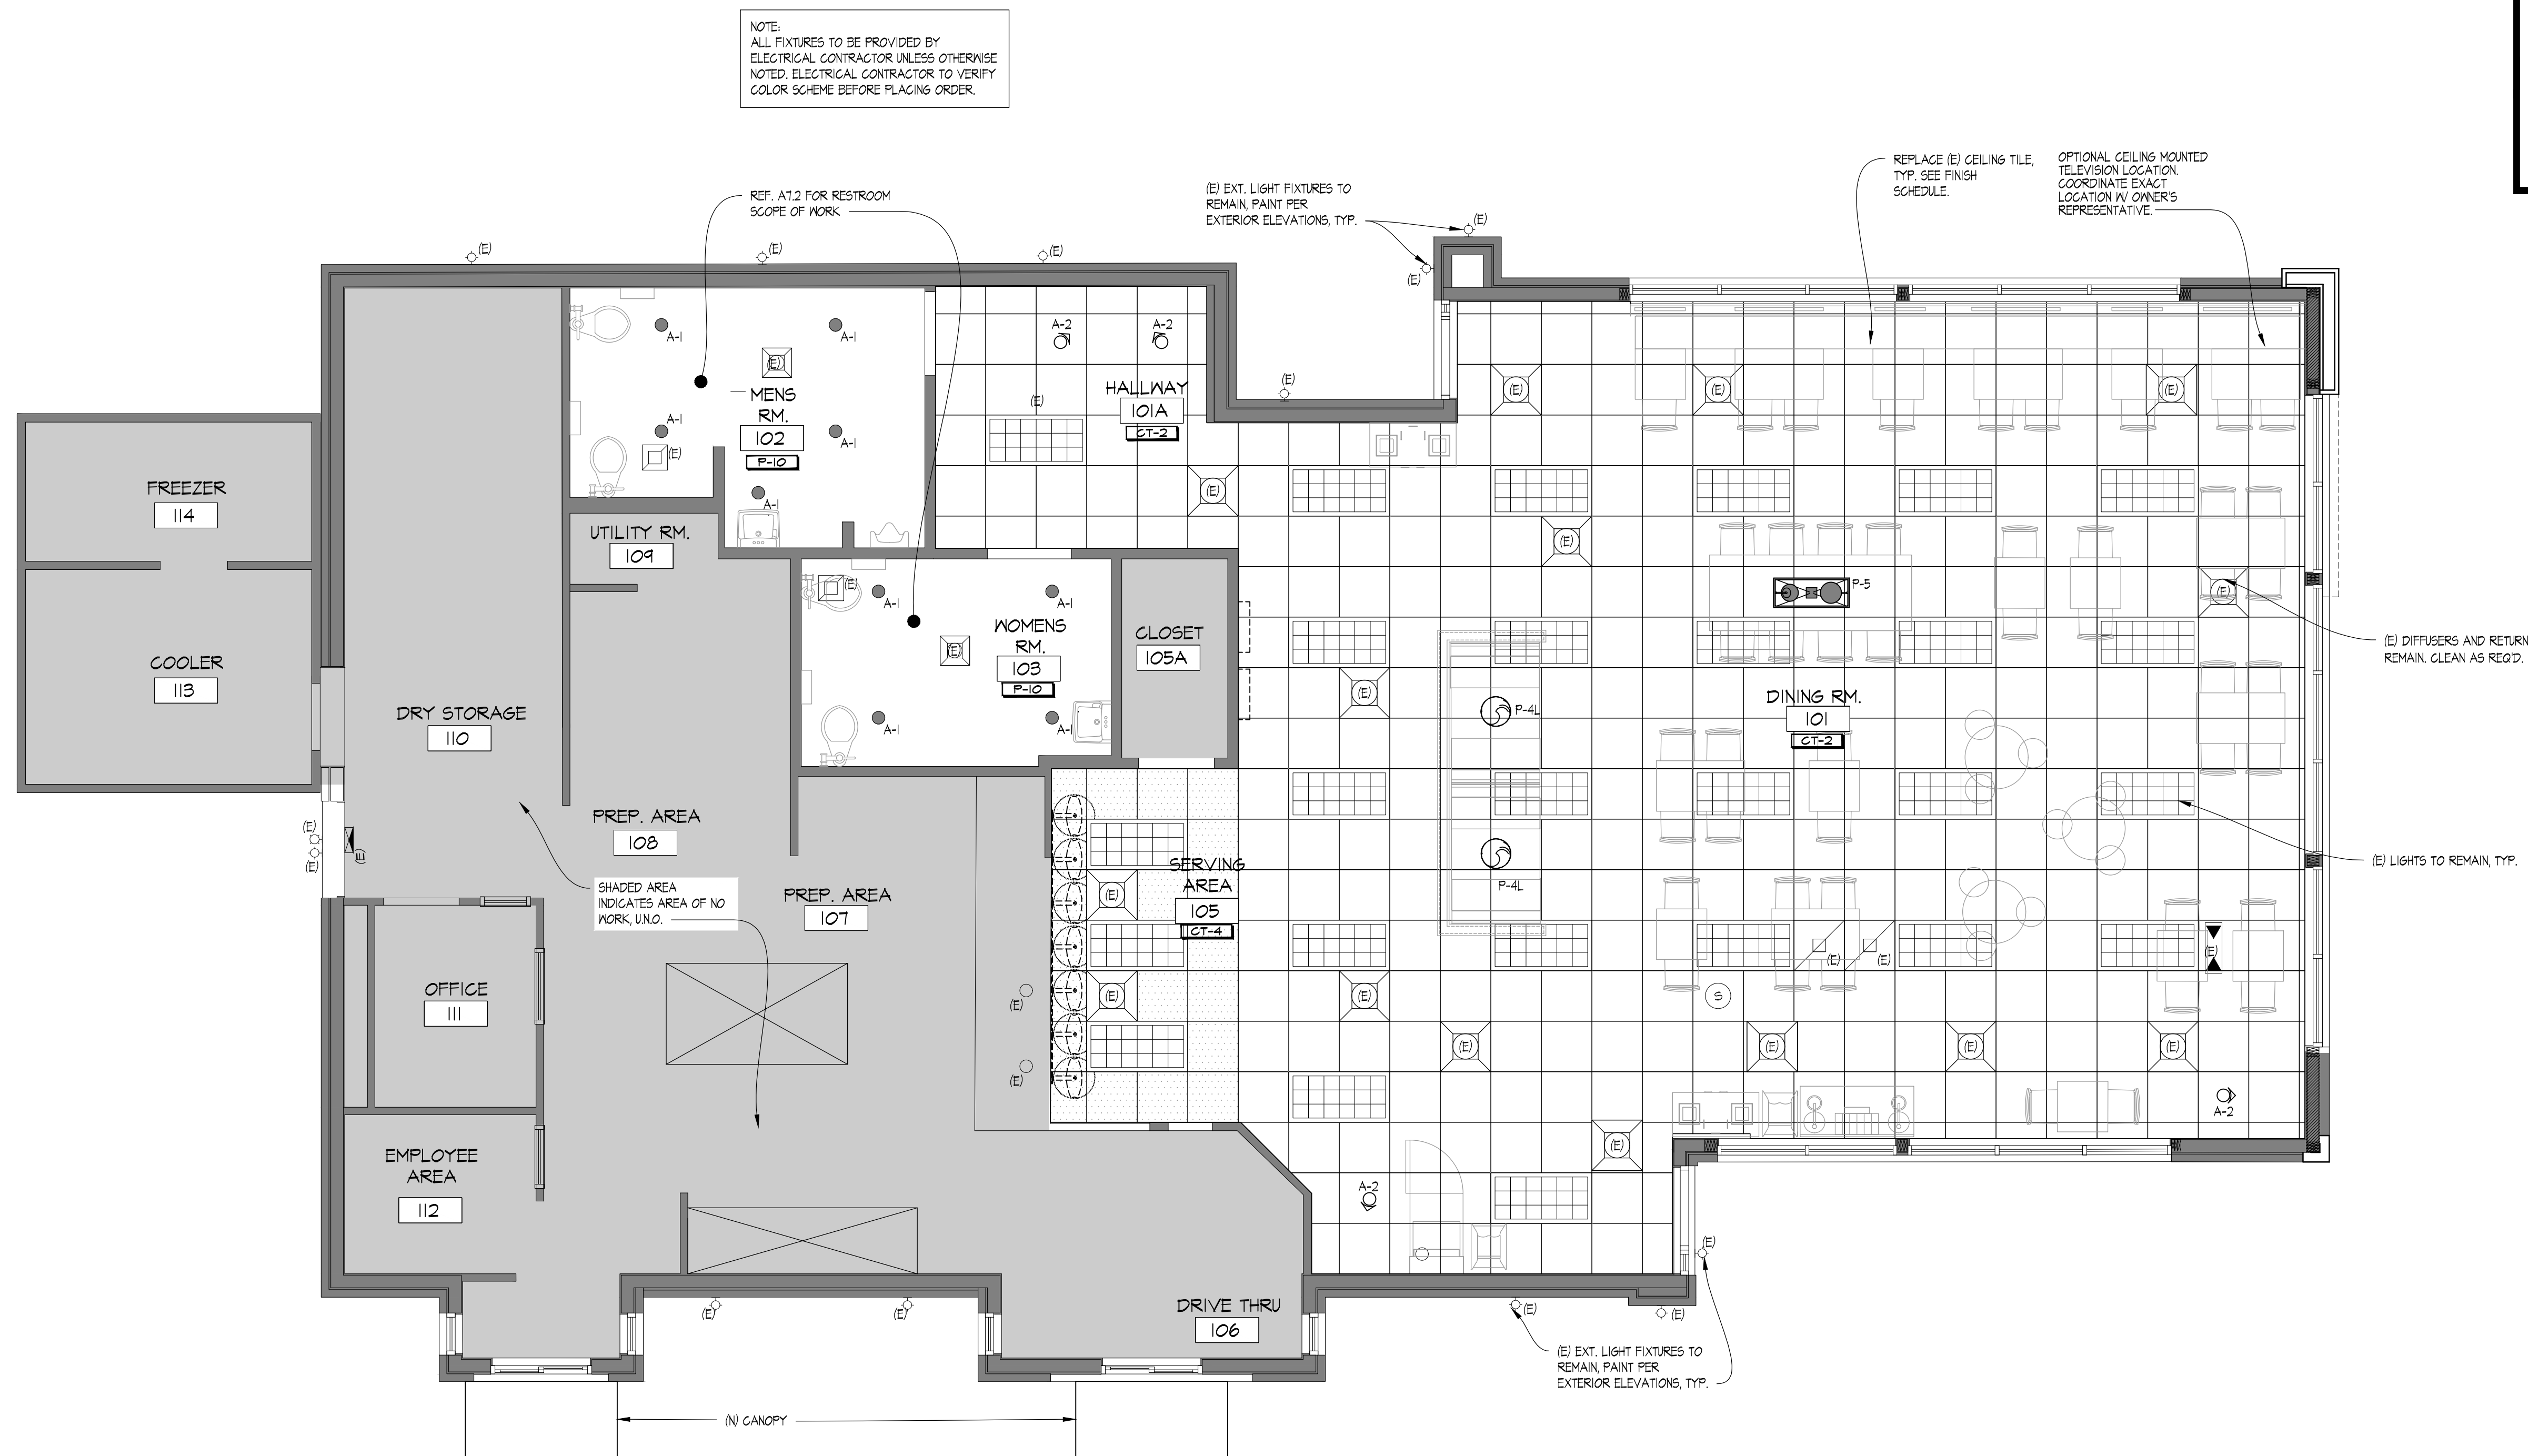

GENERAL NOTES	
1.	HOLD DOWN CLIPS SHALL BE PROVIDED FOR ALL CEILING TILES IN THE VESTIBULES.
2.	SEE INTERIOR FINISH SCHEDULE FOR CEILING TILE.
3.	DO NOT SCREW THE CEILING GRID TO THE STAINLESS STEEL HOODS. USE DOUBLE-FACED TAPE.
4.	REFER TO ELECTRICAL AND/OR HVAC DRAWINGS FOR ADDITIONAL INFORMATION REGARDING ALL FIXTURES, DEVICES AND EQUIPMENT SHOWN ON THIS PLAN.
5.	VERIFY EXISTING MUSIC SYSTEM IN DINING ROOM. COORDINATE REQUIREMENTS WITH KENDY'S REP.
6.	VERIFY EXISTING WIFI SYSTEM. COORDINATE REQUIREMENTS WITH KENDY'S REP.

LEGEND			
	FLUORESCENT LIGHTING FIXTURE		HANGING LIGHT FIXTURE
	NEW CEILING GRID AND ACT (CT-2)		RECESSED OR WALL WASH CAN LIGHT FIXTURE
	(E) CEILING GRID AND NEW ACT (CT-2) (DESIGNATED BY HALF-TONE)		WALL MOUNTED LIGHT FIXTURE
	NEW WASHABLE SUSPENDED ACOUSTICAL CEILING TILE, CT-4		SUSPENDED COMMUNITY FIXTURE
	EXIT LIGHT FIXTURE		PENDANT LIGHT FIXTURE
	CEILING MOUNTED LIGHT TRACK		SUPPLY AIR DIFFUSER
			RETURN AIR DIFFUSER
			CEILING RECESSED EMERGENCY FLOOD LIGHT
			EXTERIOR REMOTE EMERGENCY FLOOD LIGHT
			CEILING SPEAKER

SITE NUMBER:	02011
BUILDING TYPE:	CG3480
ASSET TYPE:	FREESTANDING
CLASSIFICATION:	REFRESH
OWNER:	STARBOARD
BASE VERSION:	2021 SPRING
UPGRADE CLASSIFICATION:	N/A
PROJECT YEAR:	2022
DESIGN TYPE:	(2.0) UM BRIGHT
DRAWING RELEASE:	2021 SPRING

Linear Architecture LLC
Philip Kemery,
 Architect
 4436 Harvest Hill Rd.
 Dallas, TX 75244
 PHONE: 972.929.9226



Wendy's.
 #02011 (STARBOARD #402)
 1197 SOUTH MILITARY TRAIL
 DEERFIELD BEACH, FL 33442

REV.	DATE	DESCRIPTION

ISSUE DATE: 11/02/2021
 PROJECT NUMBER: 21-1000
 DRAWN BY:
 CHECKED BY:



SHEET NAME
 REFLECTED CEILING PLAN

SHEET NUMBER
A1.2

01 REFLECTED CEILING PLAN
 SCALE: 1/4" = 1'-0"