


14/02/2022 1:28 PM C:\Users\pko\OneDrive - Linear Architecture, Inc\Projects\Wendy's\21-125 Starboard 469\849 Rockledge, FL (Refresh)\Construction Documents\03\_A1.2 Reflected Ceiling Plan.dwg, 1890

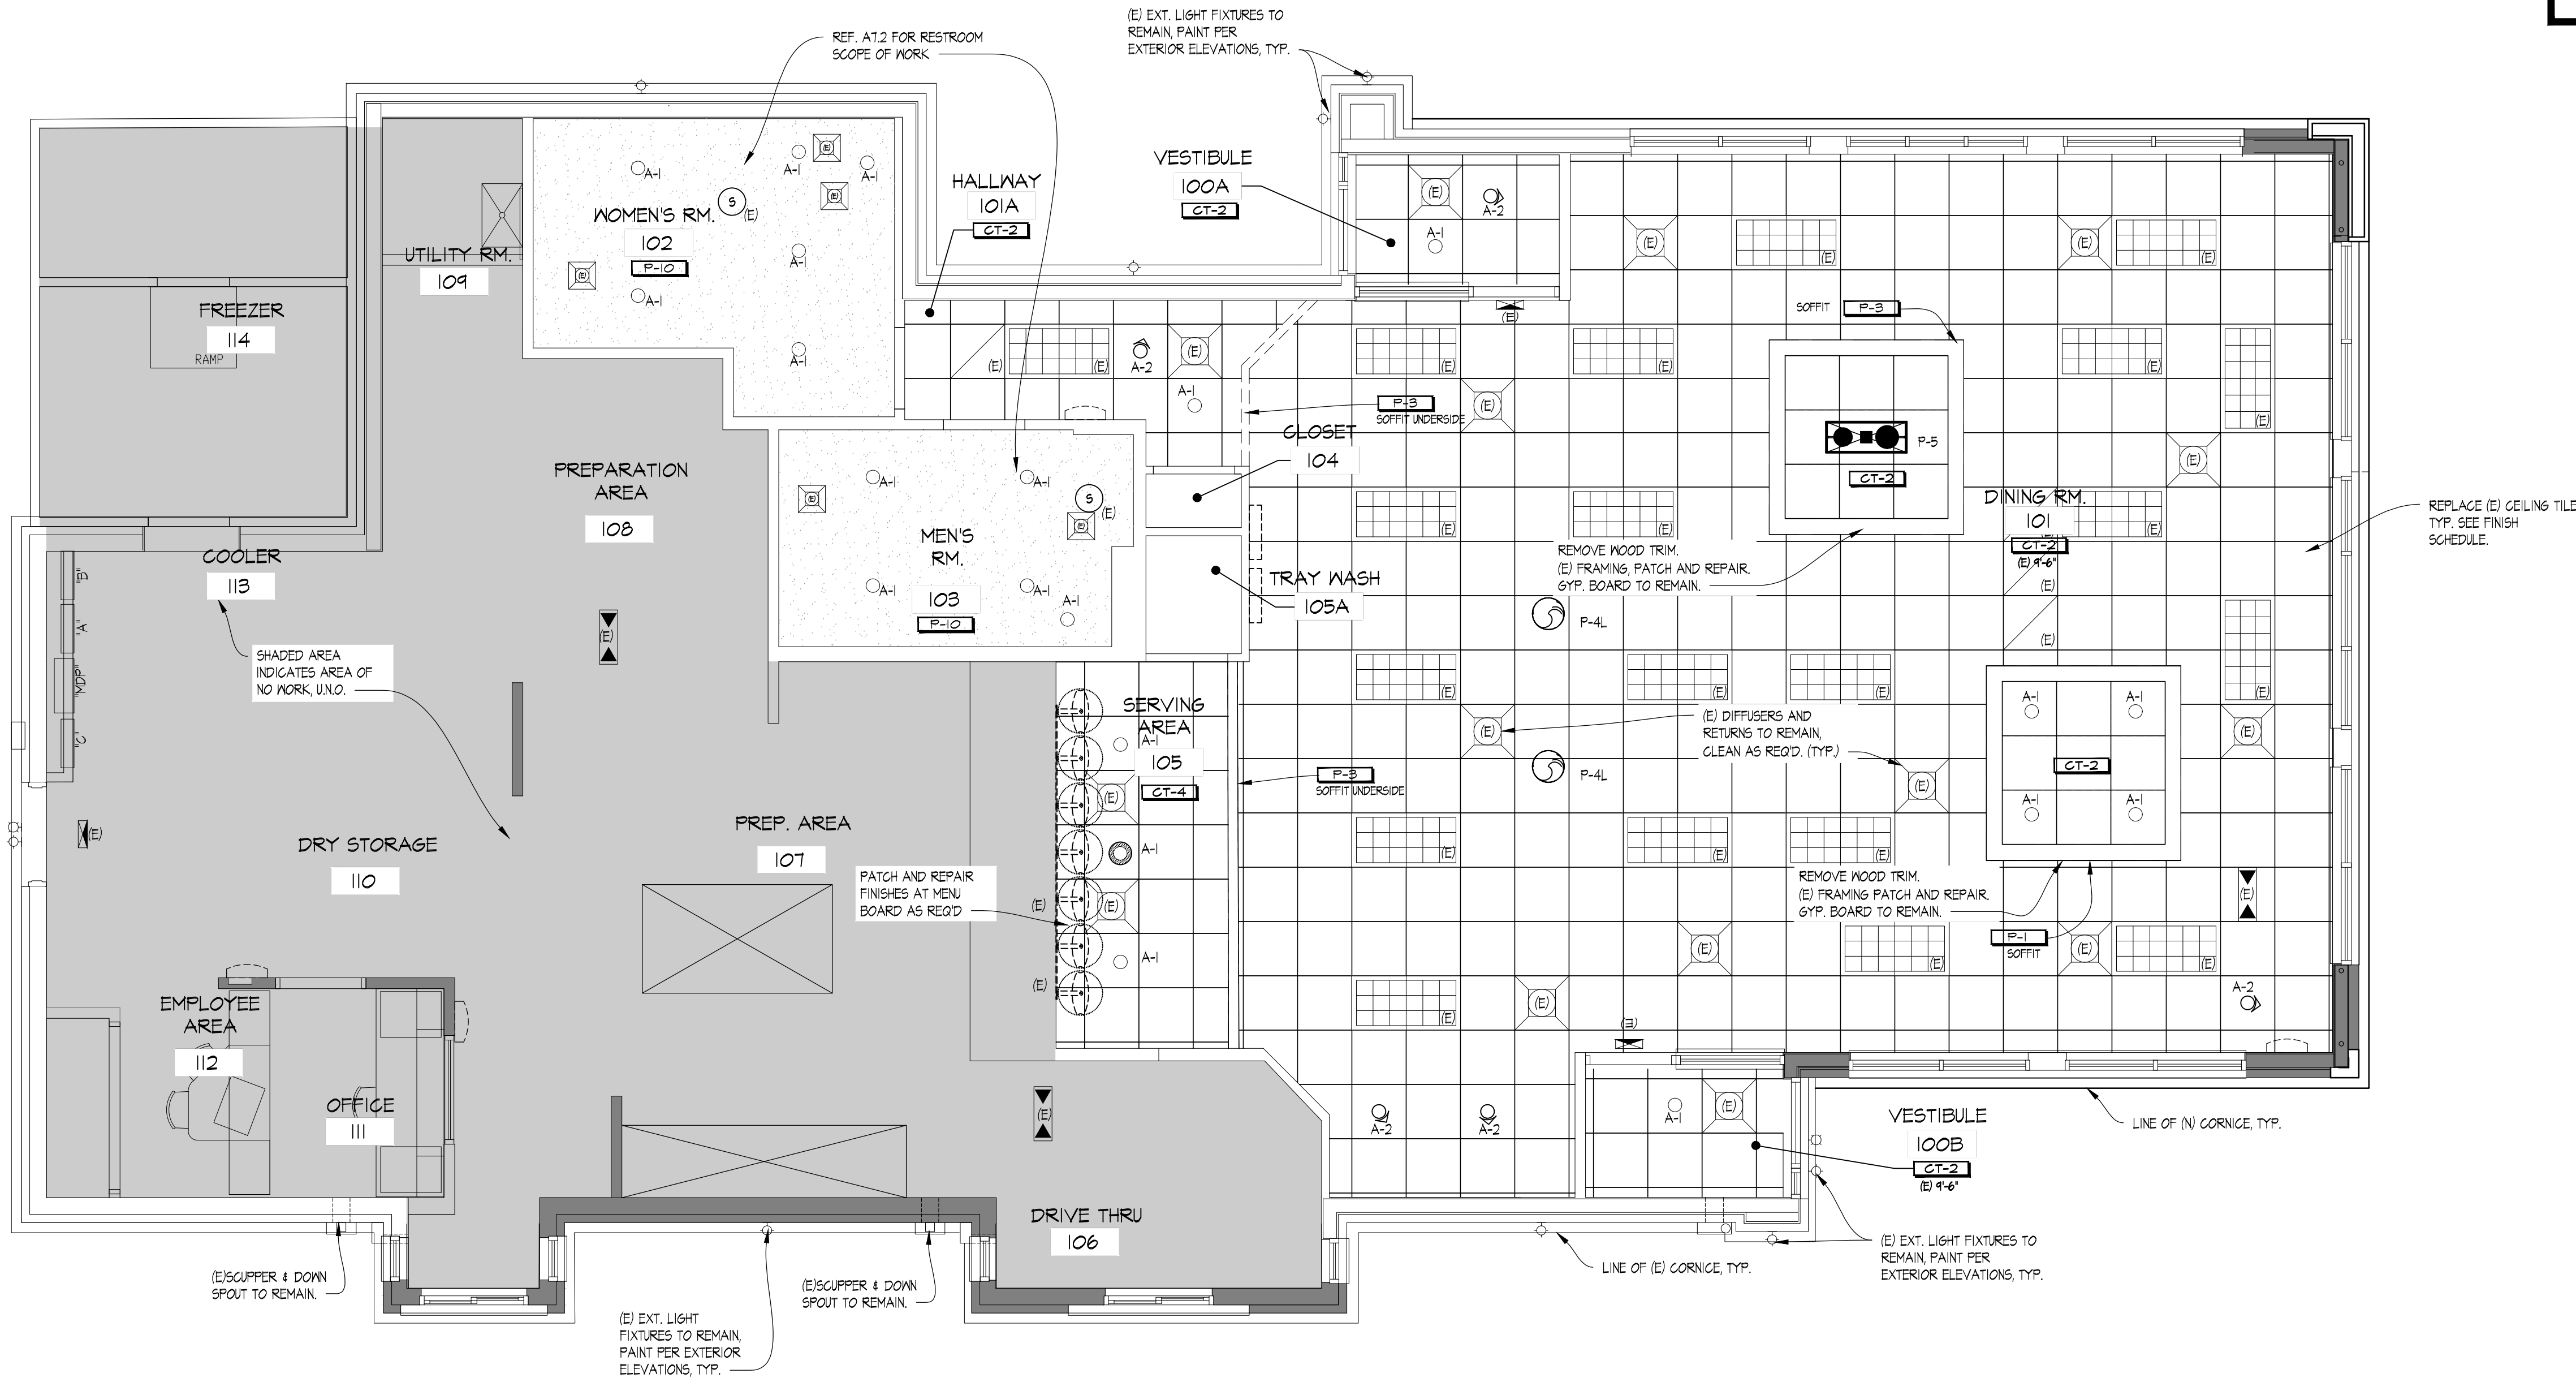

NOTE:  
ALL FIXTURES TO BE PROVIDED BY ELECTRICAL CONTRACTOR UNLESS OTHERWISE NOTED. ELECTRICAL CONTRACTOR TO VERIFY COLOR SCHEME BEFORE PLACING ORDER.

- ### GENERAL NOTES
- HOLD DOWN CLIPS SHALL BE PROVIDED FOR ALL CEILING TILES IN THE VESTIBULES.
  - SEE INTERIOR FINISH SCHEDULE FOR CEILING TILE.
  - DO NOT SCREW THE CEILING GRID TO THE STAINLESS STEEL HOODS. USE DOUBLE-FACED TAPE.
  - REFER TO ELECTRICAL AND/OR HVAC DRAWINGS FOR ADDITIONAL INFORMATION REGARDING ALL FIXTURES, DEVICES AND EQUIPMENT SHOWN ON THIS PLAN.
  - VERIFY EXISTING MUSIC SYSTEM IN DINING ROOM. COORDINATE REQUIREMENTS WITH WENDY'S REP.
  - VERIFY EXISTING WIFI SYSTEM. COORDINATE REQUIREMENTS WITH WENDY'S REP.

### LEGEND

	FLUORESCENT LIGHTING FIXTURE		HANGING LIGHT FIXTURE
	NEW CEILING GRID AND ACT (CT-2)		RECESSED OR WALL WASH CAN LIGHT FIXTURE
	(E) CEILING GRID AND NEW ACT (CT-2) (DESIGNATED BY HALF-TONE)		WALL MOUNTED LIGHT FIXTURE
	NEW WASHABLE SUSPENDED ACOUSTICAL CEILING TILE: CT-4		SUSPENDED COMMUNITY FIXTURE
	EXIT LIGHT FIXTURE		PENDANT LIGHT FIXTURE
	"X"-"X" CEILING MOUNTED LIGHT TRACK		SUPPLY AIR DIFFUSER
			RETURN AIR DIFFUSER
			CEILING RECESSED EMERGENCY FLOOD LIGHT
			EXTERIOR REMOTE EMERGENCY FLOOD LIGHT
			CEILING SPEAKER

SITE NUMBER:	08452
BUILDING TYPE:	E2000
ASSET TYPE:	FREESTANDING
CLASSIFICATION:	REFRESH
OWNER:	STARBOARD
BASE VERSION:	2021 SPRING
UPGRADE CLASSIFICATION:	N/A
PROJECT YEAR:	2022
DESIGN TYPE:	(2.0) UM BRIGHT
DRAWING RELEASE:	2021 SPRING

Linear Architecture LLC  
**Philip Kemery,**  
 Architect  
 4436 Harvest Hill Rd.  
 Dallas, TX 75244  
 PHONE: 972.929.9226



STARBOARD GROUP  
 12540 W. ATLANTIC BLVD.  
 CORAL SPRINGS, FL 33071  
 OFFICE: (954)255-2266

# Wendy's

#08452 (STARBOARD #469)  
 648 BARNES BLVD.  
 ROCKLEDGE, FL 32955

REV.	DATE	DESCRIPTION



SHEET NAME  
**REFLECTED CEILING PLAN**

SHEET NUMBER

# A1.2

**01 REFLECTED CEILING PLAN**  
 SCALE: 1/4" = 1'-0"