


12/29/2021 10:28 AM C:\Users\jgoffin\OneDrive - Philip Kemery, Architect\Projects\Wendy's\129 Starboard\472-08558 Cape Canaveral, FL (Refresh)\Construction Documents\03_A1.2 Reflected Ceiling Plan.dwg, jgoffin

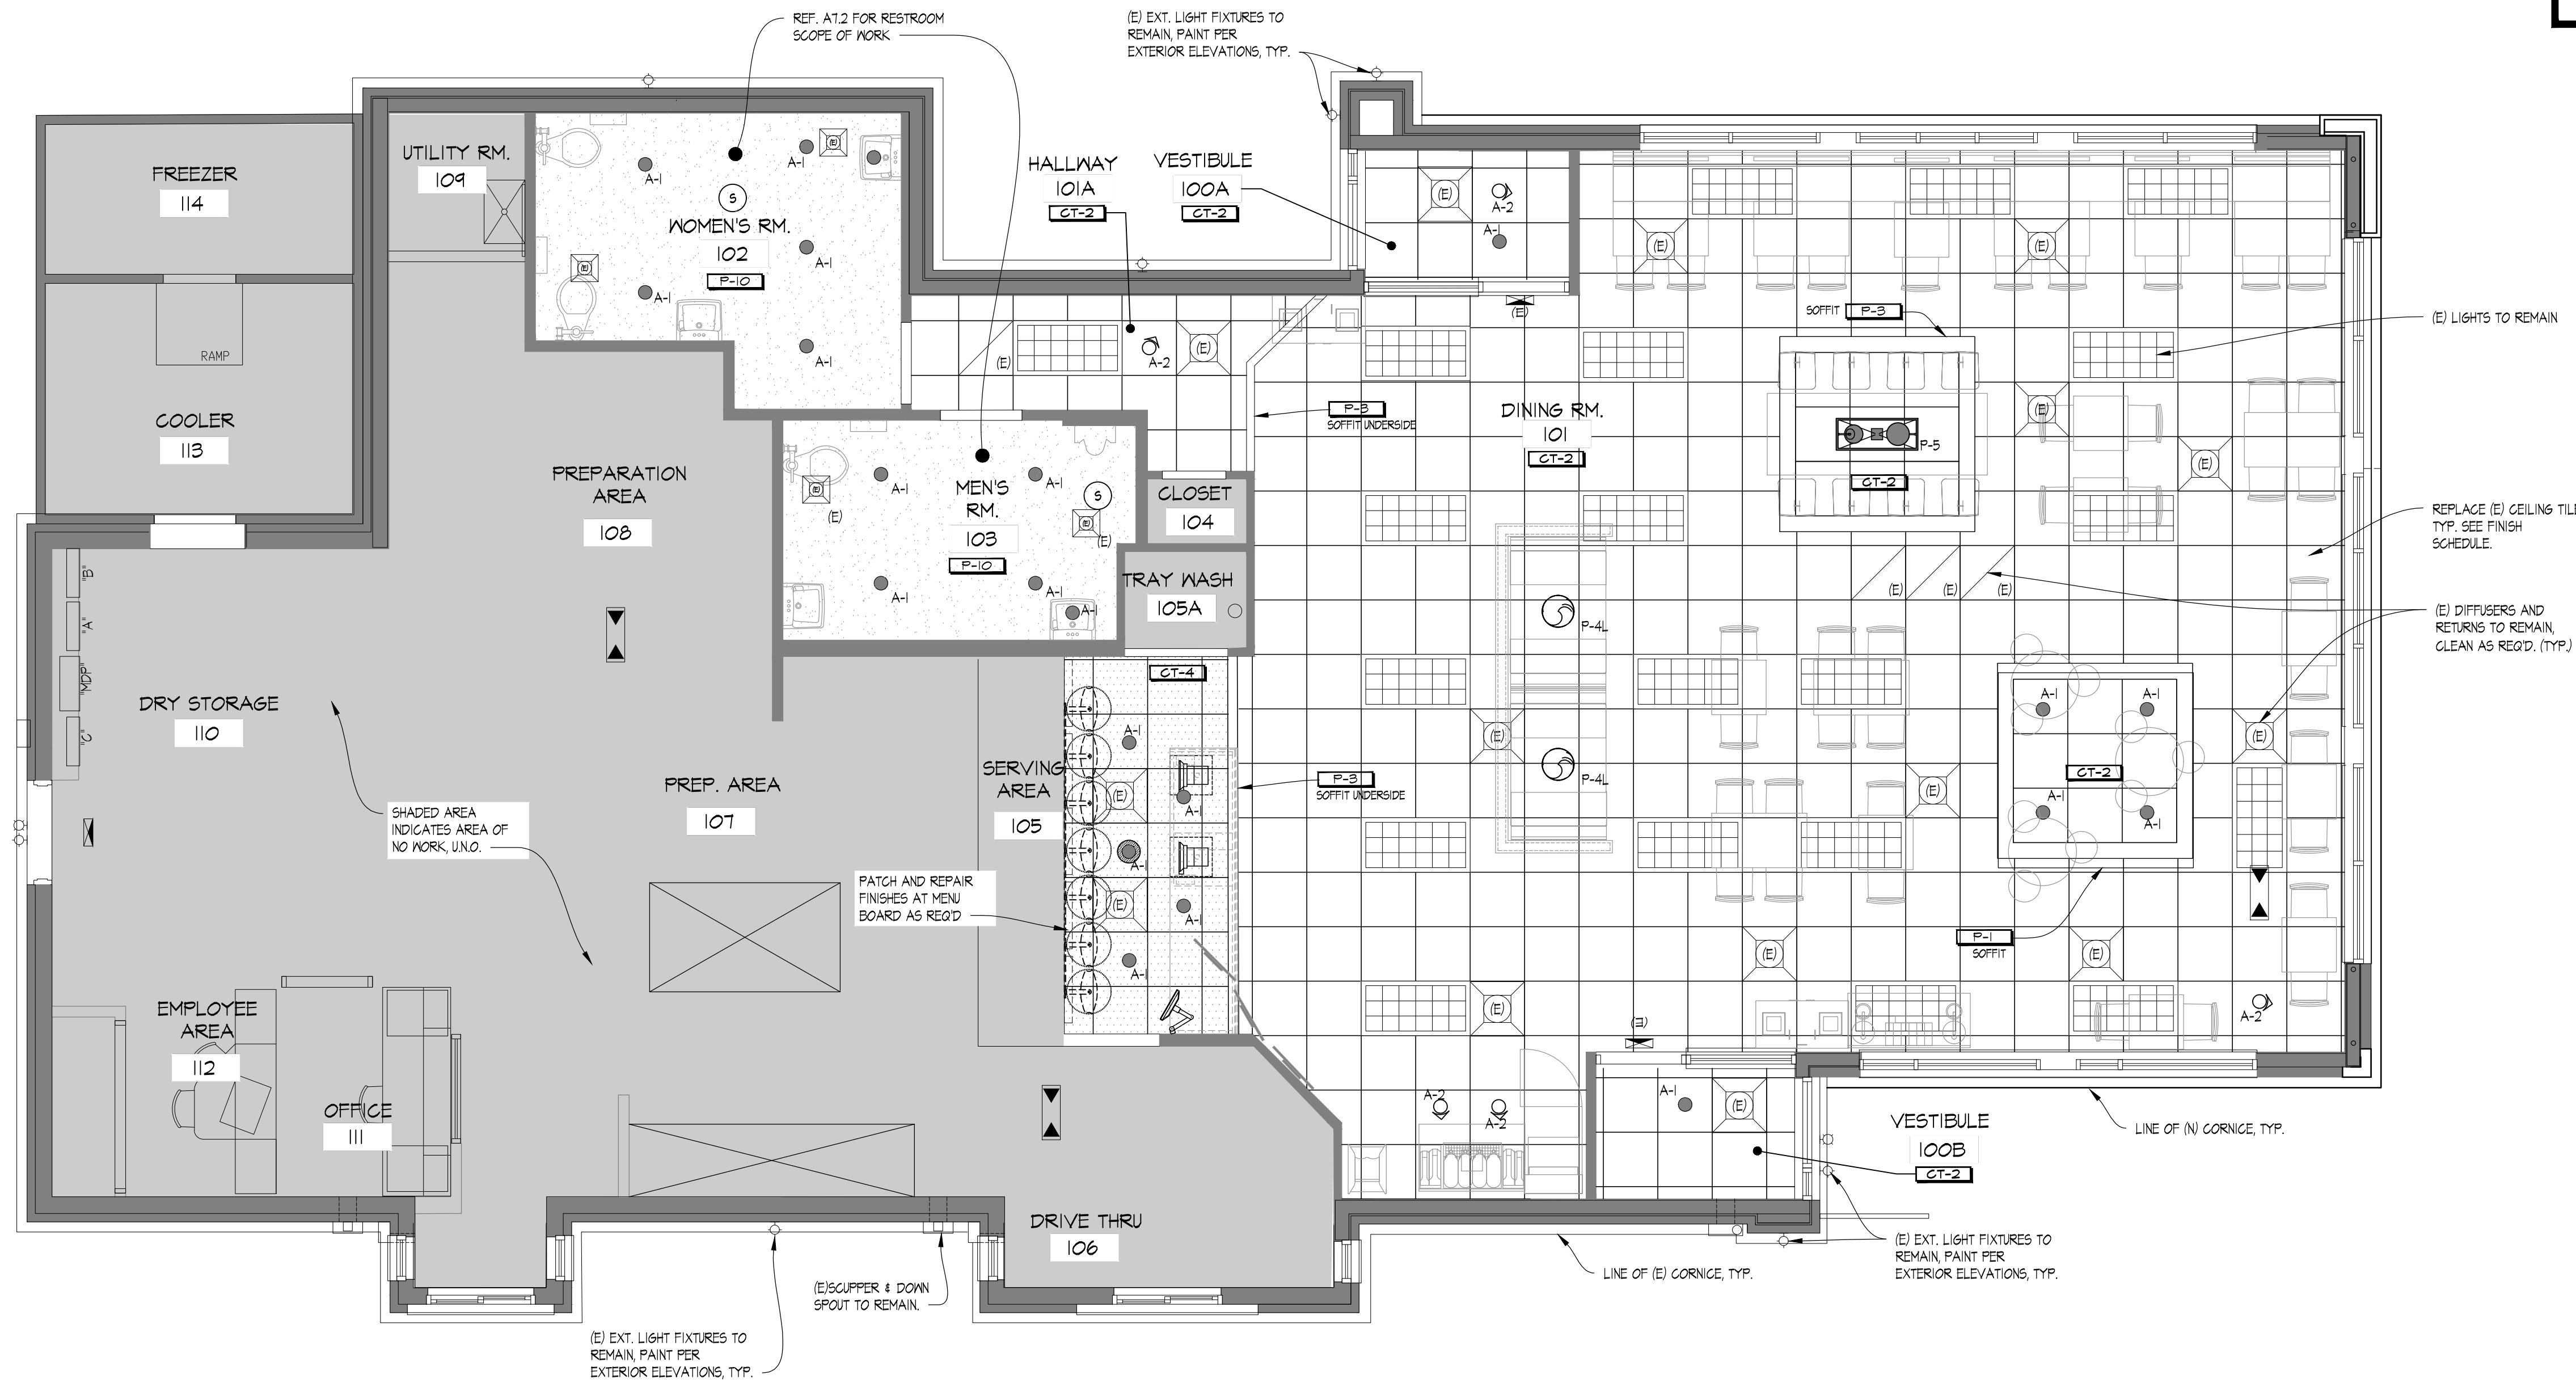

NOTE:
ALL FIXTURES TO BE PROVIDED BY
ELECTRICAL CONTRACTOR UNLESS OTHERWISE
NOTED. ELECTRICAL CONTRACTOR TO VERIFY
COLOR SCHEME BEFORE PLACING ORDER.

GENERAL NOTES

- HOLD DOWN CLIPS SHALL BE PROVIDED FOR ALL CEILING TILES IN THE VESTIBULES.
- SEE INTERIOR FINISH SCHEDULE FOR CEILING TILE.
- DO NOT SCREEN THE CEILING GRID TO THE STAINLESS STEEL HOODS. USE DOUBLE-FACED TAPE.
- REFER TO ELECTRICAL AND/OR HVAC DRAWINGS FOR ADDITIONAL INFORMATION REGARDING ALL FIXTURES, DEVICES AND EQUIPMENT SHOWN ON THIS PLAN.
- VERIFY EXISTING MUSIC SYSTEM IN DINING ROOM. COORDINATE REQUIREMENTS WITH WENDY'S REP.
- VERIFY EXISTING NIFI SYSTEM. COORDINATE REQUIREMENTS WITH WENDY'S REP.

LEGEND

	FLUORESCENT LIGHTING FIXTURE		HANGING LIGHT FIXTURE
	NEW CEILING GRID AND ACT (GT-2)		RECESSED OR WALL WASH CAN LIGHT FIXTURE
	(E) CEILING GRID AND NEW ACT (GT-2) (DESIGNATED BY HALF-TONE)		WALL MOUNTED LIGHT FIXTURE
	NEW WASHABLE SUSPENDED ACOUSTICAL CEILING TILE: GT-4		SUSPENDED COMMUNITY FIXTURE
	EXIT LIGHT FIXTURE		PENDANT LIGHT FIXTURE
	X'-X" CEILING MOUNTED LIGHT TRACK		SUPPLY AIR DIFFUSER
			RETURN AIR DIFFUSER
			CEILING RECESSED EMERGENCY FLOOD LIGHT
			EXTERIOR REMOTE EMERGENCY FLOOD LIGHT
			CEILING SPEAKER

SITE NUMBER:	08558
BUILDING TYPE:	E2000
ASSET TYPE:	FREESTANDING
CLASSIFICATION:	REFRESH
OWNER:	STARBOARD
BASE VERSION:	2021 SPRING
UPGRADE CLASSIFICATION:	N/A
PROJECT YEAR:	2022
DESIGN TYPE:	(2.0) UM BRIGHT
DRAWING RELEASE:	2021 SPRING

Linear Architecture LLC
Philip Kemery,
Architect
4436 Harvest Hill Rd.
Dallas, TX 75244
PHONE: 972.929.9226




STARBOARD GROUP
12540 W. ATLANTIC BLVD.
CORAL SPRINGS, FL 33071
OFFICE: (954)255-2266

Wendy's.
#08558 (STARBOARD #472)
8440 ASTRONAUT BLVD.
CAPE CANAVERAL, FL

REV.	DATE	DESCRIPTION

ISSUE DATE: 12/28/2021
PROJECT NUMBER: 21-124
DRAWN BY: xxx
CHECKED BY: xxx

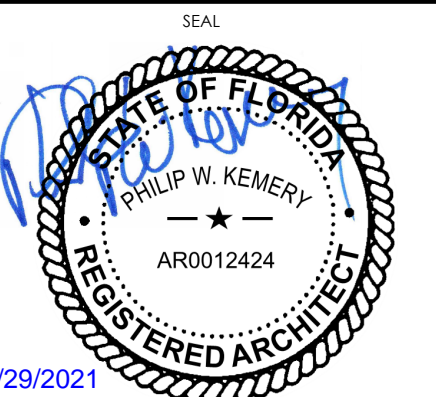

SHEET NAME
REFLECTED CEILING PLAN

SHEET NUMBER

A1.2

01 REFLECTED CEILING PLAN
SCALE: 1/4" = 1'-0"