

12/29/2021, 11:39 AM, C:\Users\pkmiller\OneDrive - Philip W. Kennedy, Architect\Projects\Starboard\122 Starboard\511705 Tampa, FL - Wendy's (Refresh) Construction Documents\09_A1.2 REFLECTED CEILING PLAN.dwg, ipmifm

GENERAL NOTES

- HOLD DOWN CLIPS SHALL BE PROVIDED FOR ALL CEILING TILES IN THE VESTIBULES.
- SEE INTERIOR FINISH SCHEDULE FOR CEILING TILE.
- DO NOT SCREW THE CEILING GRID TO THE STAINLESS STEEL HOODS. USE DOUBLE-FACED TAPE.
- REFER TO ELECTRICAL AND/OR HVAC DRAWINGS FOR ADDITIONAL INFORMATION REGARDING ALL FIXTURES, DEVICES AND EQUIPMENT SHOWN ON THIS PLAN.
- VERIFY EXISTING MUSIC SYSTEM IN DINING ROOM. COORDINATE REQUIREMENTS WITH WENDY'S REP.
- VERIFY EXISTING WIFI SYSTEM. COORDINATE REQUIREMENTS WITH WENDY'S REP.

SITE NUMBER:	07705
BUILDING TYPE:	CG3480
ASSET TYPE:	FREESTANDING
CLASSIFICATION:	REFRESH
OWNER:	STARBOARD
BASE VERSION:	2021 SPRING
UPGRADE CLASSIFICATION:	N/A
PROJECT YEAR:	2022
DESIGN TYPE:	(2.0) UM BRIGHT
DRAWING RELEASE:	2021 SPRING

Linear Architecture LLC
 Philip Kemery,
 Architect
 4436 Harvest Hill Rd.
 Dallas, TX 75244
 PHONE: 972.929.9226




STARBOARD GROUP
 12540 W. ATLANTIC BLVD.
 CORAL SPRINGS, FL 33071
 OFFICE: (954)255-2266

LEGEND

	FLUORESCENT LIGHTING FIXTURE		HANGING LIGHT FIXTURE
	NEW CEILING GRID AND ACT (CT-2)		RECESSED OR WALL WASH CAN LIGHT FIXTURE
	(E) CEILING GRID AND NEW ACT (CT-2) (DESIGNATED BY HALF-TONE)		WALL MOUNTED LIGHT FIXTURE
	NEW WASHABLE SUSPENDED ACOUSTICAL CEILING TILE, CT-4		SUSPENDED COMMUNITY FIXTURE
	EXIT LIGHT FIXTURE		PENDANT LIGHT FIXTURE
	X-X' CEILING MOUNTED LIGHT TRACK		SUPPLY AIR DIFFUSER
			RETURN AIR DIFFUSER
			CEILING RECESSED EMERGENCY FLOOD LIGHT
			EXTERIOR REMOTE EMERGENCY FLOOD LIGHT
			CEILING SPEAKER

NOTE:
 ALL FIXTURES TO BE PROVIDED BY ELECTRICAL CONTRACTOR UNLESS OTHERWISE NOTED. ELECTRICAL CONTRACTOR TO VERIFY COLOR SCHEME BEFORE PLACING ORDER.

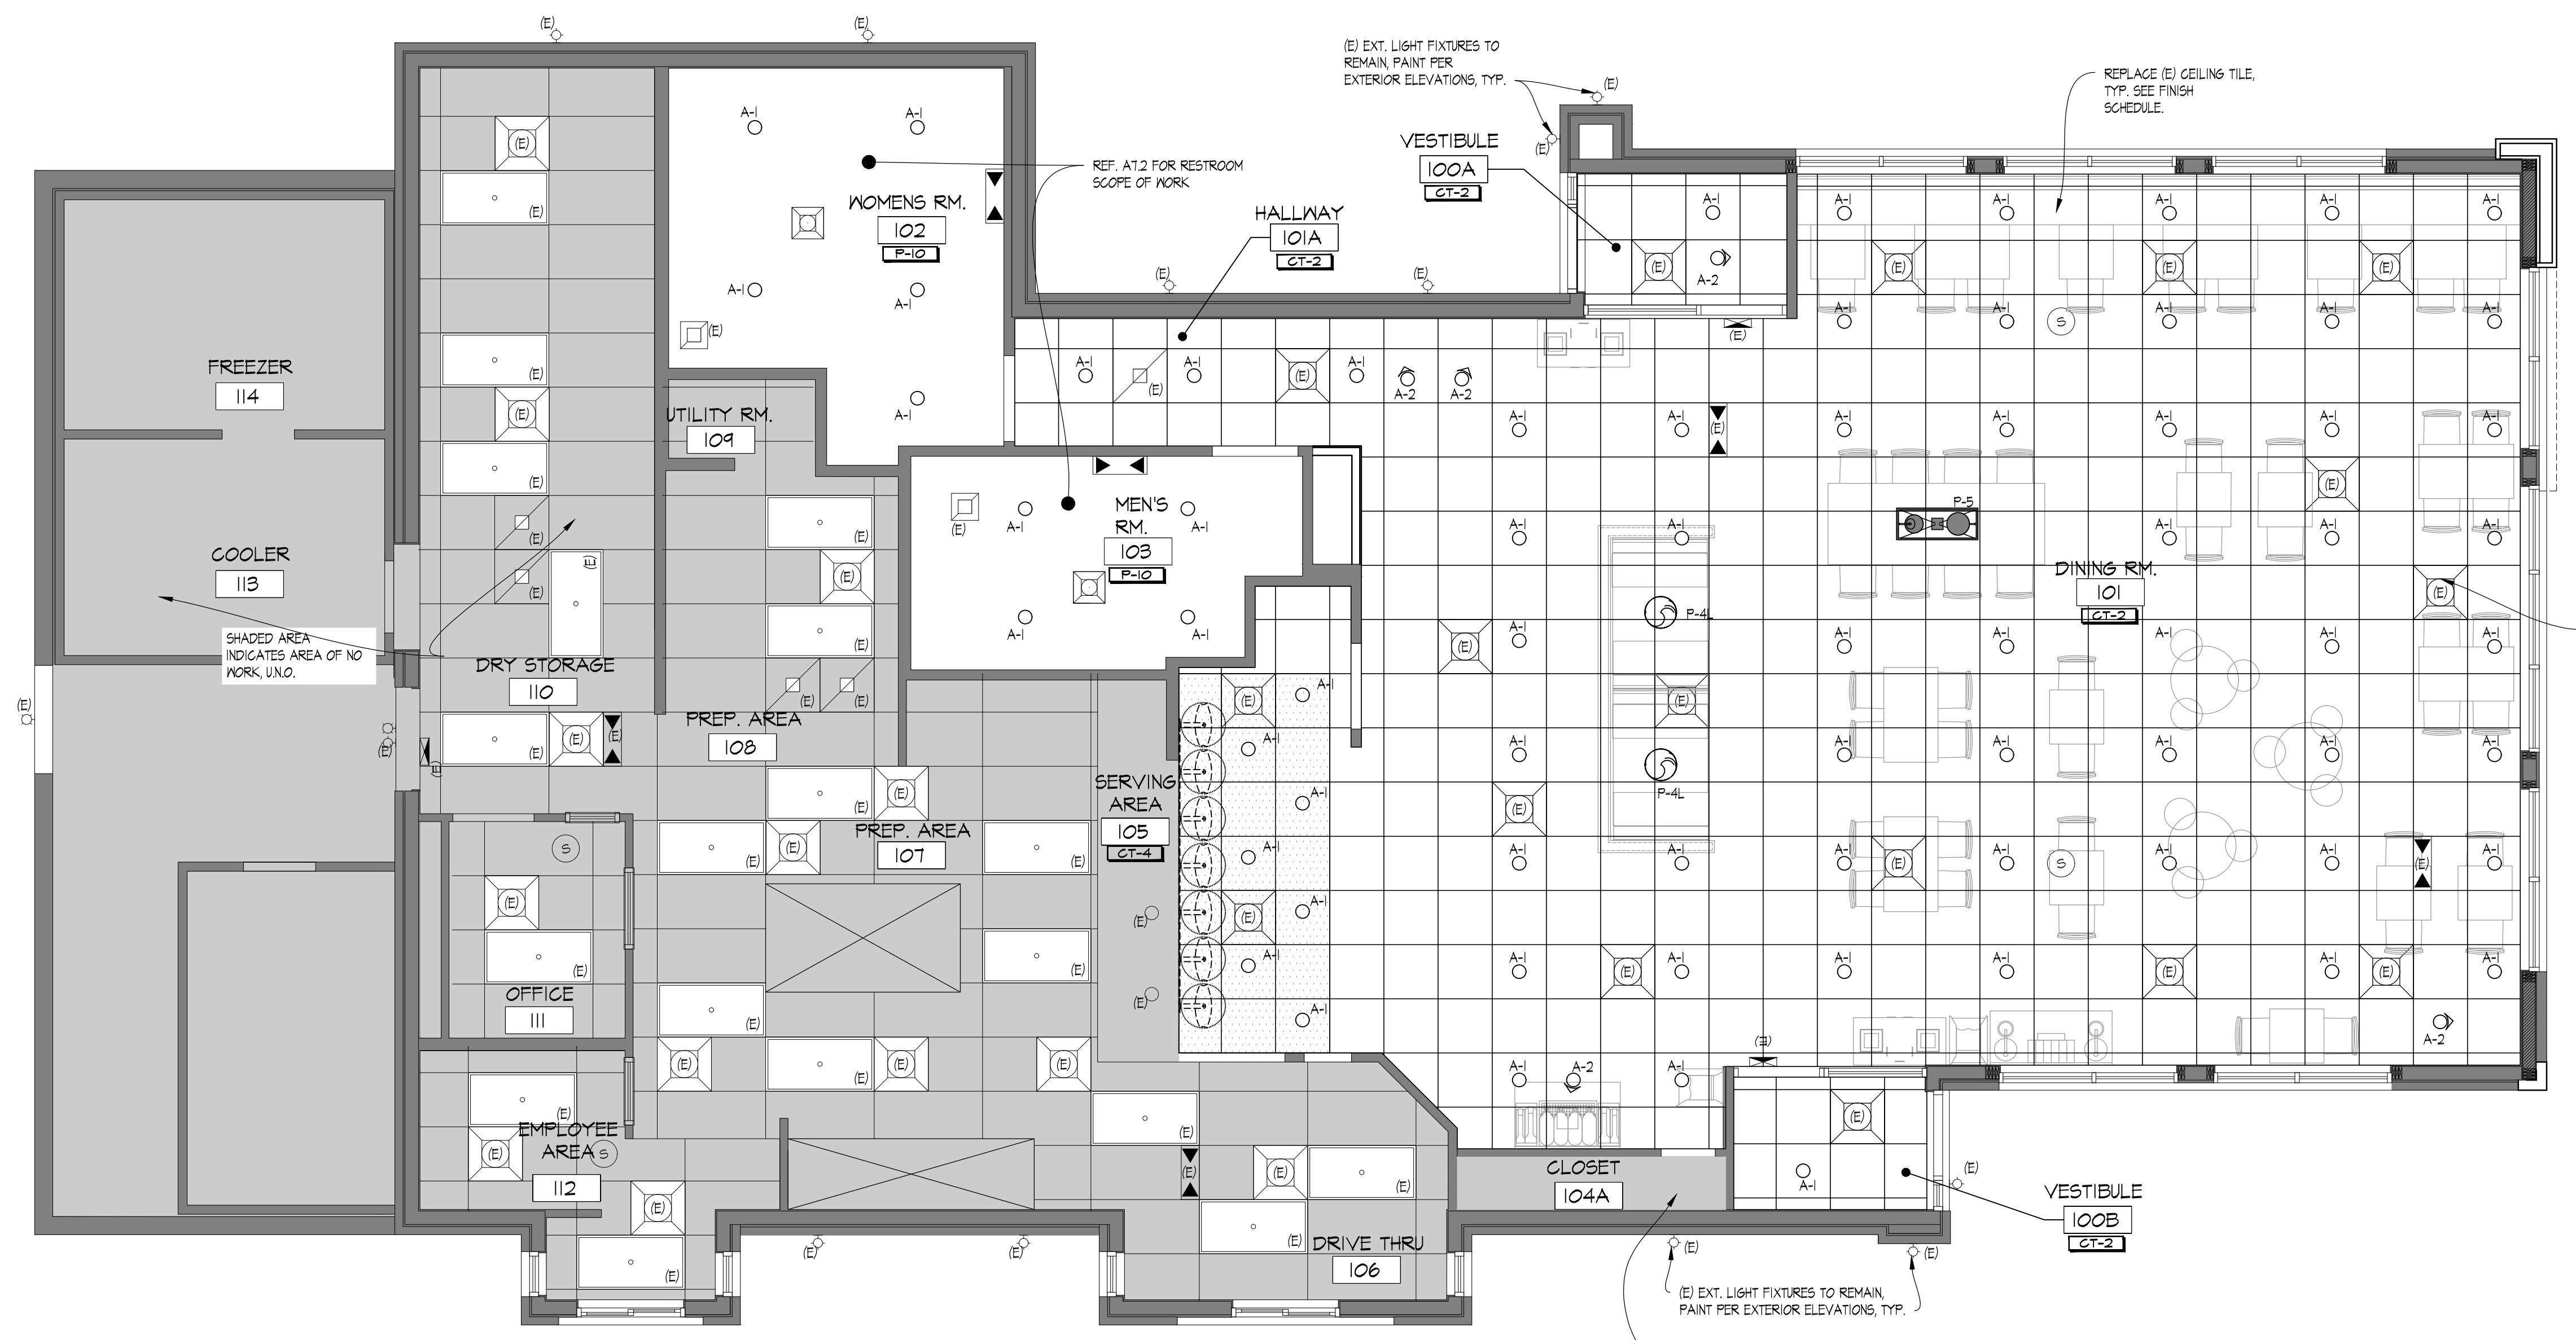

01 REFLECTED CEILING PLAN
 SCALE: 1/4" = 1'-0"

Wendy's.

#07705 (STARBOARD #511)
 1615 WEST KENNEDY BLVD.
 TAMPA, FL 33606

REV.	DATE	DESCRIPTION



SHEET NAME
 REFLECTED CEILING PLAN

SHEET NUMBER
A1.2