
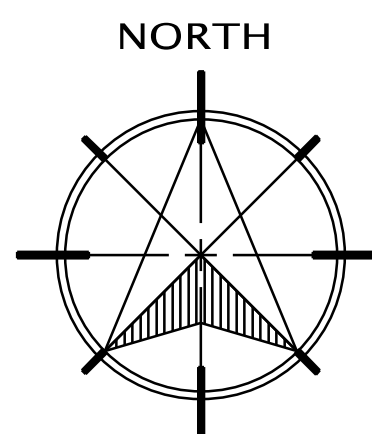


THE IDEAS AND DESIGN CONCEPTS EXPRESSED HEREIN AND THE GRAPHICALLY DISPLAYED ARRANGEMENT OF THEIR COMPONENTS REPRESENTED BY THIS DRAWING HAVE BEEN DEVELOPED FOR THE EXCLUSIVE USE OF THE SPECIFIED PROJECT AND ARE THE SOLE PROPERTY OF JMP Design + Build, Inc. INCORPORATED. A CONVEYANCE OR DISCLOSURE OF THE IDEAS DESIGN CONCEPTS OR USE OF ANY GRAPHICALLY DISPLAYED ARRANGEMENTS OF THE COMPONENTS SHALL BE AT THE DISCRETION AND ONLY THROUGH THE EXPRESSED WRITTEN CONSENT OF JMP Design + Build, Inc. ALL MATERIALS HEREIN ARE PROPRIETARY AND COPYRIGHTED ARCHITECTURAL SEAL

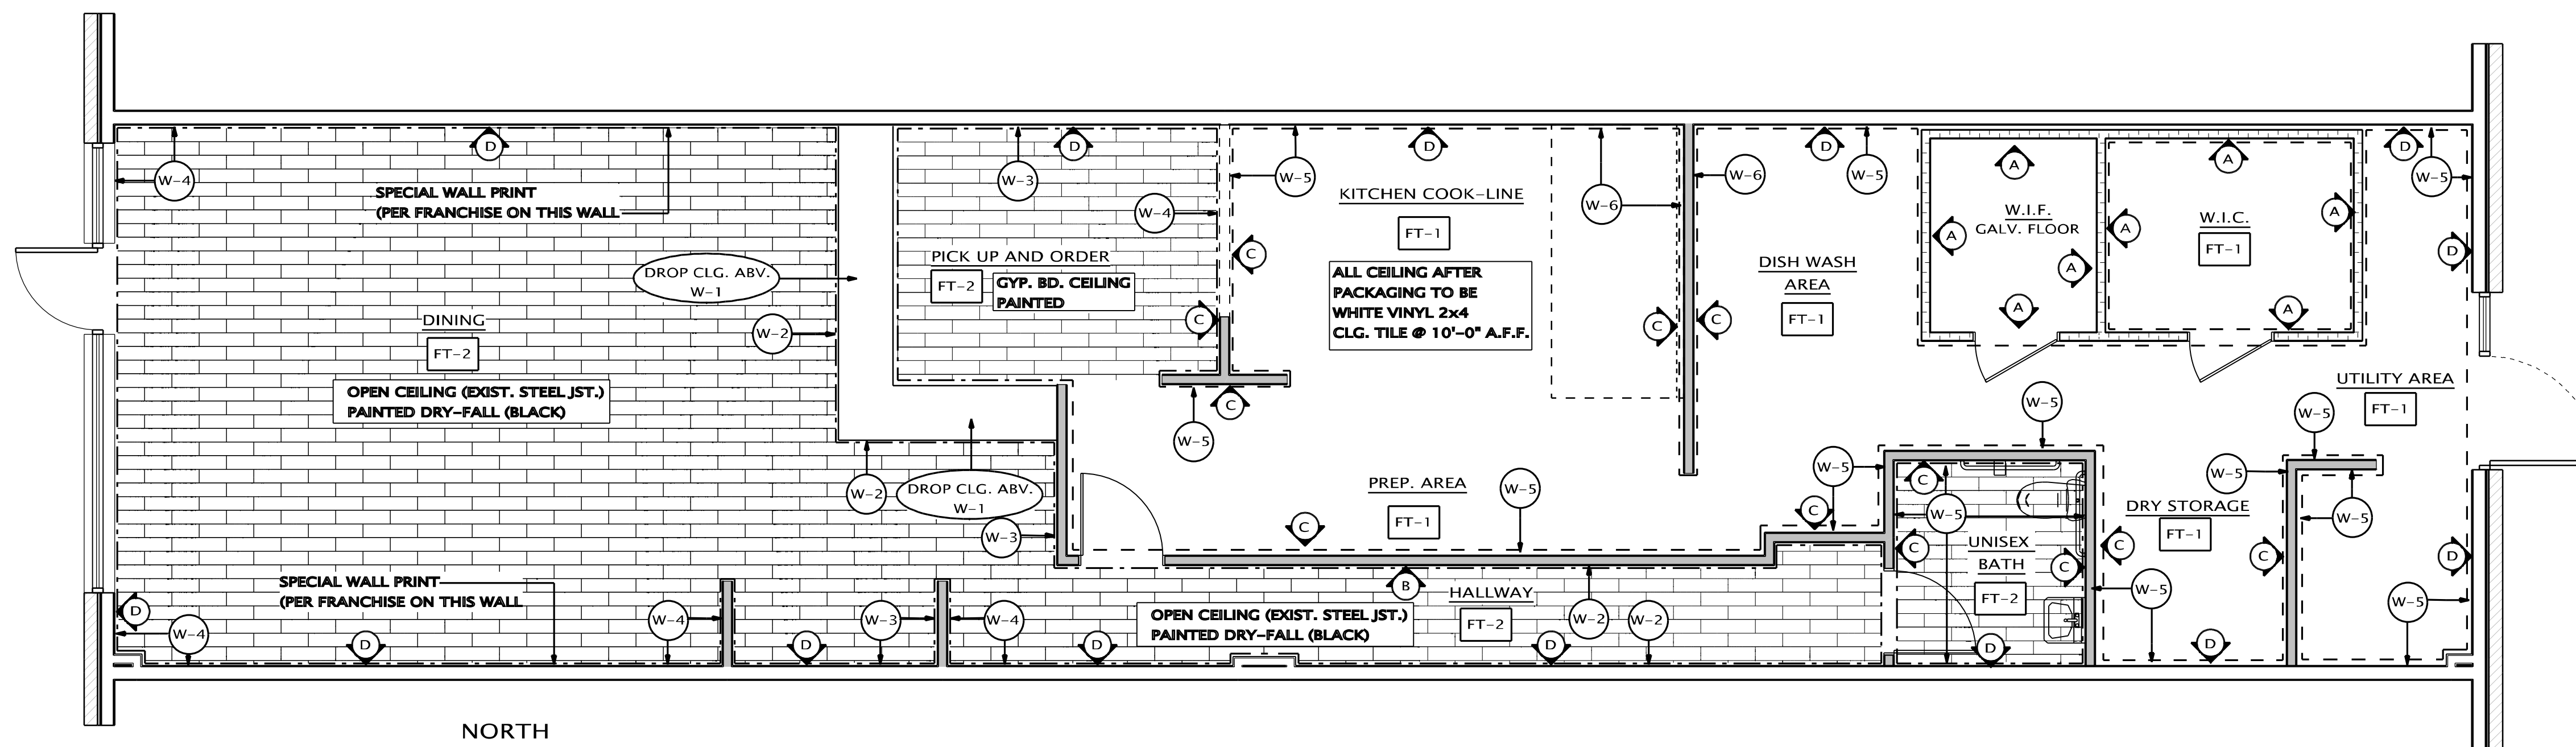

FINISHES PLAN

SCALE: 3/16" = 1'-0"

COVE BASE LEGEND	
---	6" QUARRY COVE BASE
---	4" CERAMIC COVE BASE

DECORATIVE MATERIALS	
L806.1 DECORATIVE MATERIALS CURTAINS, DRAPERIES, HANGINGS, AND ALL OTHER DECORATIVE MATERIALS SUSPENDED FROM WALLS OR CEILINGS SHALL MEET THE FLAME SPREAD PROPAGATION PERFORMANCE CRITERIA OF NFPA 701 IN ACCORDANCE WITH SECT. 806.2 OR BE NON-COMBUSTABLE.	

WALL TAG	
(A)	INSULATED GALVANIZED PANEL
(B)	1/2" G.W.B. FROM FLOOR TO CEILING
(C)	1/2" DUROCK SHEATHING FROM FLOOR TO 48" A.F.F. W/ 1/2" GYP. BD. FROM 48" A.F.F. TO CEILING
(D)	EXISTING DRYWALL TO REMAIN.

WALL FINISH SCHEDULE			
(W-1)	EPOXY BASE A-100 CARBON GREY SHERWIN WILLIAMS W/ PLANK WOOD STAINED OVER.	(W-1)	
(W-2)	EPOXY BASE A-100 CARBON GREY W/ VINYL WRAP (PER FRANCHISE COMPANY)	(W-2)	
(W-3)	(WHITE) SUBWAY TILE FROM FLOOR TO 9'-0" A.F.F. LAID HORIZONTALLY.	(W-3)	
(W-4)	EPOXY BASE A-100 CARBON GREY SHERWIN WILLIAMS W/ WING SNOB LOGO	(W-4)	
(W-5)	EPOXY BASE A-100 WHITE SHERWIN WILLIAMS	(W-5)	
(W-6)	STAINLESS STEEL WALL PANEL	(W-6)	

NOTES	
1. ALL OPENINGS ARE TO BE BACKED WITH 2x WOOD FIRE RETARDENT FRAMING.	
2. ROUGH FRAMER IS RESPONSIBLE FOR ALL BACKING ON ALL PLUMBING FIXTURES, BACKING, WALL SHELVES, AND CORNER GUARDS.	
3. FOR ALL MEANS OF EGRESS PROVIDE SLIP RESISTANT SURFACE AS PER SECT. 1003.4 (MBC 2012)	

FLOOR FINISHES SCHEDULE	
MARK	DESCRIPTION
(FT-1)	8" x 8" QUARRY TILE (AMERICAN CLEAN - QUARRY NATURALS) SHADOW GRAY (ABRASIVE GRAIN). WITH DARK GROUT.
(FT-2)	6" x 24" WOOD GRAIN CERAMIC TILE

NOTES	
1. ALL CORNERS IN KITCHEN TO RECEIVE S.S. WALL GUARDS.	
2. ALL OPENINGS ARE TO BE BACKED WITH 2x WOOD FIRE RETARDENT FRAMING.	
3. ROUGH FRAMER IS RESPONSIBLE FOR ALL BACKING ON ALL PLUMBING FIXTURES, BACKING, WALL SHELVES, AND CORNER GUARDS.	
4. FOR ALL MEANS OF EGRESS PROVIDE SLIP RESISTANT SURFACE AS PER SECT. 1003.4 (MBC 2006)	

INTERIOR WALL & CEILING FINISH REQUIREMENTS BY OCCUPANCY			
SPRINKLE			
GROUP	EXIT ENCLOSURES & EXIT PASSAGEWAYS	CORRIDORS	ROOMS & ENCLOSED SPACES
A-2	B	B	C
	FLAME-SPREAD 26-75 SMOKE DEVELOPED 0-450	FLAME-SPREAD 26-75 SMOKE DEVELOPED 0-450	FLAME-SPREAD 76-200 SMOKE DEVELOPED 0-450

PROJECT

WING SNOB
3415 E. SAGINAW SUITE D
LANSING, MI 48912

BUILDER/CLIENT
WING SNOB

PRELIMINARY ○
CONSTRUCTION ●
PERMIT ●
SHEET TITLE:
FINISHES PLAN

DATE: 01-17-2022
02-28-2022
03-03-2022

DRAWN BY:
J.M.P.

CHECKED BY:
J.M.P.

JOB NUMBER:
22 - 110

SHEET NUMBER: