


NORTH ELEVATION 1/4" = 1'-0" **1**

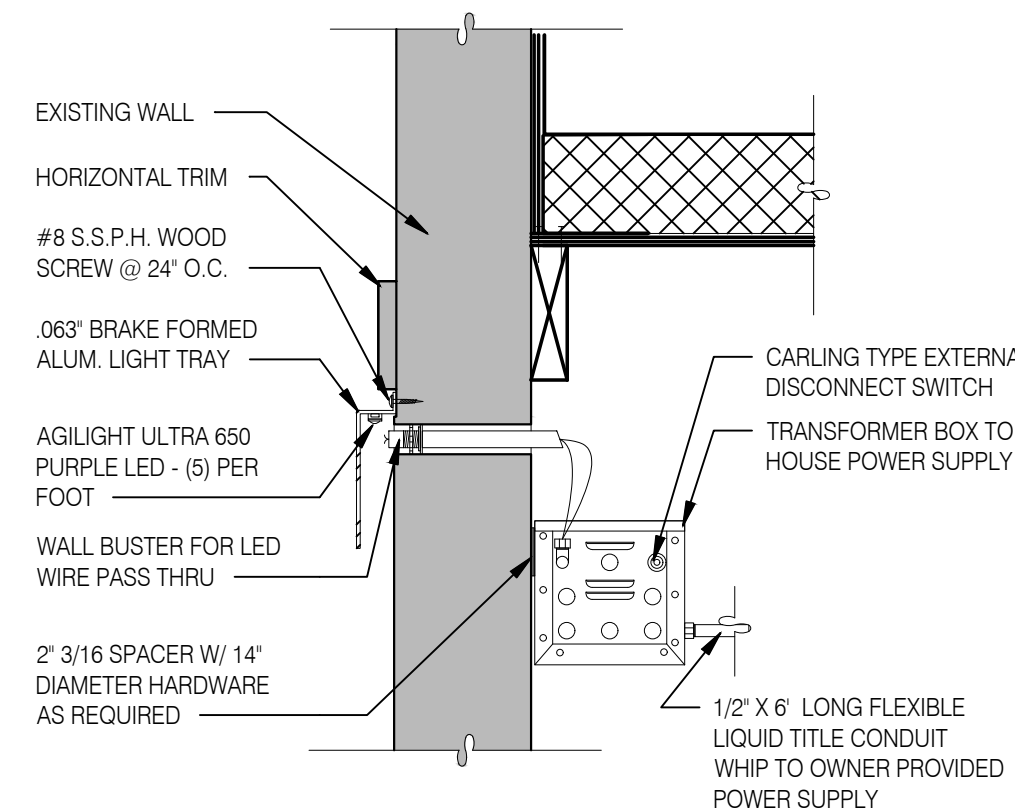

LED WALL WASHER DETAIL **F**

TYPE MARK	QTY	ITEM DESCRIPTION	LOC
TOWER			
V-09.14W	2	14" WHITE CHANNEL LETTERS VERTICAL	A4.1
SIDE ENTRY			
V-04.42	2	42" SWINGING BELL PURPLE LOGO FACE LIT	A4.1
V-200.EN	1	SIDE ENTRY AWNING 6' 4" X 6' 3" BLACK	A4.0
DRIVE THRU			
V-101.DT	1	DT AWNING (OVER DT) 9' 0" X 4' 0" BLACK	A4.1
EYEBROW AWNINGS			
V-202.EN	1	FRONT EYEBROW (WINDOW) 16' 7" X 6" H X 1' 4" D BLACK	A4.1
V-203.EN	1	DT EYEBROW (WINDOW) 7' 8" X 6" H X 1' 4" D BLACK	A4.1
V-201.EN	1	SIDE ENTRY EYEBROW (WINDOW) 12' L 6" H X 1' 4" D BLACK	A4.0

SIGNAGE **E**

MISCELLANEOUS
 A. SEE SHEET A1.1 "WINDOW TYPES" FOR WINDOW ELEVATIONS.
SEALERS (REFER TO SPECS)
 A. SEALANT AT ALL WALL AND ROOF PENETRATIONS.
 B. SEALANT AT ALL WINDOW AND DOOR FRAMES AND JAMB. DO NOT SEAL SILL @ WINDOWS.
 C. APPLY NEOPRENE GASKET (CONT.) BETWEEN BUILDING AND CANOPY.
CRITICAL DIMENSIONS
 A. REQUIRED CLEAR OPENING WIDTH TO ENSURE COORDINATION WITH STANDARD SIGNAGE/BUILDING ELEMENTS DIMENSIONS.
 NOTE: NO EXTERIOR SIGNS ARE WITHIN THE SCOPE OF WORK COVERED BY THE BUILDING PERMIT APPLICATION. THE GENERAL CONTRACTOR SHALL BE RESPONSIBLE FOR COORDINATING THE INSTALLATION OF ALL EXTERIOR SIGNS AND INSTALLATION OF REQUIRED BLOCKING AND ELECTRICAL CONNECTIONS FOR FINAL APPROVED SIGNS.

GENERAL NOTES **C**

X	NAME	FAMILY	FRAME OR MURAL	SIZE	LOCATION
6516	HYPNOTIZE ME BELL	D	M02	48x96	A4.0
6517	HYPNOTIZE ME BELL	D	M02	48x96	A4.0
6518	HYPNOTIZE ME BELL	D	M02	48x96	A4.1
6519	HYPNOTIZE ME BELL	D	M02	48x96	A4.1

PAINTING
 APPLICATOR MUST DO THEIR DUE DILIGENCE WITH PREPARATION.
 PRIMER: 1 COAT SW A24W8300
 FINISH: 2 COATS SW A82-100 SERIES, MATCH COLORS FROM MATERIAL SCHEDULE.
 A-100 EXTERIOR LATEX SATIN.

PAINT NOTES **A**

SYMBOL	ITEM/MATERIAL	MANUFACTURER	MATERIAL SPEC	COLOR	CONTACT INFORMATION
1	1-1/2" DRAINABLE EIFS SYSTEM	STO	StoTHERM ci LOTUSAN	COLOR TO MATCH WORLDLY GRAY (SW7043)	
2	SCUPPERS / DOWNSPOUTS	-	-	WORLDLY GRAY (SW7043), SEMI-GLOSS	
3	SCUPPER / DOWNSPOUTS	-	-	CYBERSPACE (SW7076), SEMI-GLOSS	
4	2" DRAINABLE EIFS SYSTEM	STO	StoTHERM ci LOTUSAN	COLOR TO MATCH CYBERSPACE (SW7076)	
5	1-1/2" DRAINABLE EIFS SYSTEM	STO	StoTHERM ci LOTUSAN	COLOR TO MATCH CYBERSPACE (SW7076)	
6	HOLLOW METAL DOOR	-	-	SW PURPLE TB2603C, SEMI-GLOSS	
7	AWNINGS	SIGNAGE VENDOR	-	BLACK BY THE SIGNAGE VENDOR	
8	CORNER TOWER	WESTERN STATE	T-GROOVE 24GA PAINTED 18" PANEL	WEATHERED RUSTIC	SEE C / A 7.2
9	RECESS OF SIDE ENTRY PORTAL	WESTERN STATE	T-GROOVE 24GA PAINTED 18" PANEL	WEATHERED RUSTIC	SEE C / A 7.2
10	1-1/2" DRAINABLE EIFS SYSTEM	STO	StoTHERM ci LOTUSAN	COLOR TO MATCH SW PURPLE TB2603C	
11	METAL PARAPET CAP	-	24GA GALVANIZED	CYBERSPACE (SW7076) KYNAR 500 COATING	

EXTERIOR FINISH SCHEDULE **D**

- 329 MECHANICAL UNIT. SEE ROOF PLAN.
- 401 BUILDING SIGN BY VENDOR. REQUIRES ELECTRICAL, SEE ELECTRICAL PLANS.
- 407 METAL CANOPIES BY VENDOR. REQUIRES ELECTRICAL, SEE ELECTRICAL PLANS.
- 408 CO2 FILLER VALVE & COVER.
- 416 HOSE BIB BOX AT 18" A.F.F.
- 419 EXTERIOR LIGHT FIXTURE. SEE ELECTRICAL DRAWINGS.
- 422 PURPLE LIGHT WALL WASHER, PROVIDED BY SIGNAGE VENDOR.
- 424 LINE OF ROOF BEYOND
- 430 3/4" V SHAPED REVEAL AT EIFS

KEY NOTES **B**



DATE	REMARKS
02/14/2022	ISSUED FOR REVIEW
02/16/2022	ISSUED FOR PERMIT
02/22/2022	ISSUED FOR BID
03/10/2022	HVAC REVISIONS
03/29/2022	BID REVISIONS

CONTRACT DATE:
 BUILDING TYPE: END. MED40
 PLAN VERSION: MARCH 2021


SITE NUMBER: TBD
 STORE NUMBER: TBD
 PA/PM: DJW
 DRAWN BY: CLL
 JOB NO.: 21122

TACO BELL
 5501 Grape Rd
 Mishawaka, IN 46545



**ENDEAVOR 2.0
 EXTERIOR
 ELEVATIONS**

A4.0

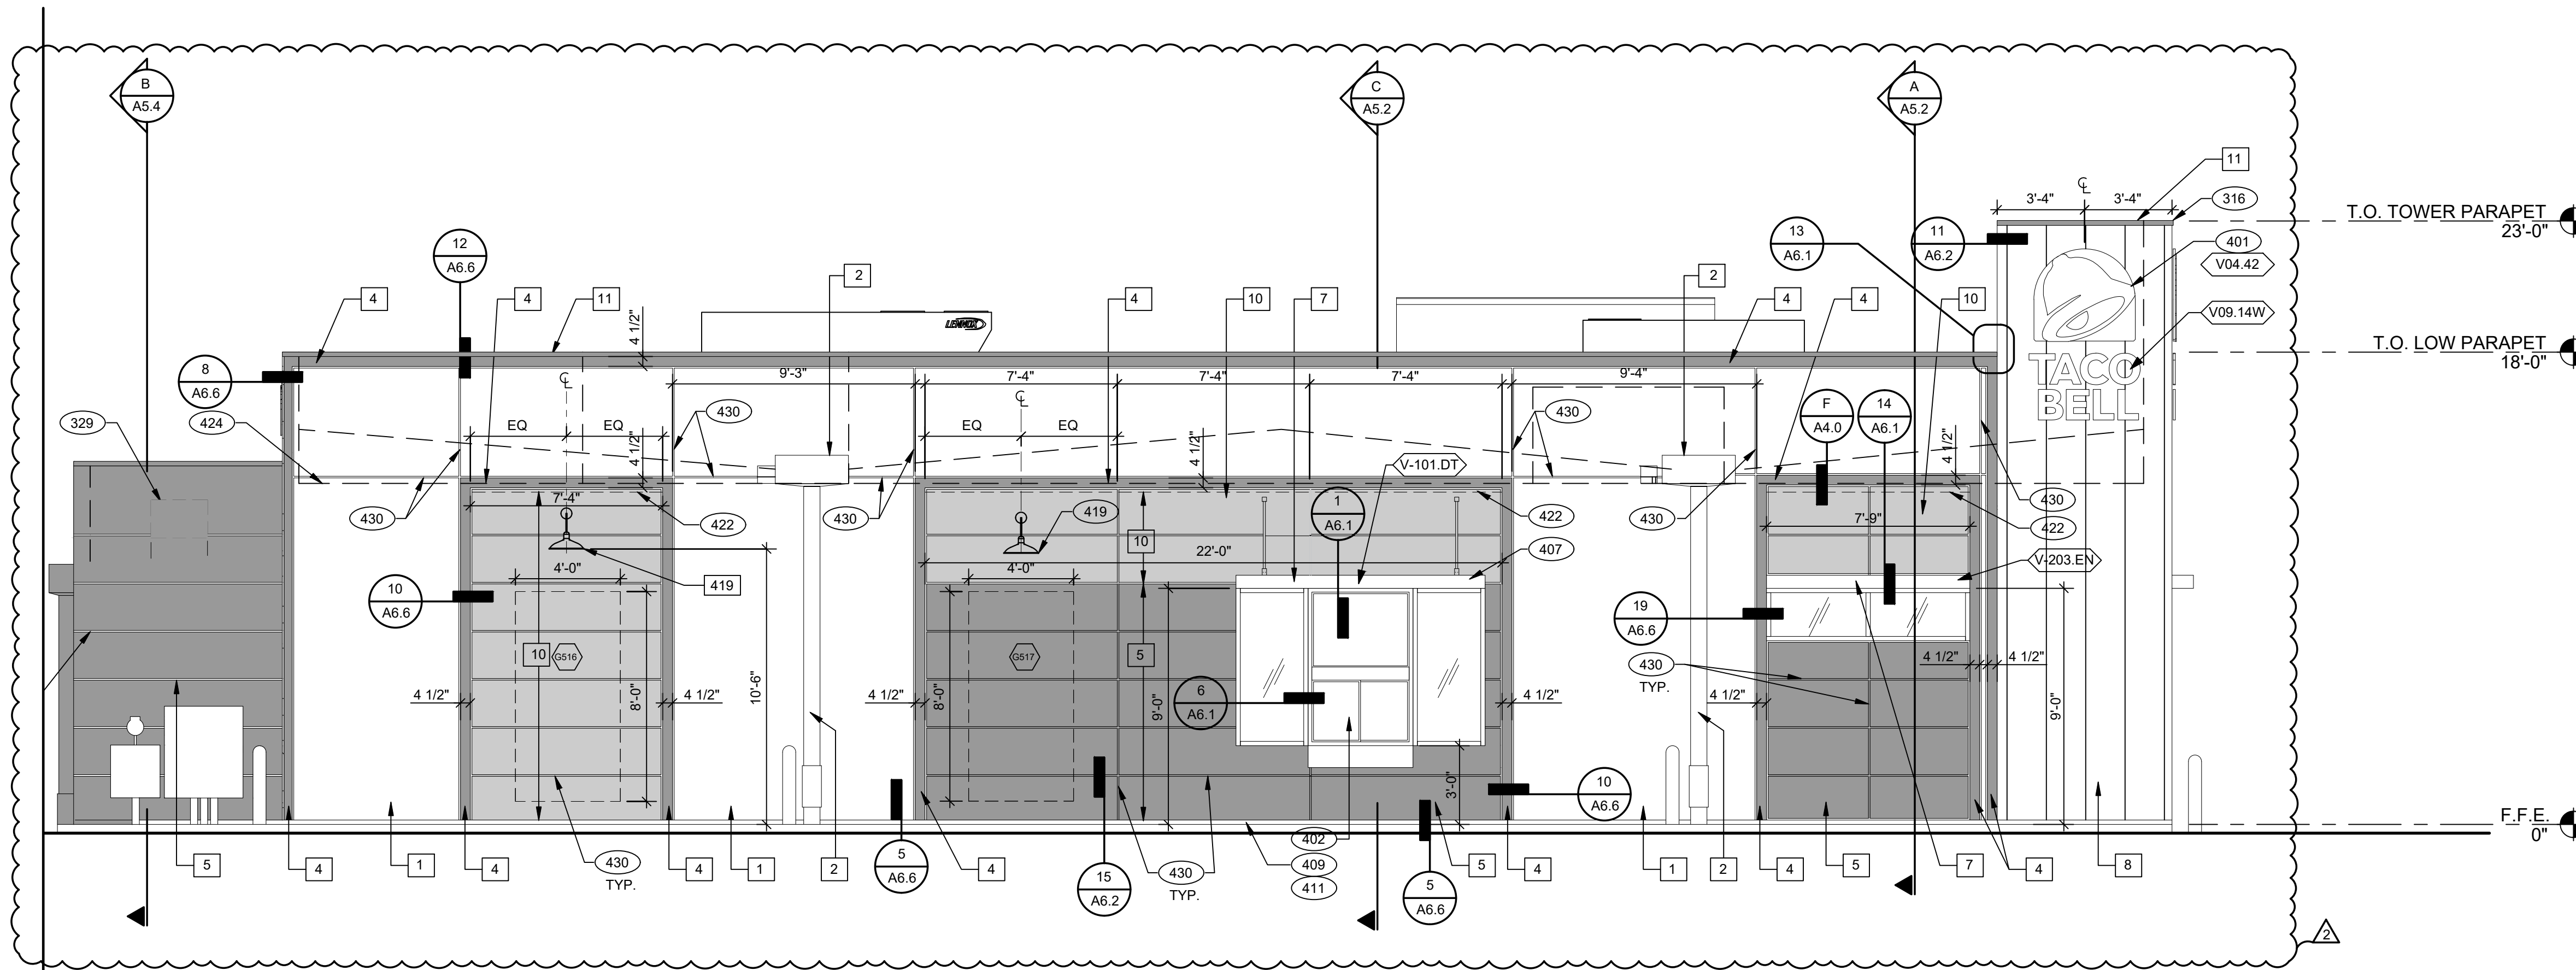

- SEE SHEET A4.0 FOR FINISH SCHEDULE
- 316 METAL PARAPET CAP.
 - 329 MECHANICAL UNIT. SEE ROOF PLAN.
 - 401 BUILDING SIGN BY VENDOR. REQUIRES ELECTRICAL. SEE ELECTRICAL PLANS.
 - 402 DRIVE THRU WINDOW. SEE SHEET A1.0 AND A1.1.
 - 407 METAL CANOPIES BY VENDOR. REQUIRES ELECTRICAL. SEE ELECTRICAL PLANS.
 - 409 ASSUME DIT LANE SURFACE IS 6" BELOW THE FINISH FLOOR. REFER TO GRADING & SITE PLAN.
 - 411 CONCRETE CURB.
 - 419 EXTERIOR LIGHT FIXTURE. SEE ELECTRICAL DRAWINGS.
 - 422 PURPLE LIGHT WALL WASHER, PROVIDED BY SIGNAGE VENDOR.
 - 424 LINE OF ROOF BEYOND.
 - 430 3/4" V SHAPED REVEAL AT EIFS

NOTE: ANY ARTWORK USED ON THE EXTERIOR MUST BE FROM THE SAME ARTWORK FAMILY AS THE INTERIOR

SOUTH ELEVATION 1/4" = 1'-0" **1**

KEY NOTES **A**




DATE	REMARKS
02/14/2022	ISSUED FOR REVIEW
02/16/2022	ISSUED FOR PERMIT
02/22/2022	ISSUED FOR BID
03/10/2022	HVAC REVISIONS
03/29/2022	BID REVISIONS

CONTRACT DATE:
 BUILDING TYPE: END. MED40
 PLAN VERSION: MARCH 2021
 SITE NUMBER: TBD
 STORE NUMBER: TBD
 PA/PM: DJW
 DRAWN BY: CLL
 JOB NO.: 21122


TACO BELL
 5501 Grape Rd
 Mishawaka, IN 46545

ENDEAVOR 2.0
 ELEVATIONS


A4.1

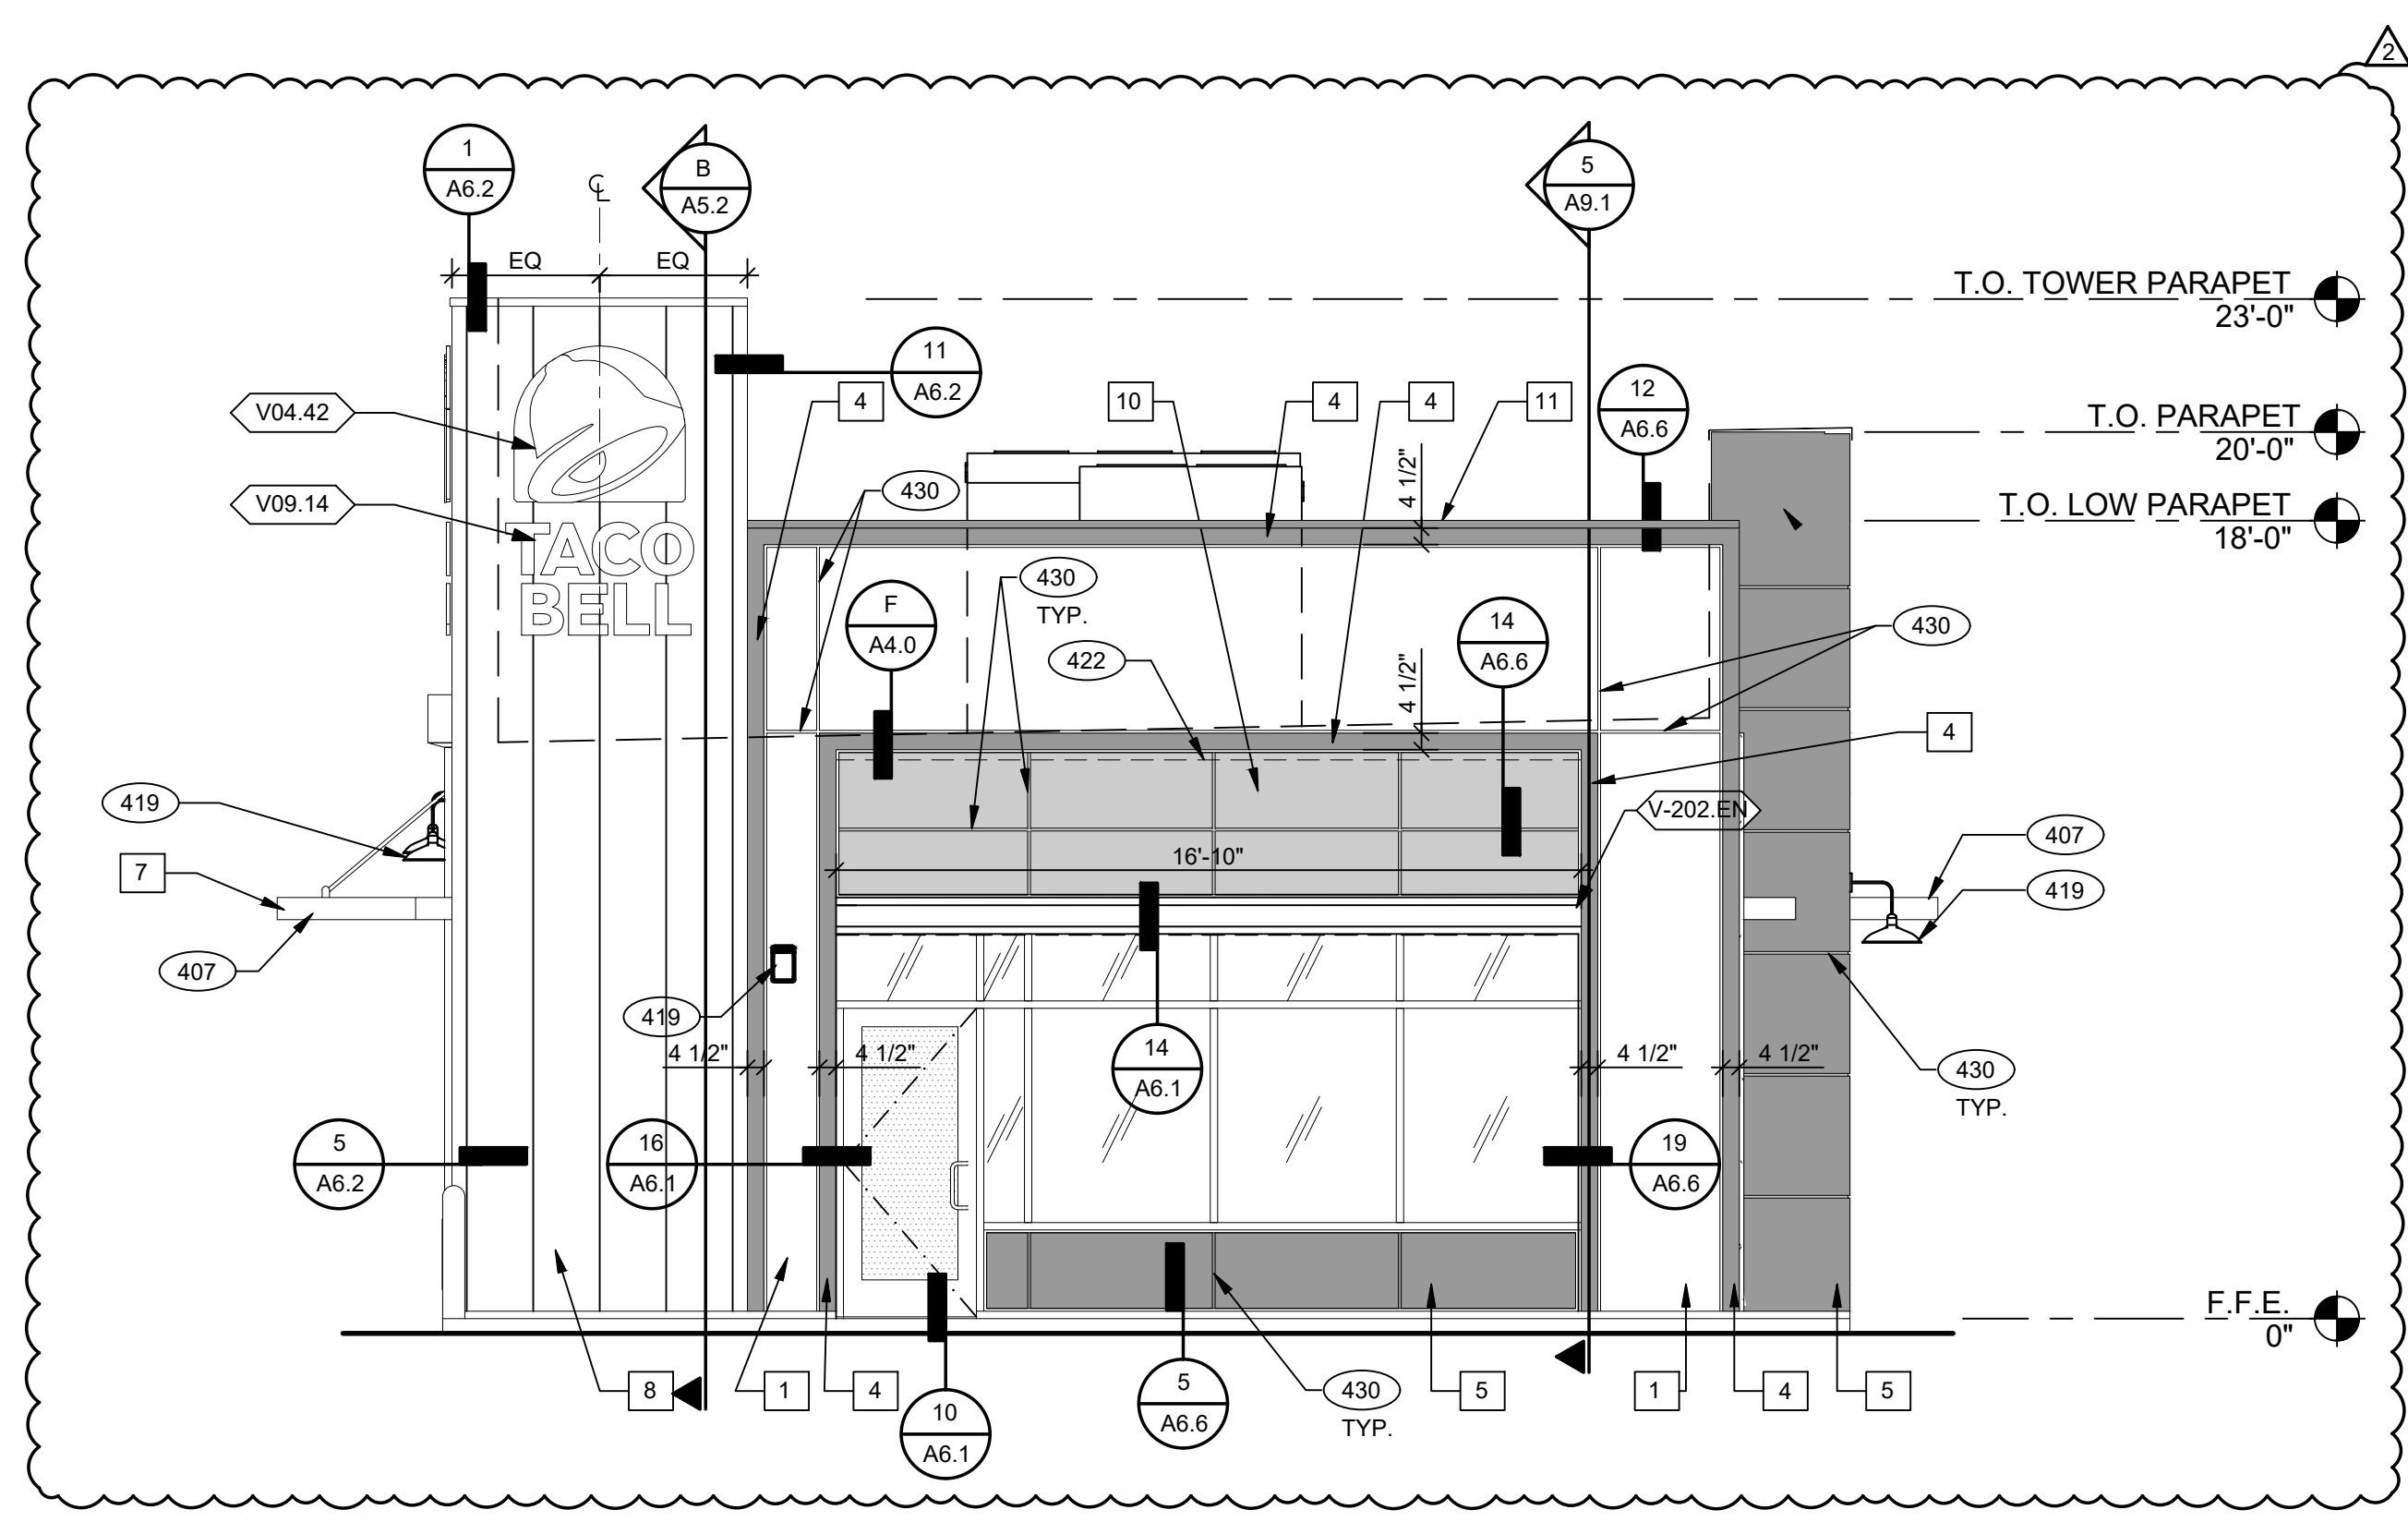


EAST ELEVATION 1/4" = 1'-0" **2**

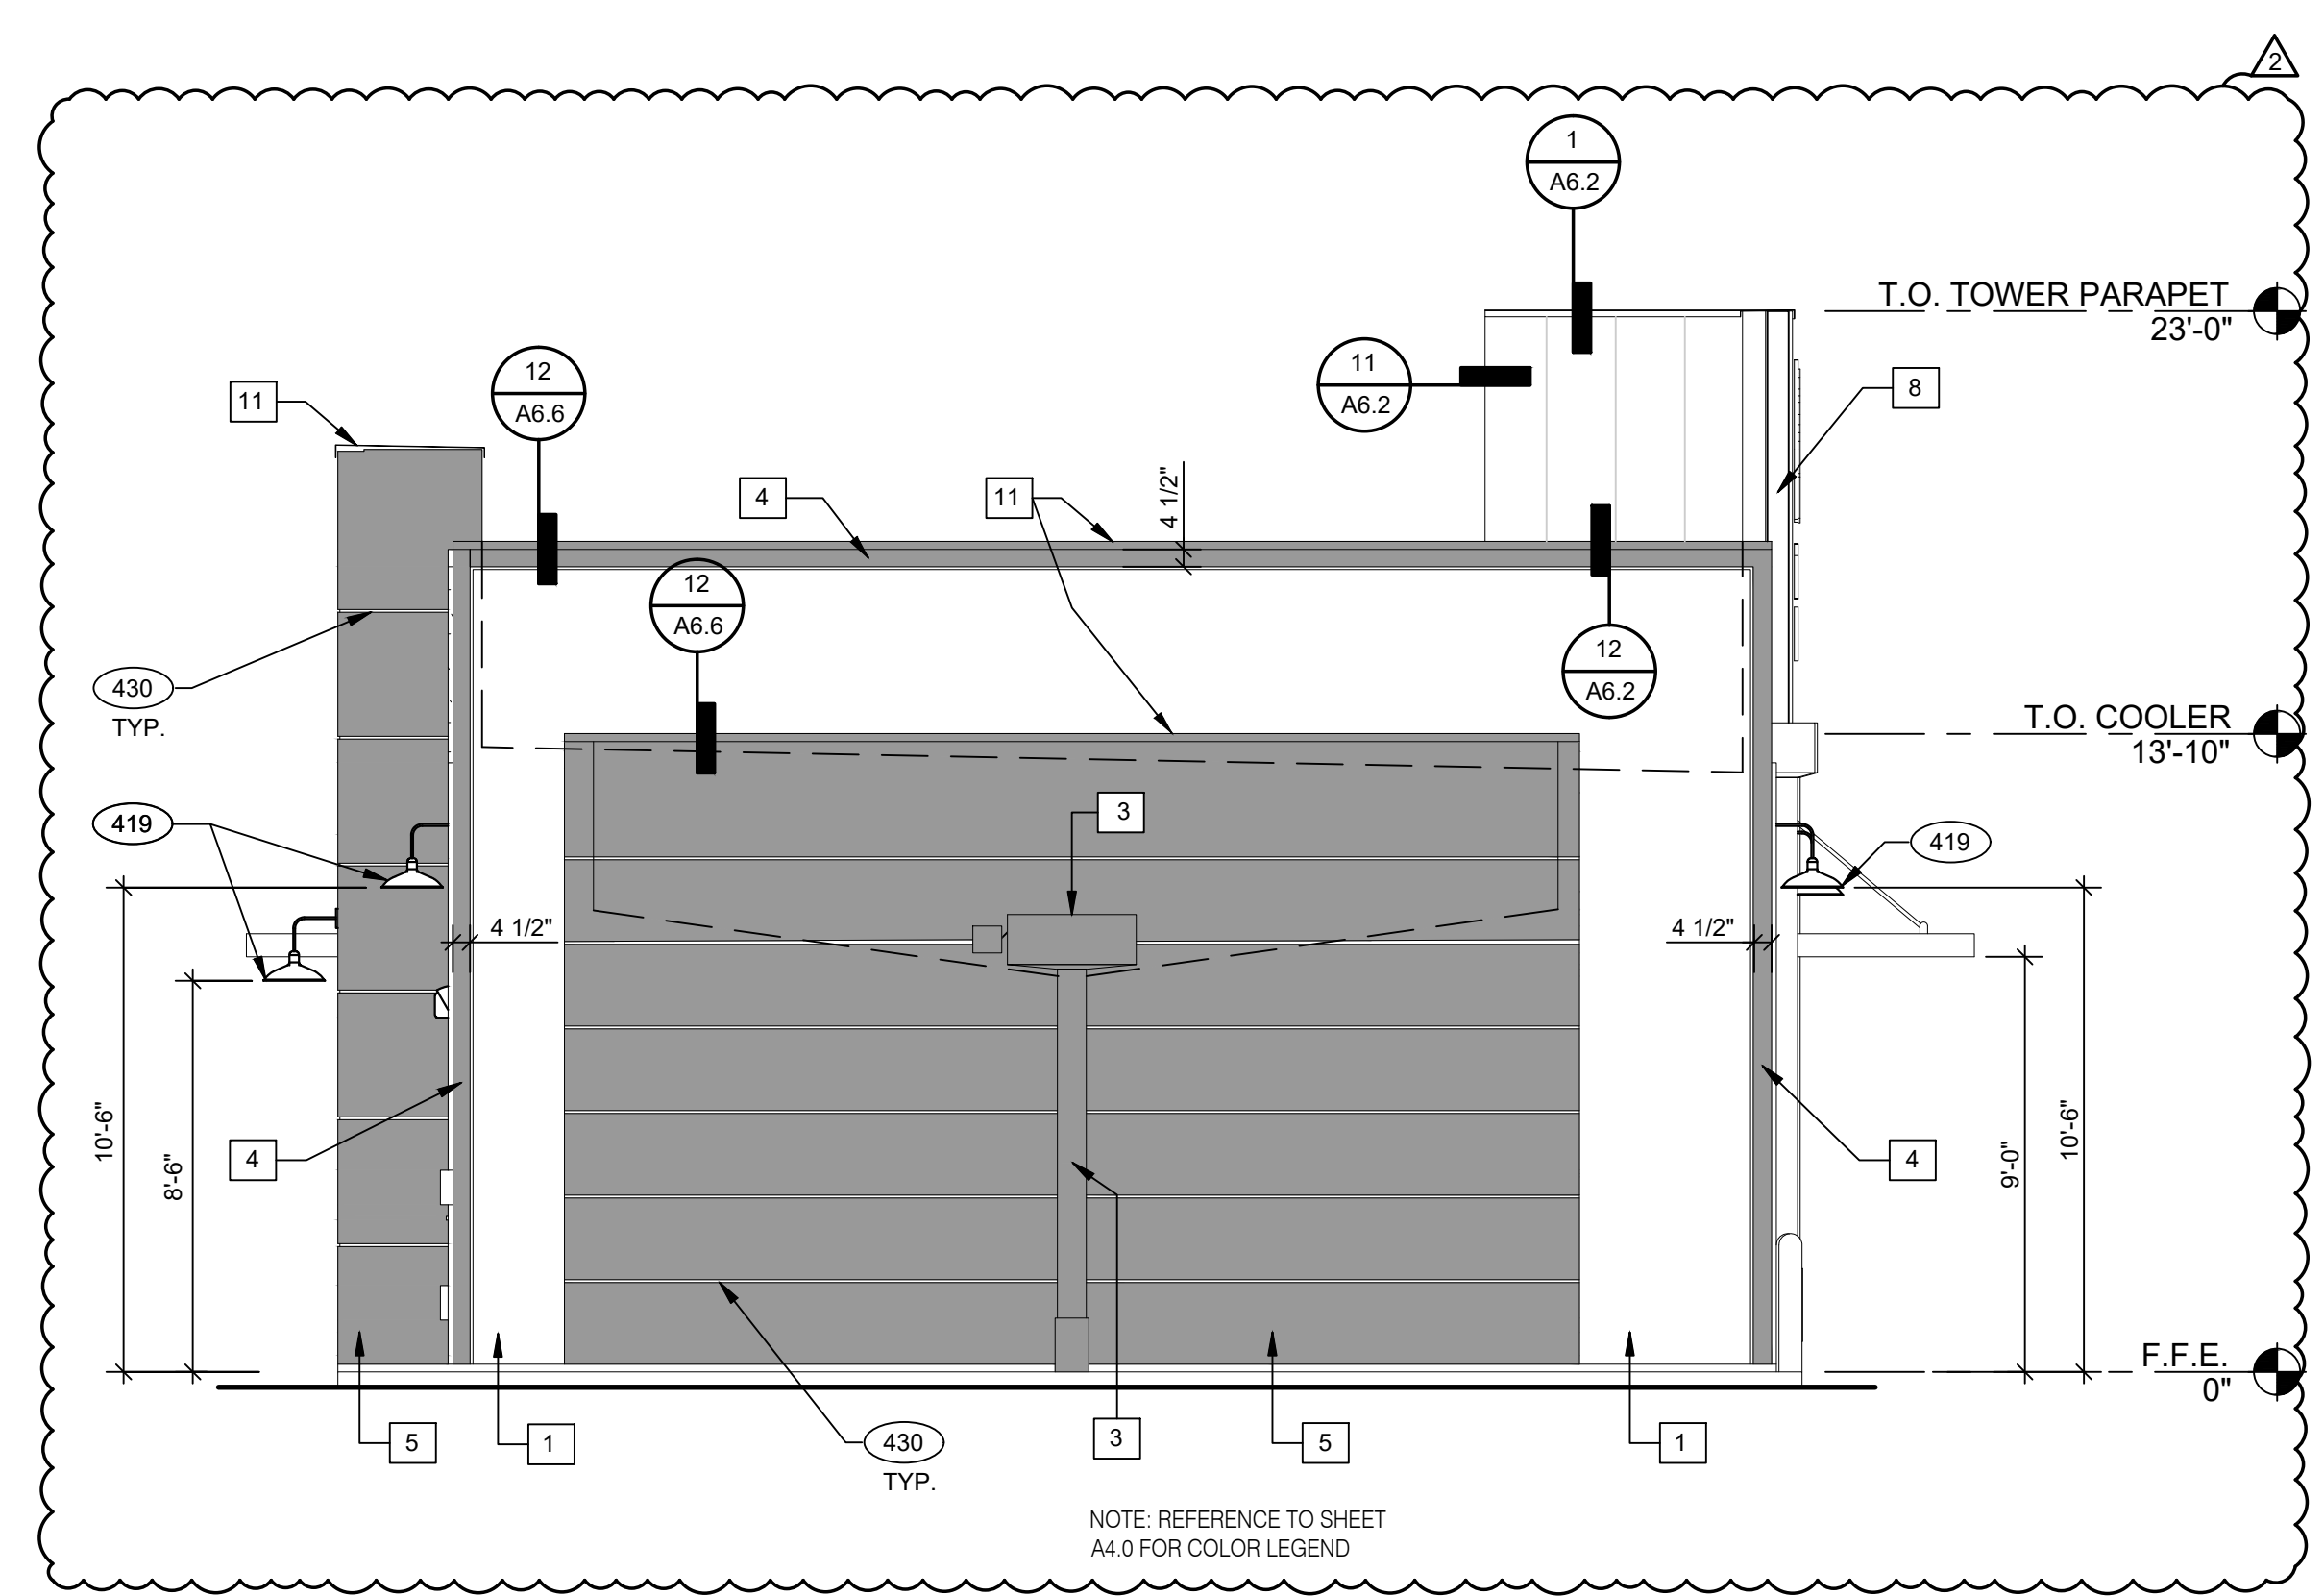

WEST ELEVATION 1/4" = 1'-0" **3**

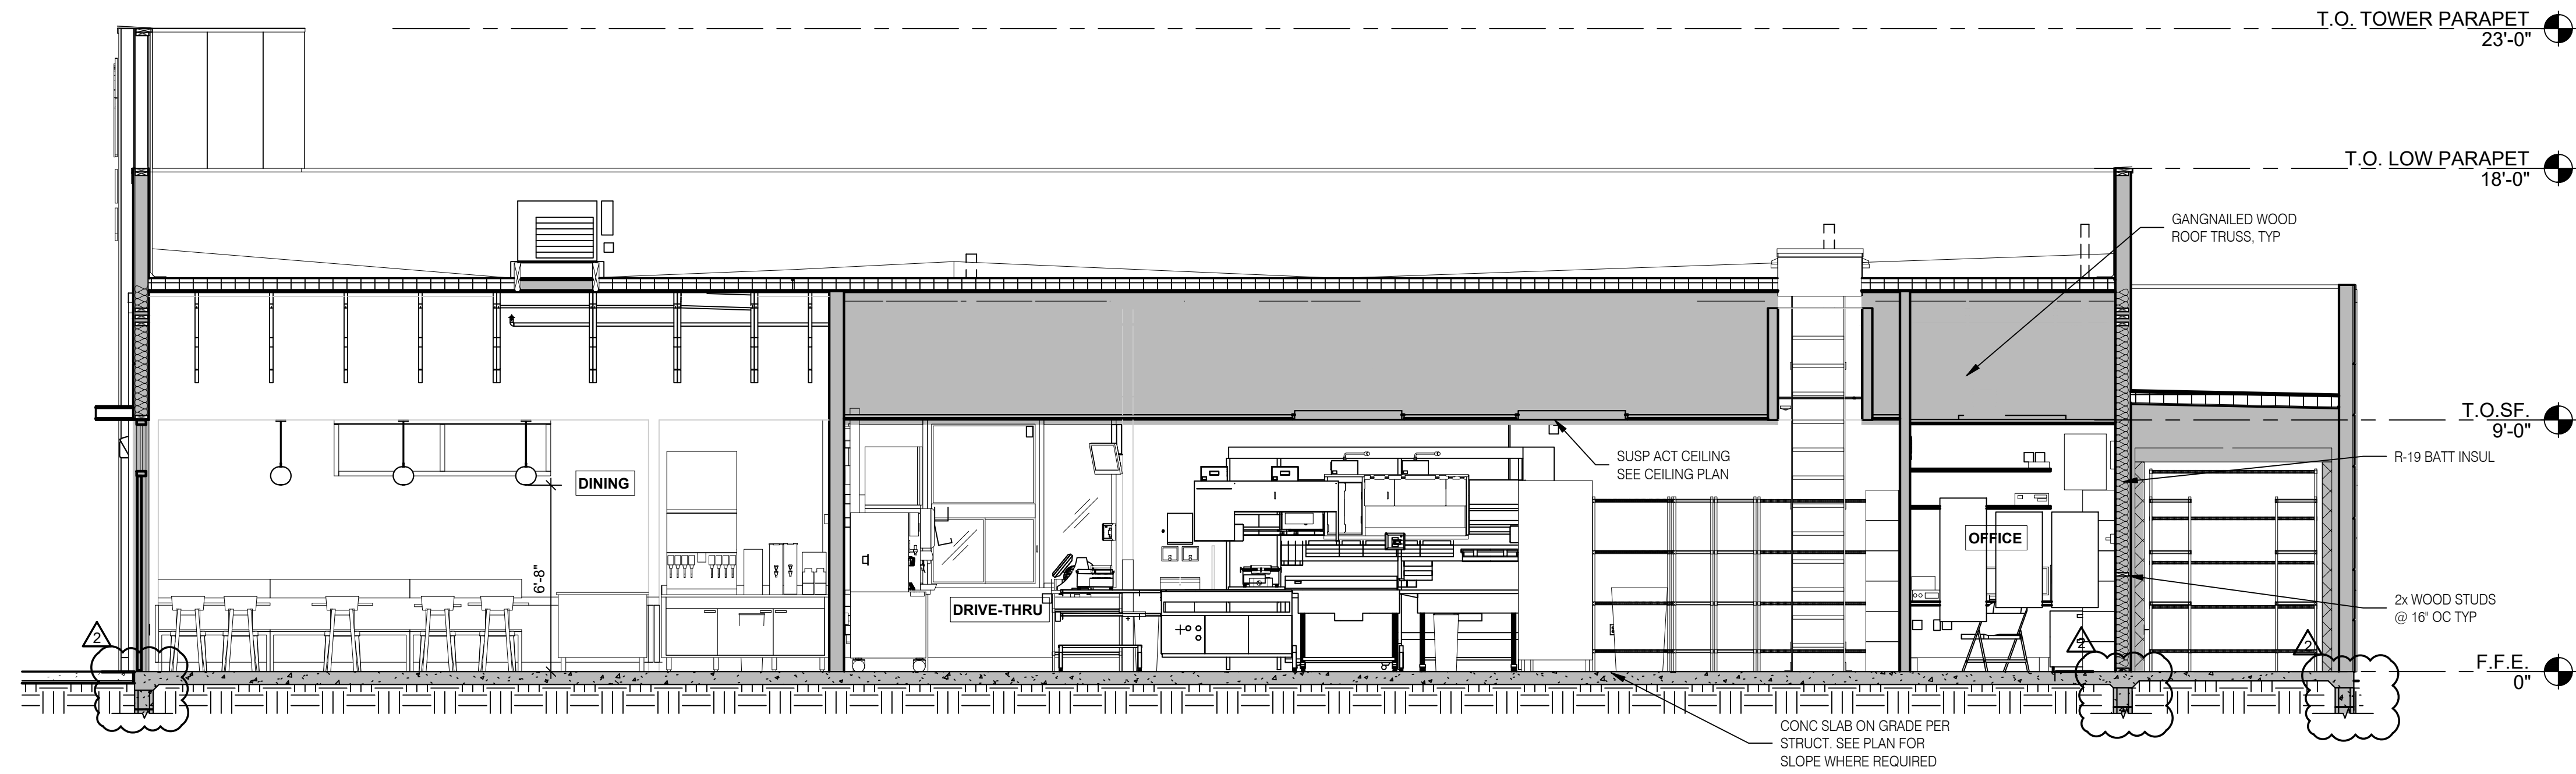

BUILDING SECTION 2 1/4" = 1'-0" **A**

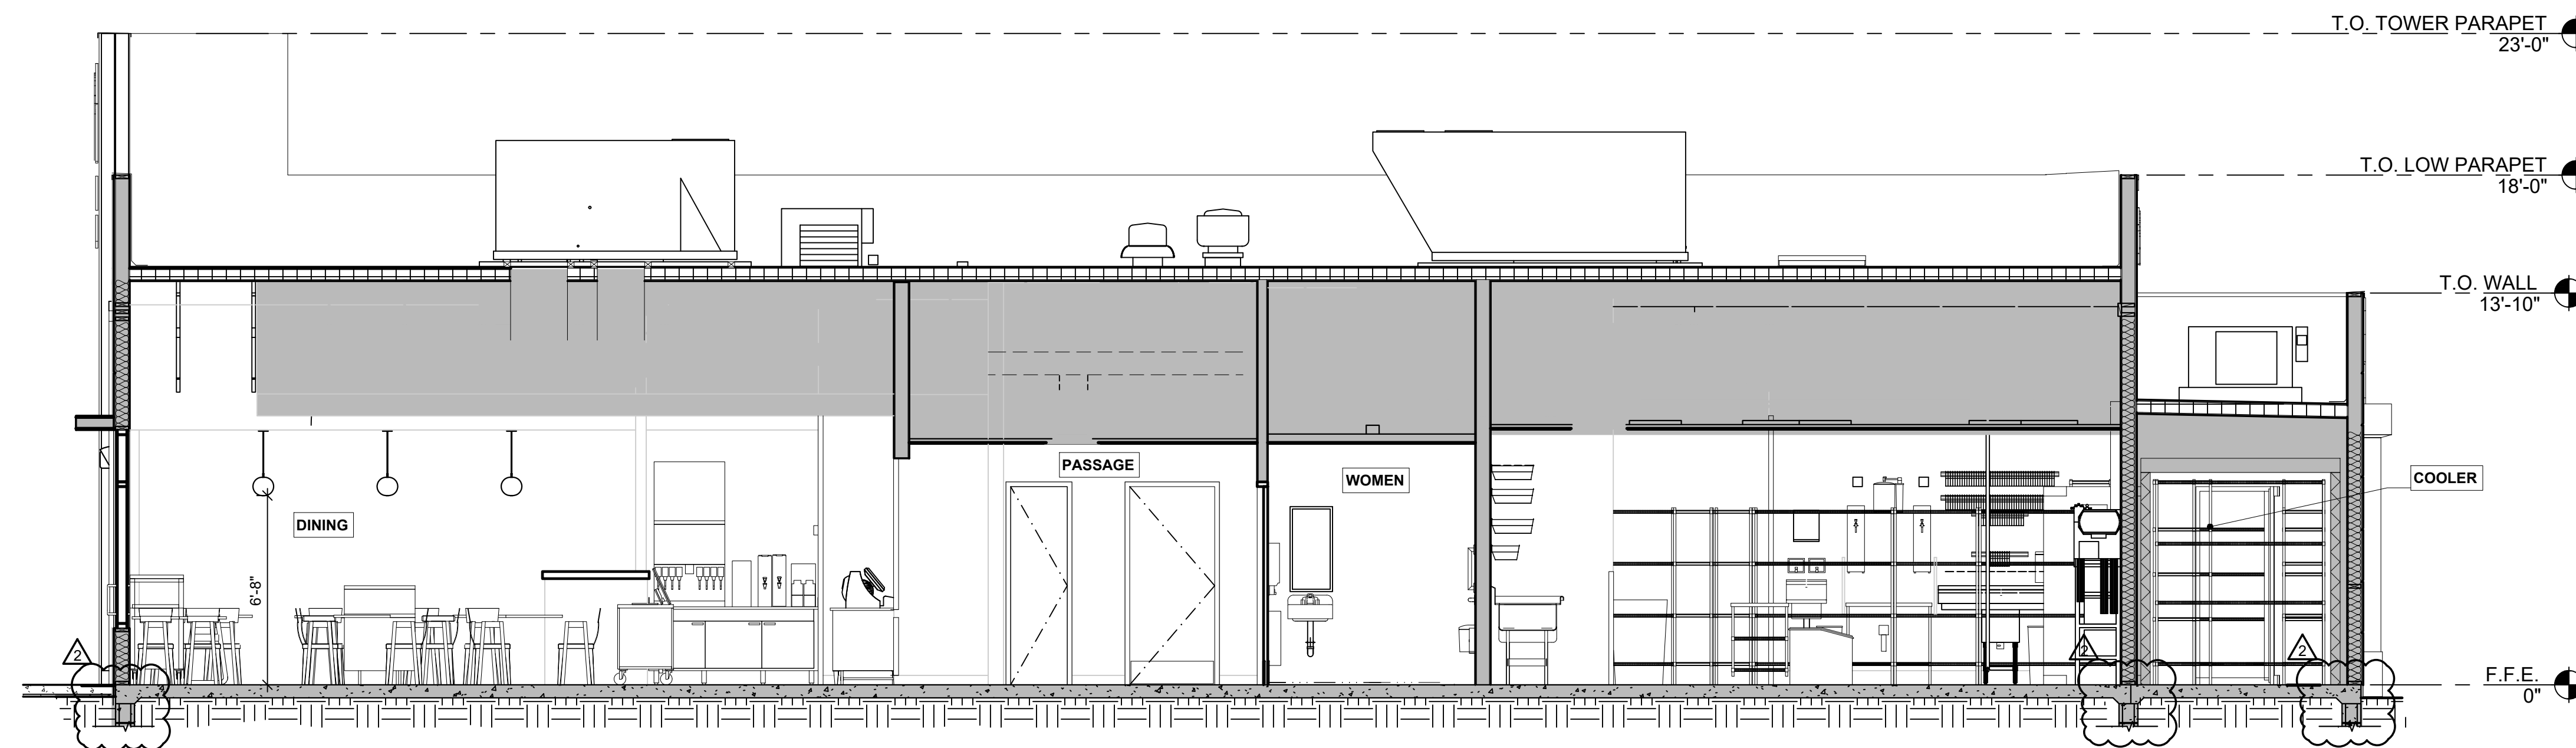

BUILDING SECTION 1 1/4" = 1'-0" **B**



DATE	REMARKS
02/14/2022	ISSUED FOR REVIEW
02/16/2022	ISSUED FOR PERMIT
02/22/2022	ISSUED FOR BID
03/10/2022	HVAC REVISIONS
03/29/2022	BID REVISIONS

CONTRACT DATE:
 BUILDING TYPE: END. MED40
 PLAN VERSION: MARCH 2021


SITE NUMBER: TBD
 STORE NUMBER: TBD
 PA/PM: DJW
 DRAWN BY: CLL
 JOB NO.: 21122

TACO BELL
 5501 Grape Rd
 Mishawaka, IN 46545




ENDEAVOR 2.0
BUILDING SECTIONS


A5.0

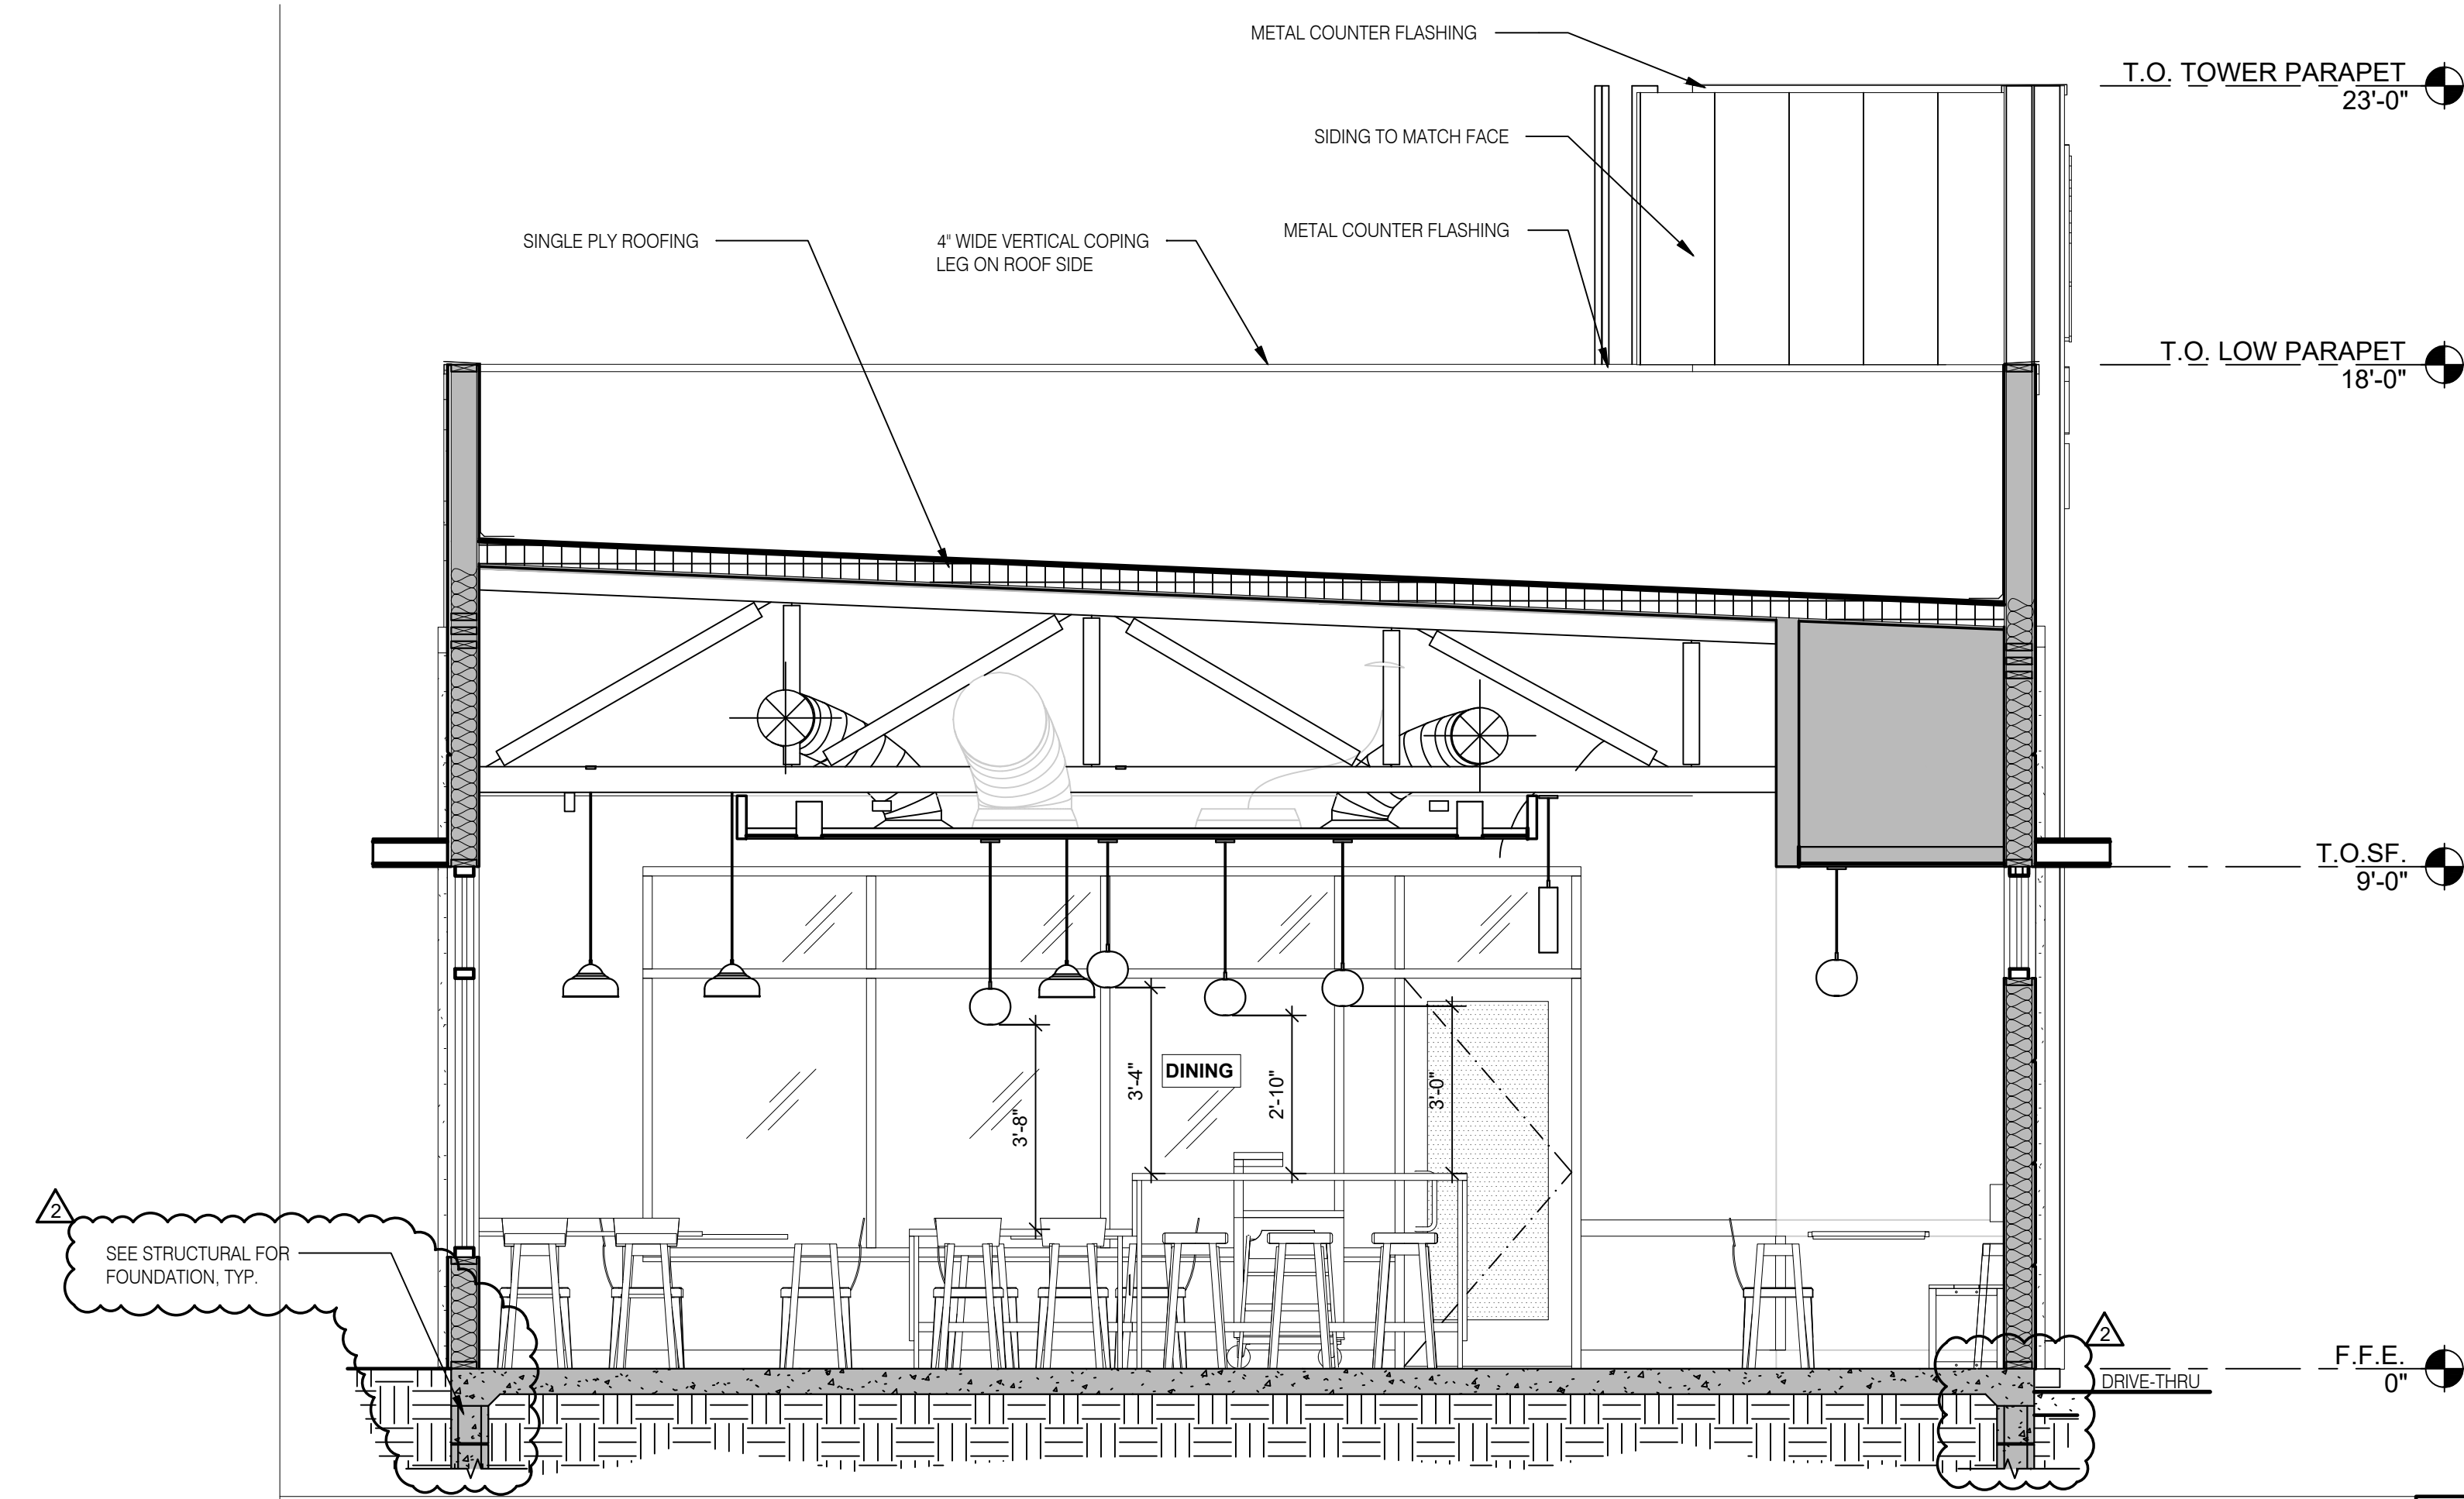

BUILDING SECTION 5 3/8" = 1'-0" **A**

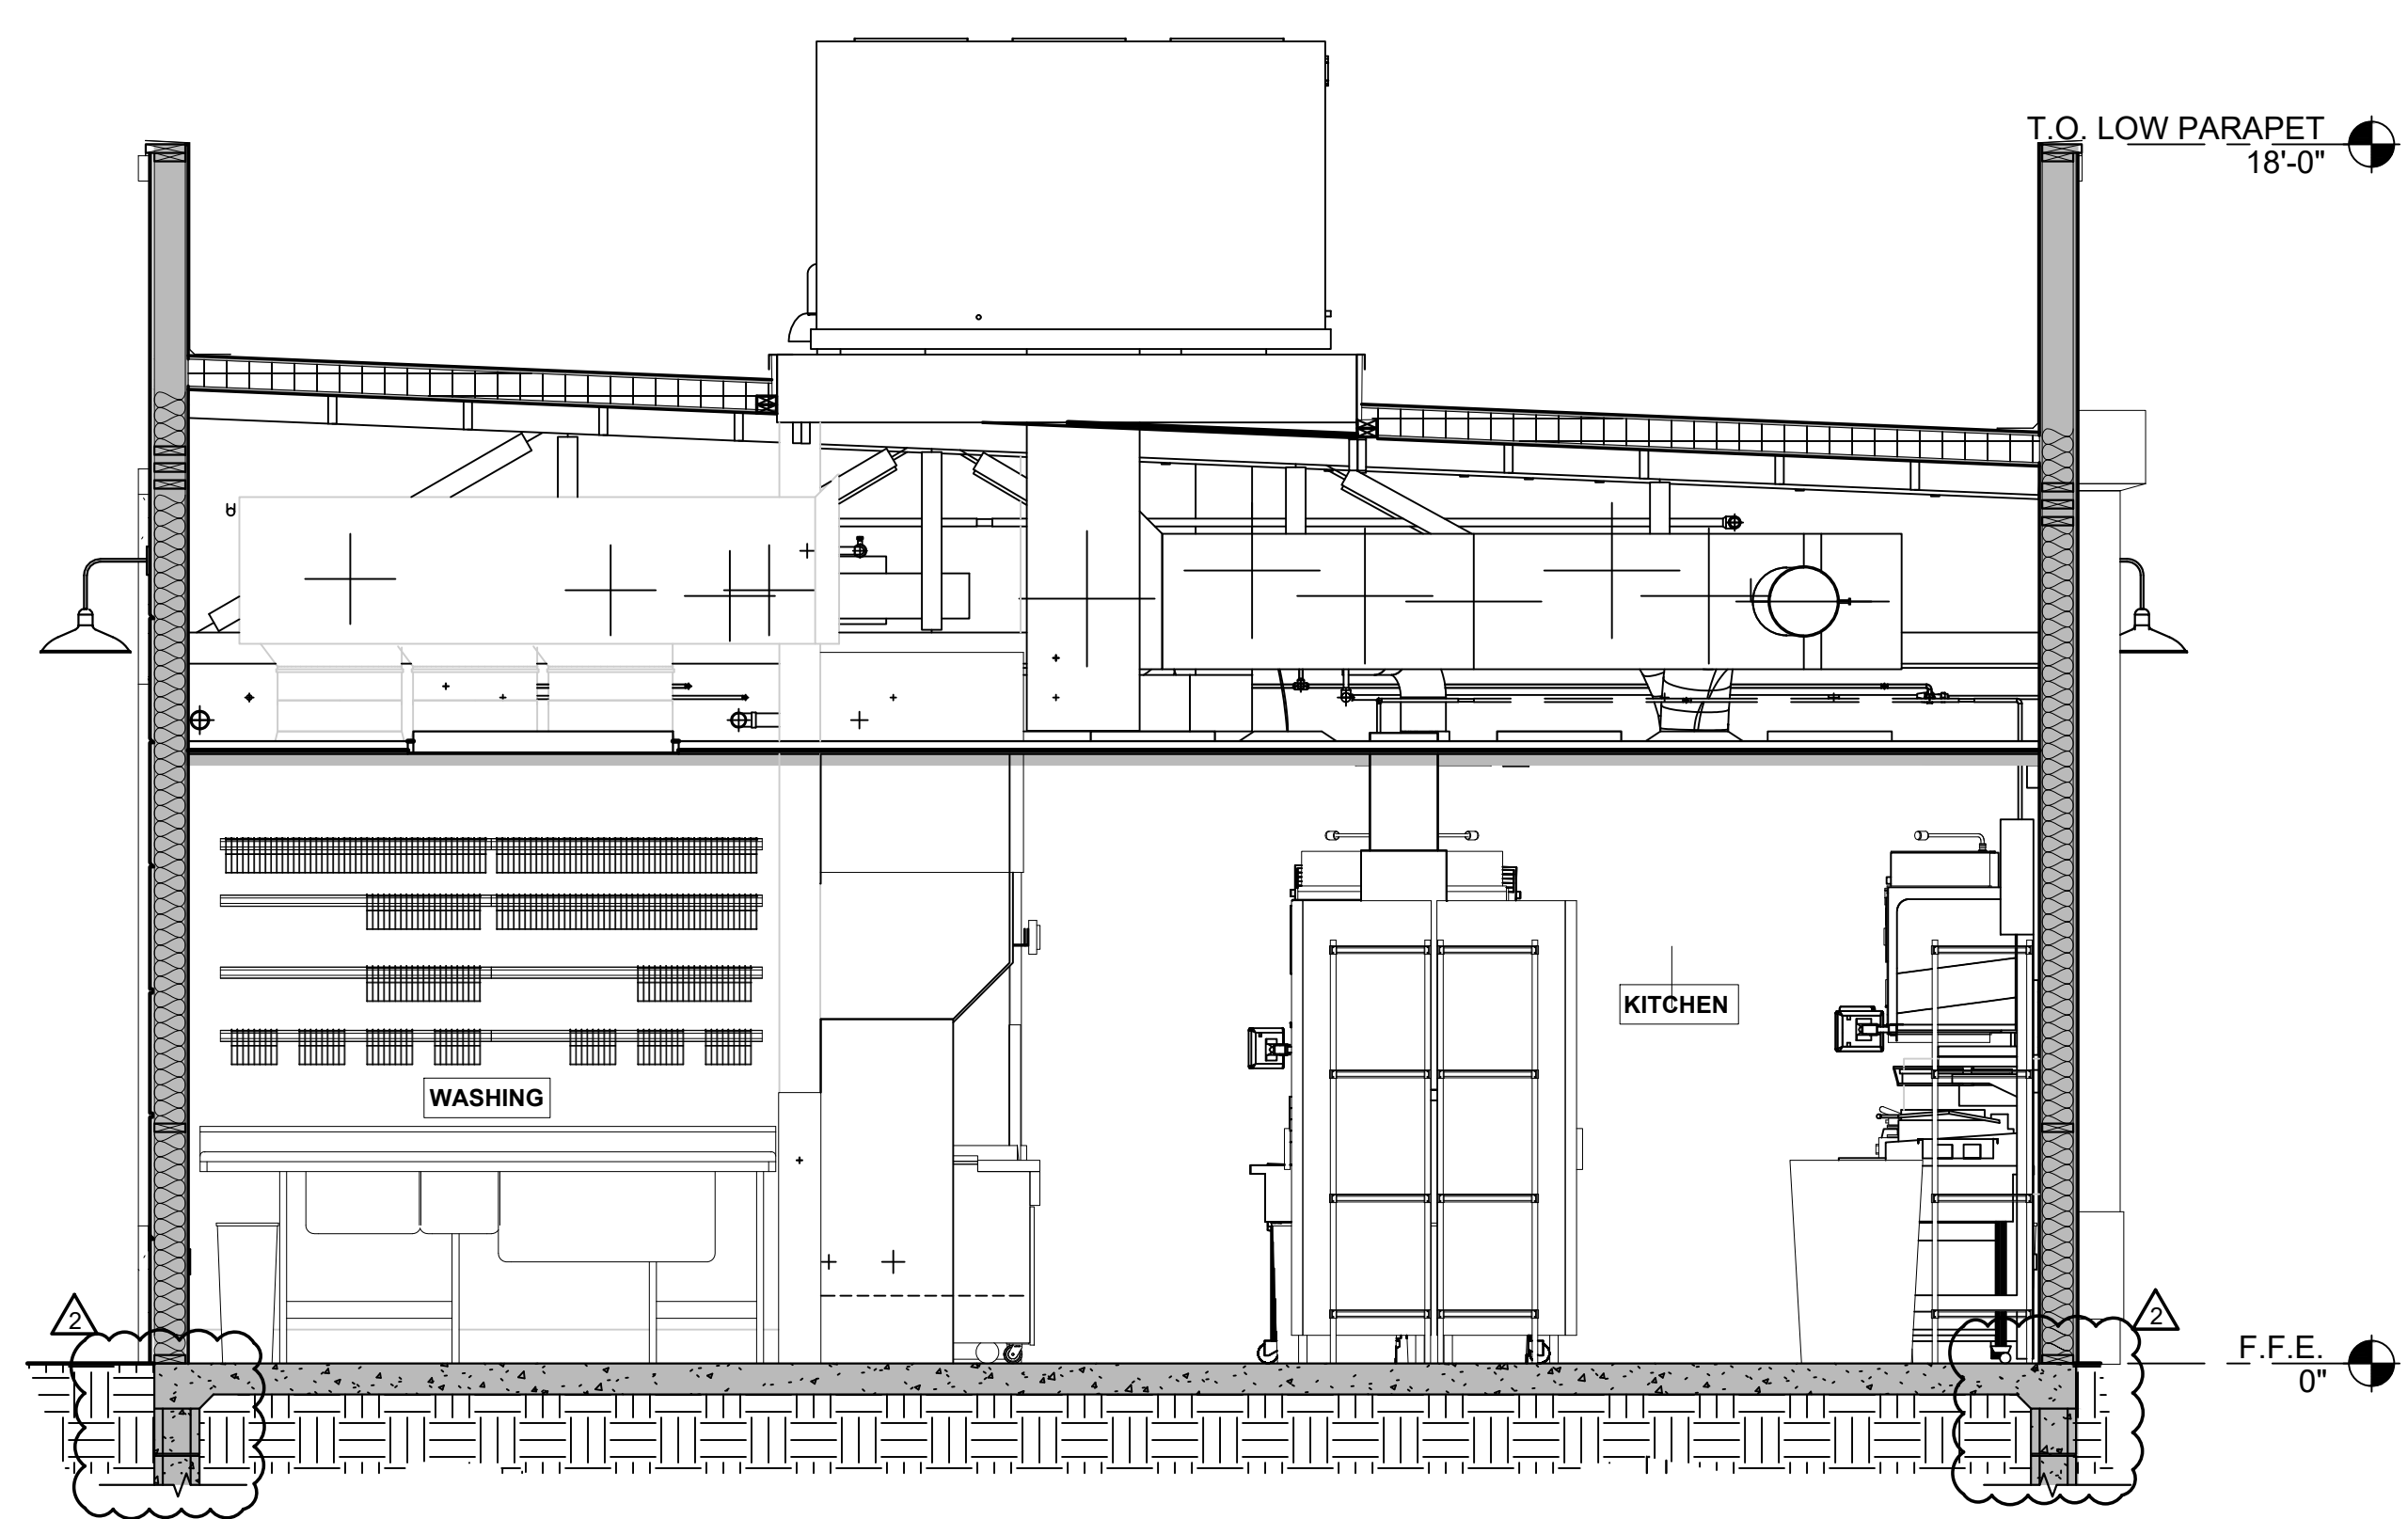

BUILDING SECTION 4 3/8" = 1'-0" **C**

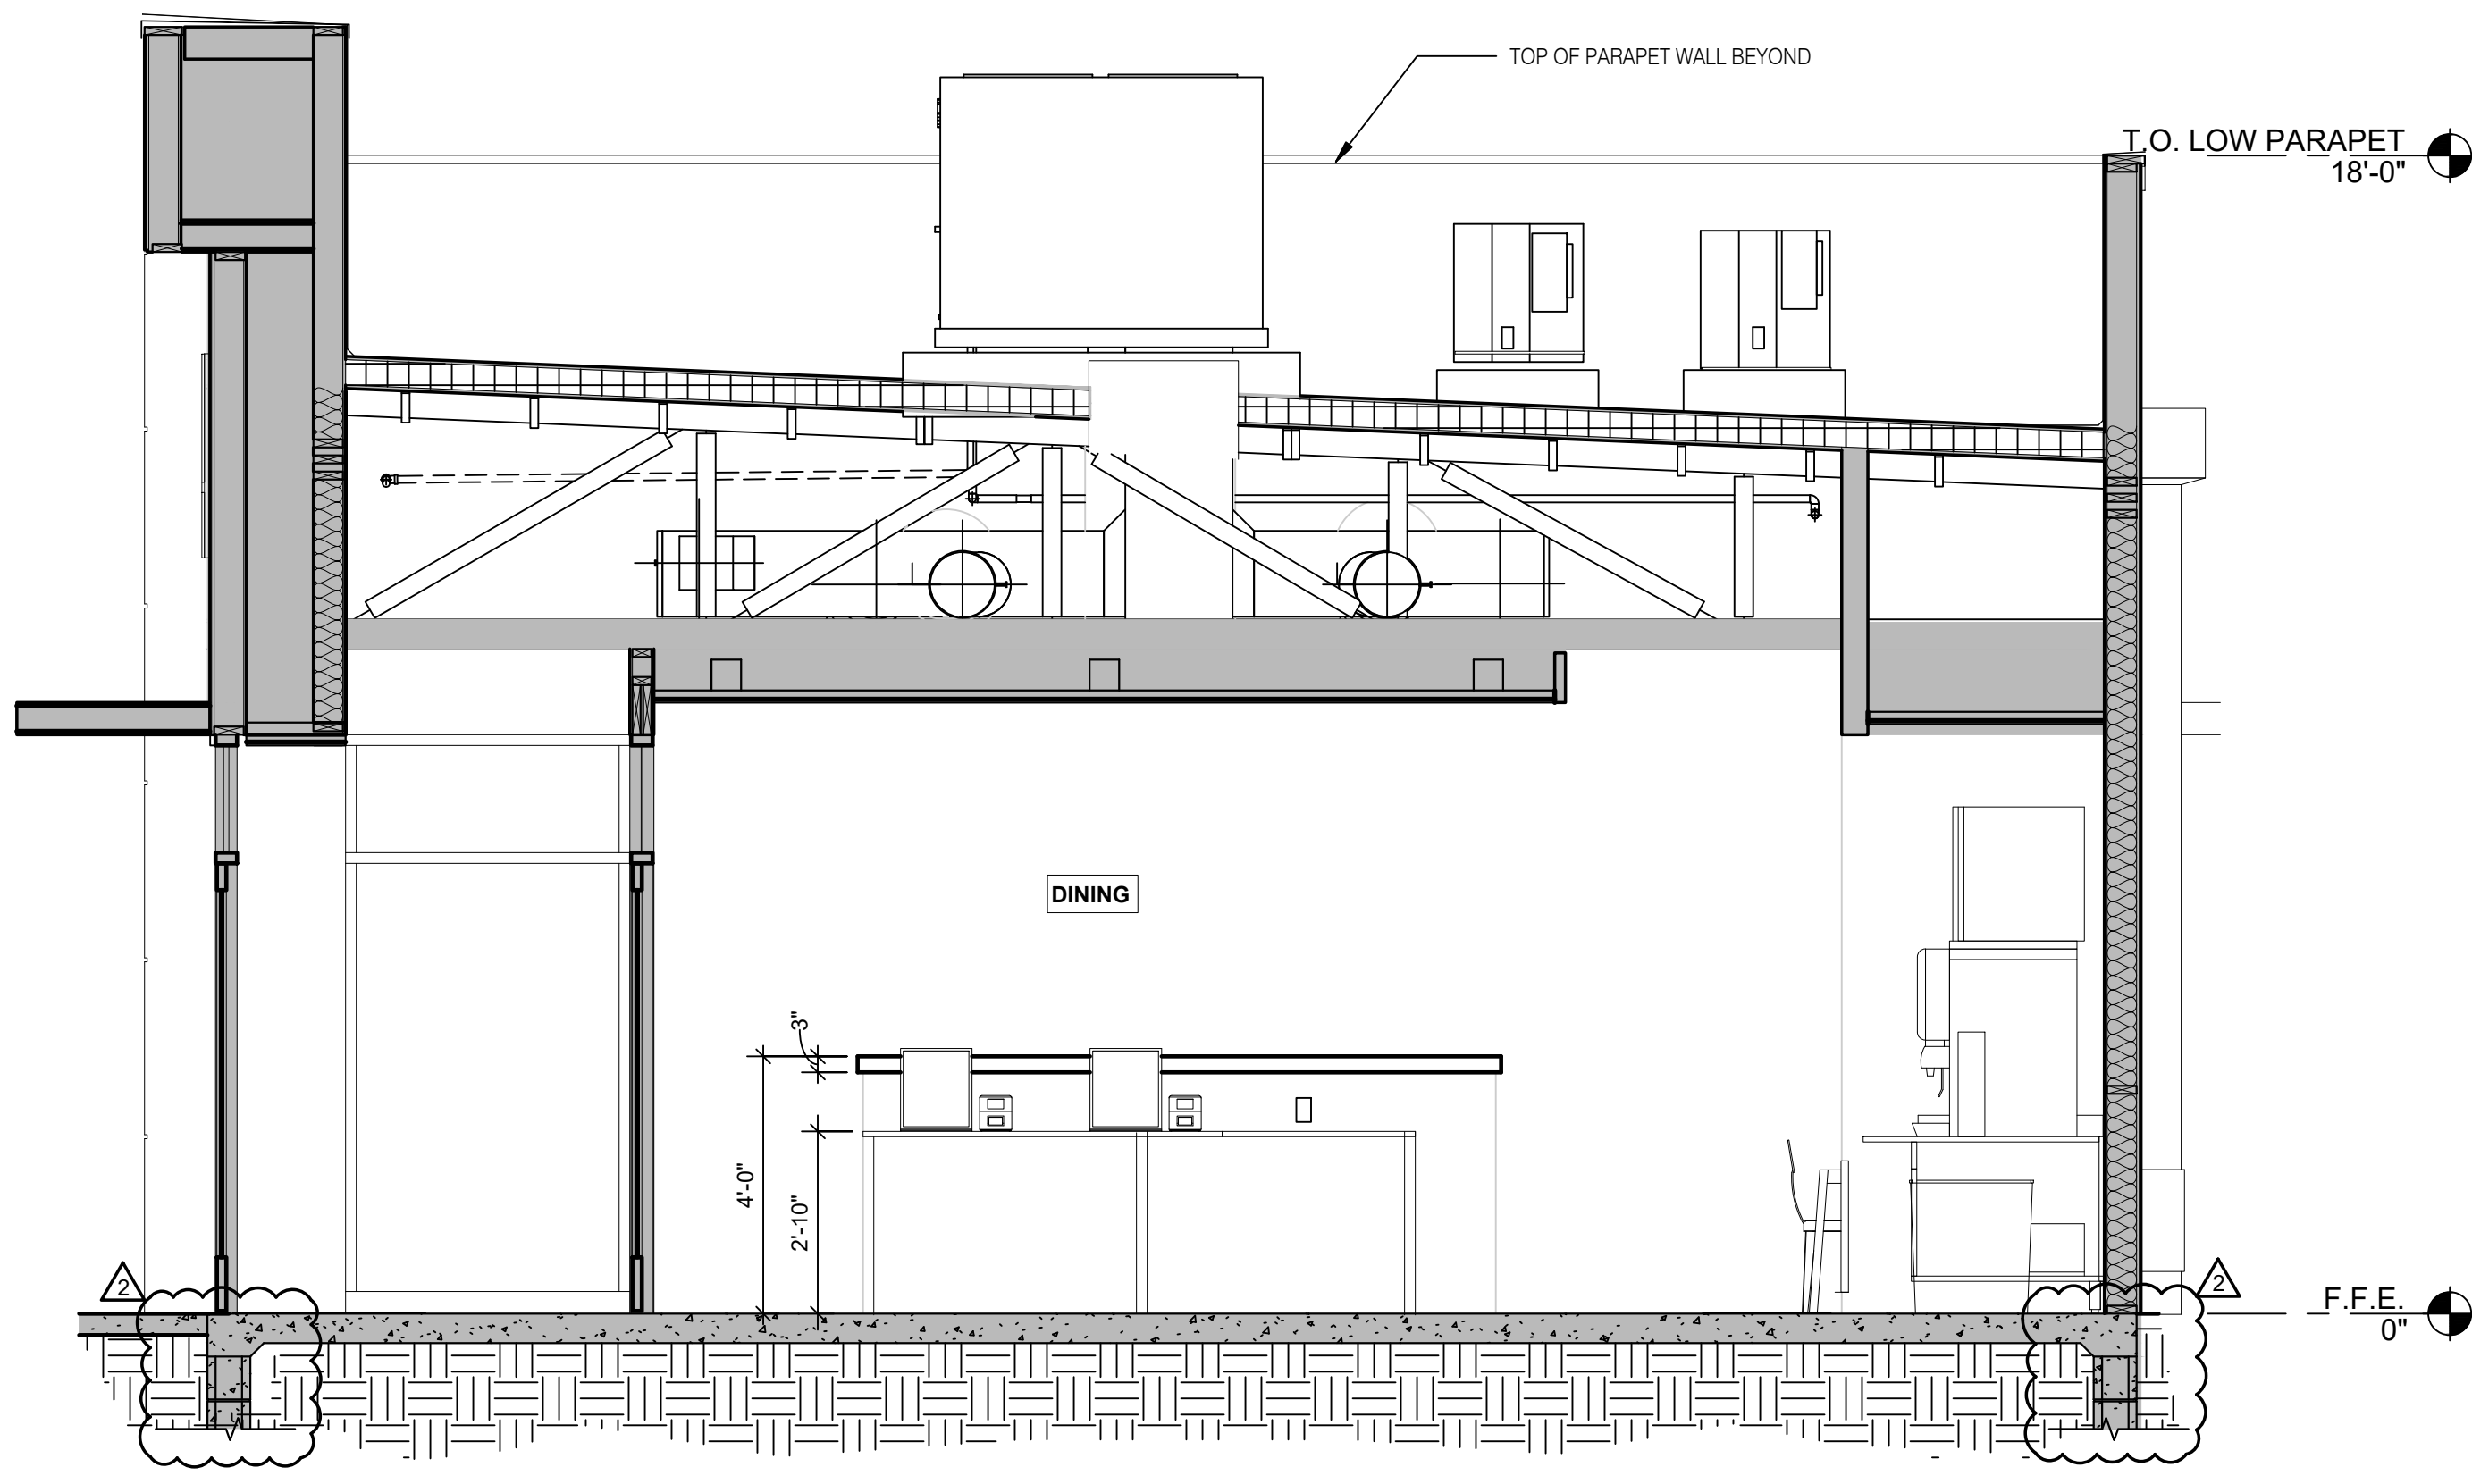

BUILDING SECTION 3 3/8" = 1'-0" **B**



DATE	REMARKS
02/14/2022	ISSUED FOR REVIEW
02/16/2022	ISSUED FOR PERMIT
02/22/2022	ISSUED FOR BID
03/10/2022	HVAC REVISIONS
03/29/2022	BID REVISIONS

CONTRACT DATE:
 BUILDING TYPE: END. MED40
 PLAN VERSION: MARCH 2021


SITE NUMBER: TBD
 STORE NUMBER: TBD
 PA/PM: DJW
 DRAWN BY: CLL
 JOB NO.: 21122

TACO BELL
 5501 Grape Rd
 Mishawaka, IN 46545




**ENDEAVOR 2.0
 BUILDING
 SECTIONS**


A5.1

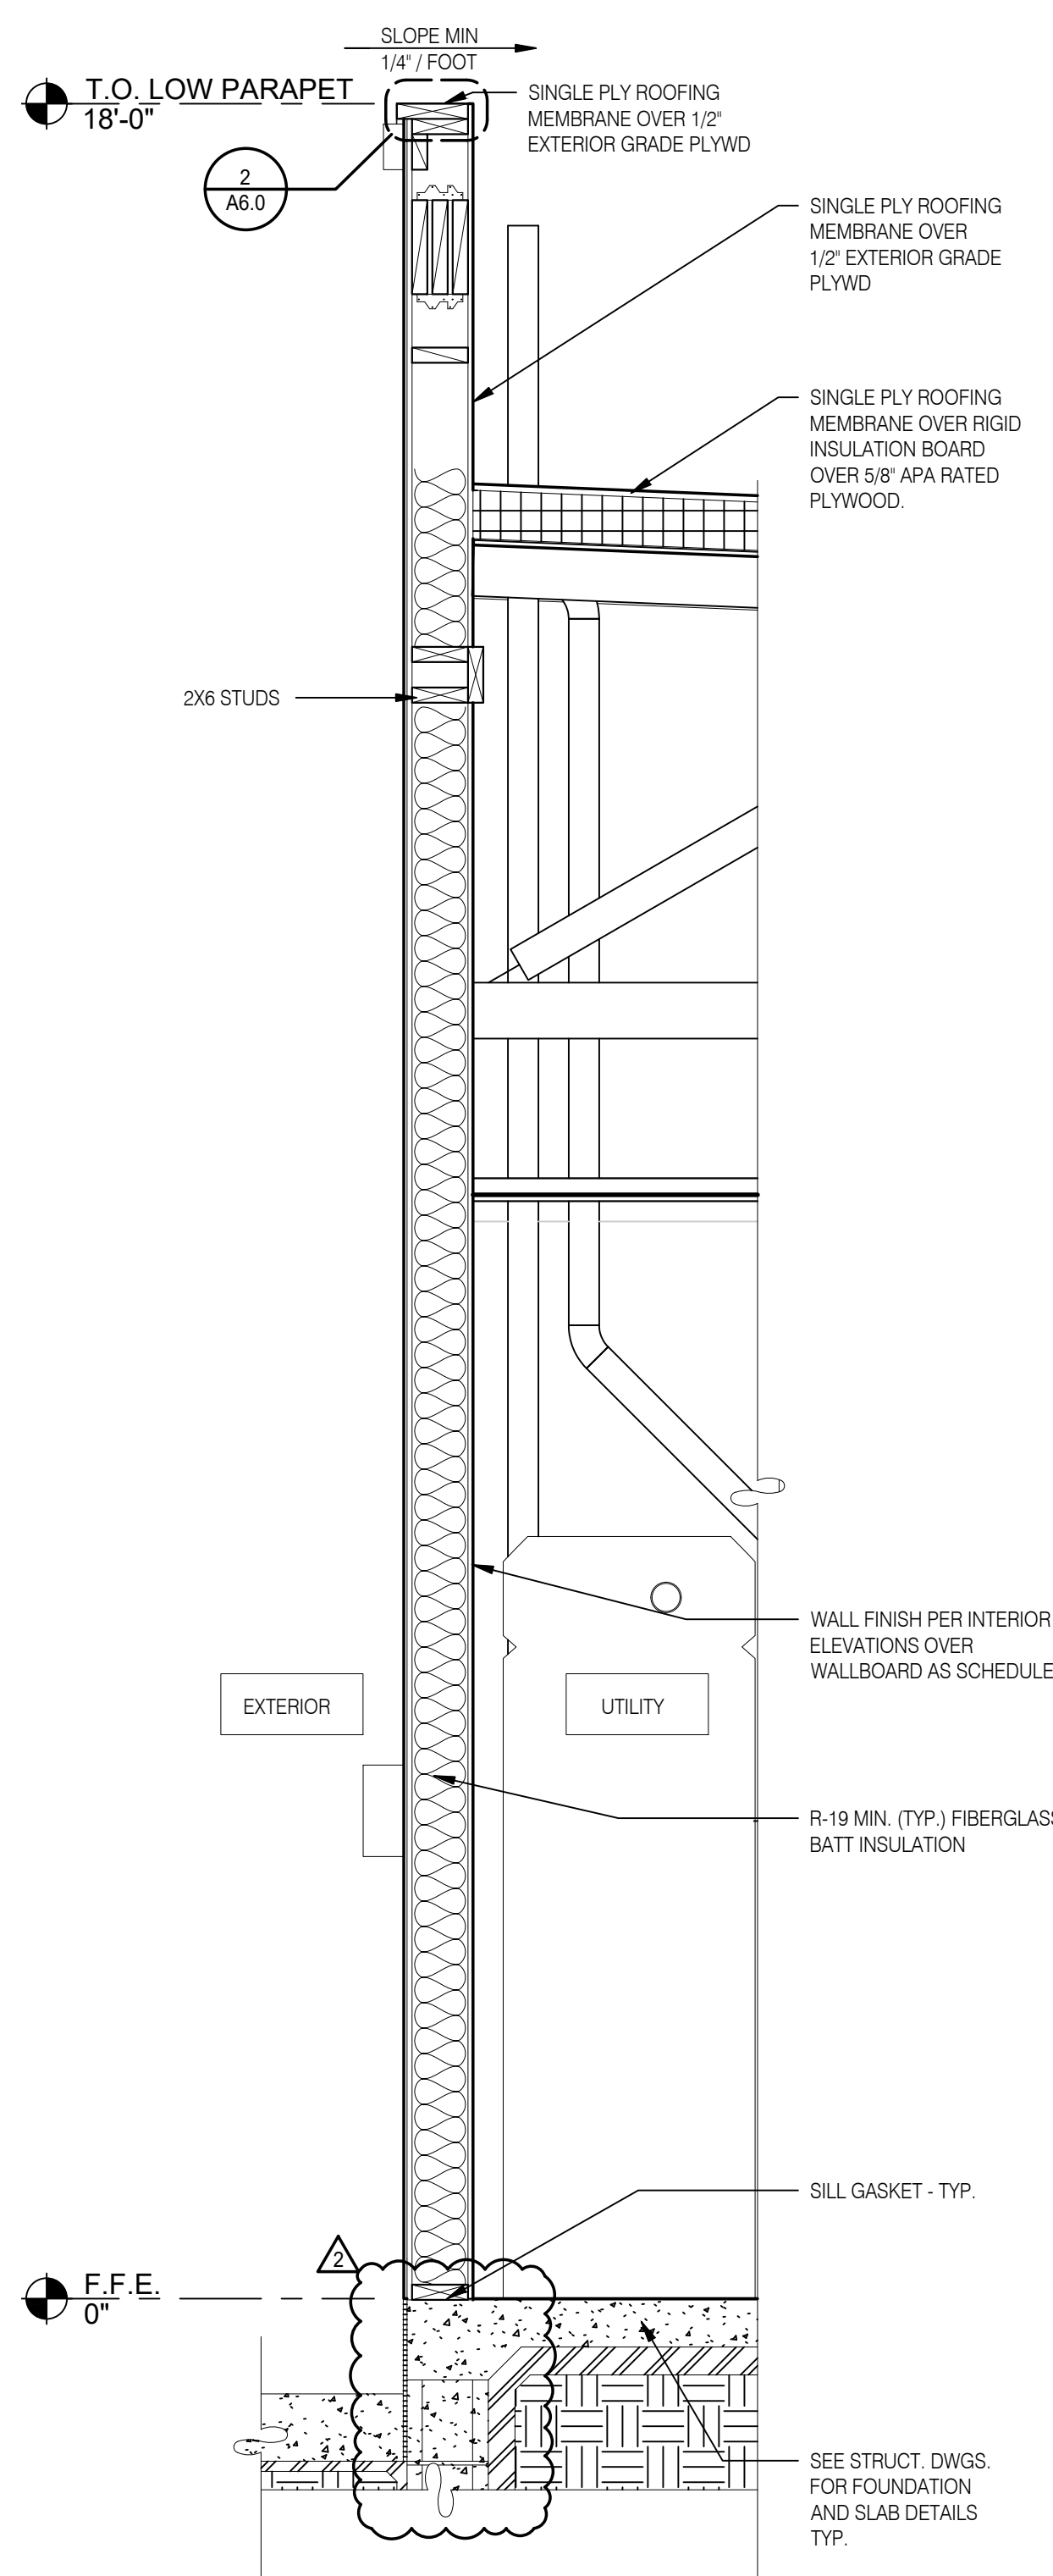


TYPICAL WALL SECTION 3/4" = 1'-0" **D**

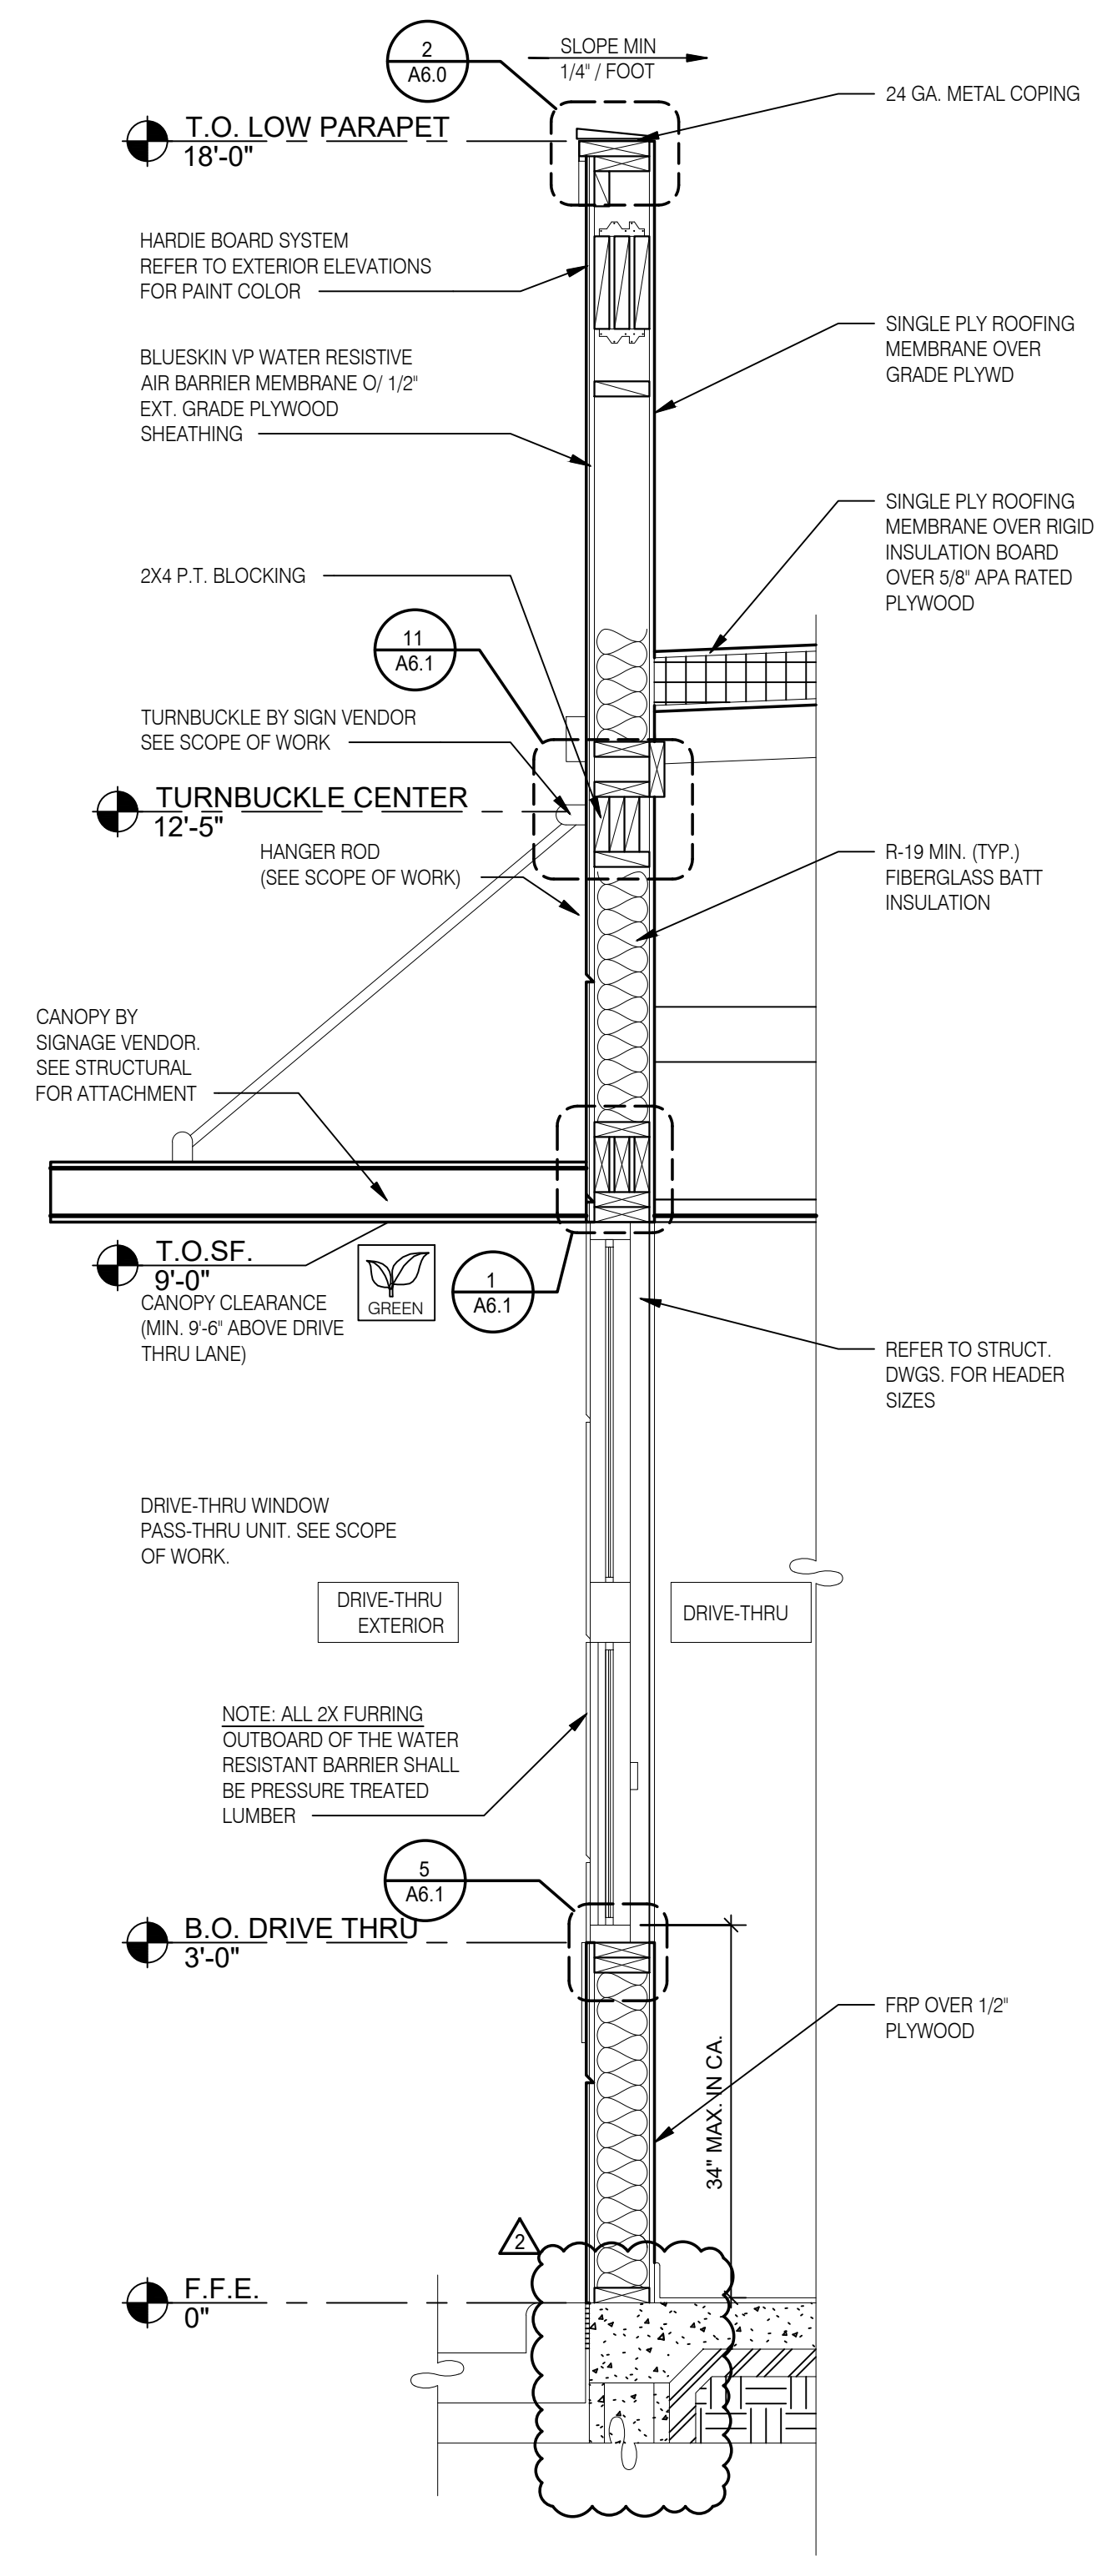


WALL SECTION AT DRIVE THRU 3/4" = 1'-0" **C**

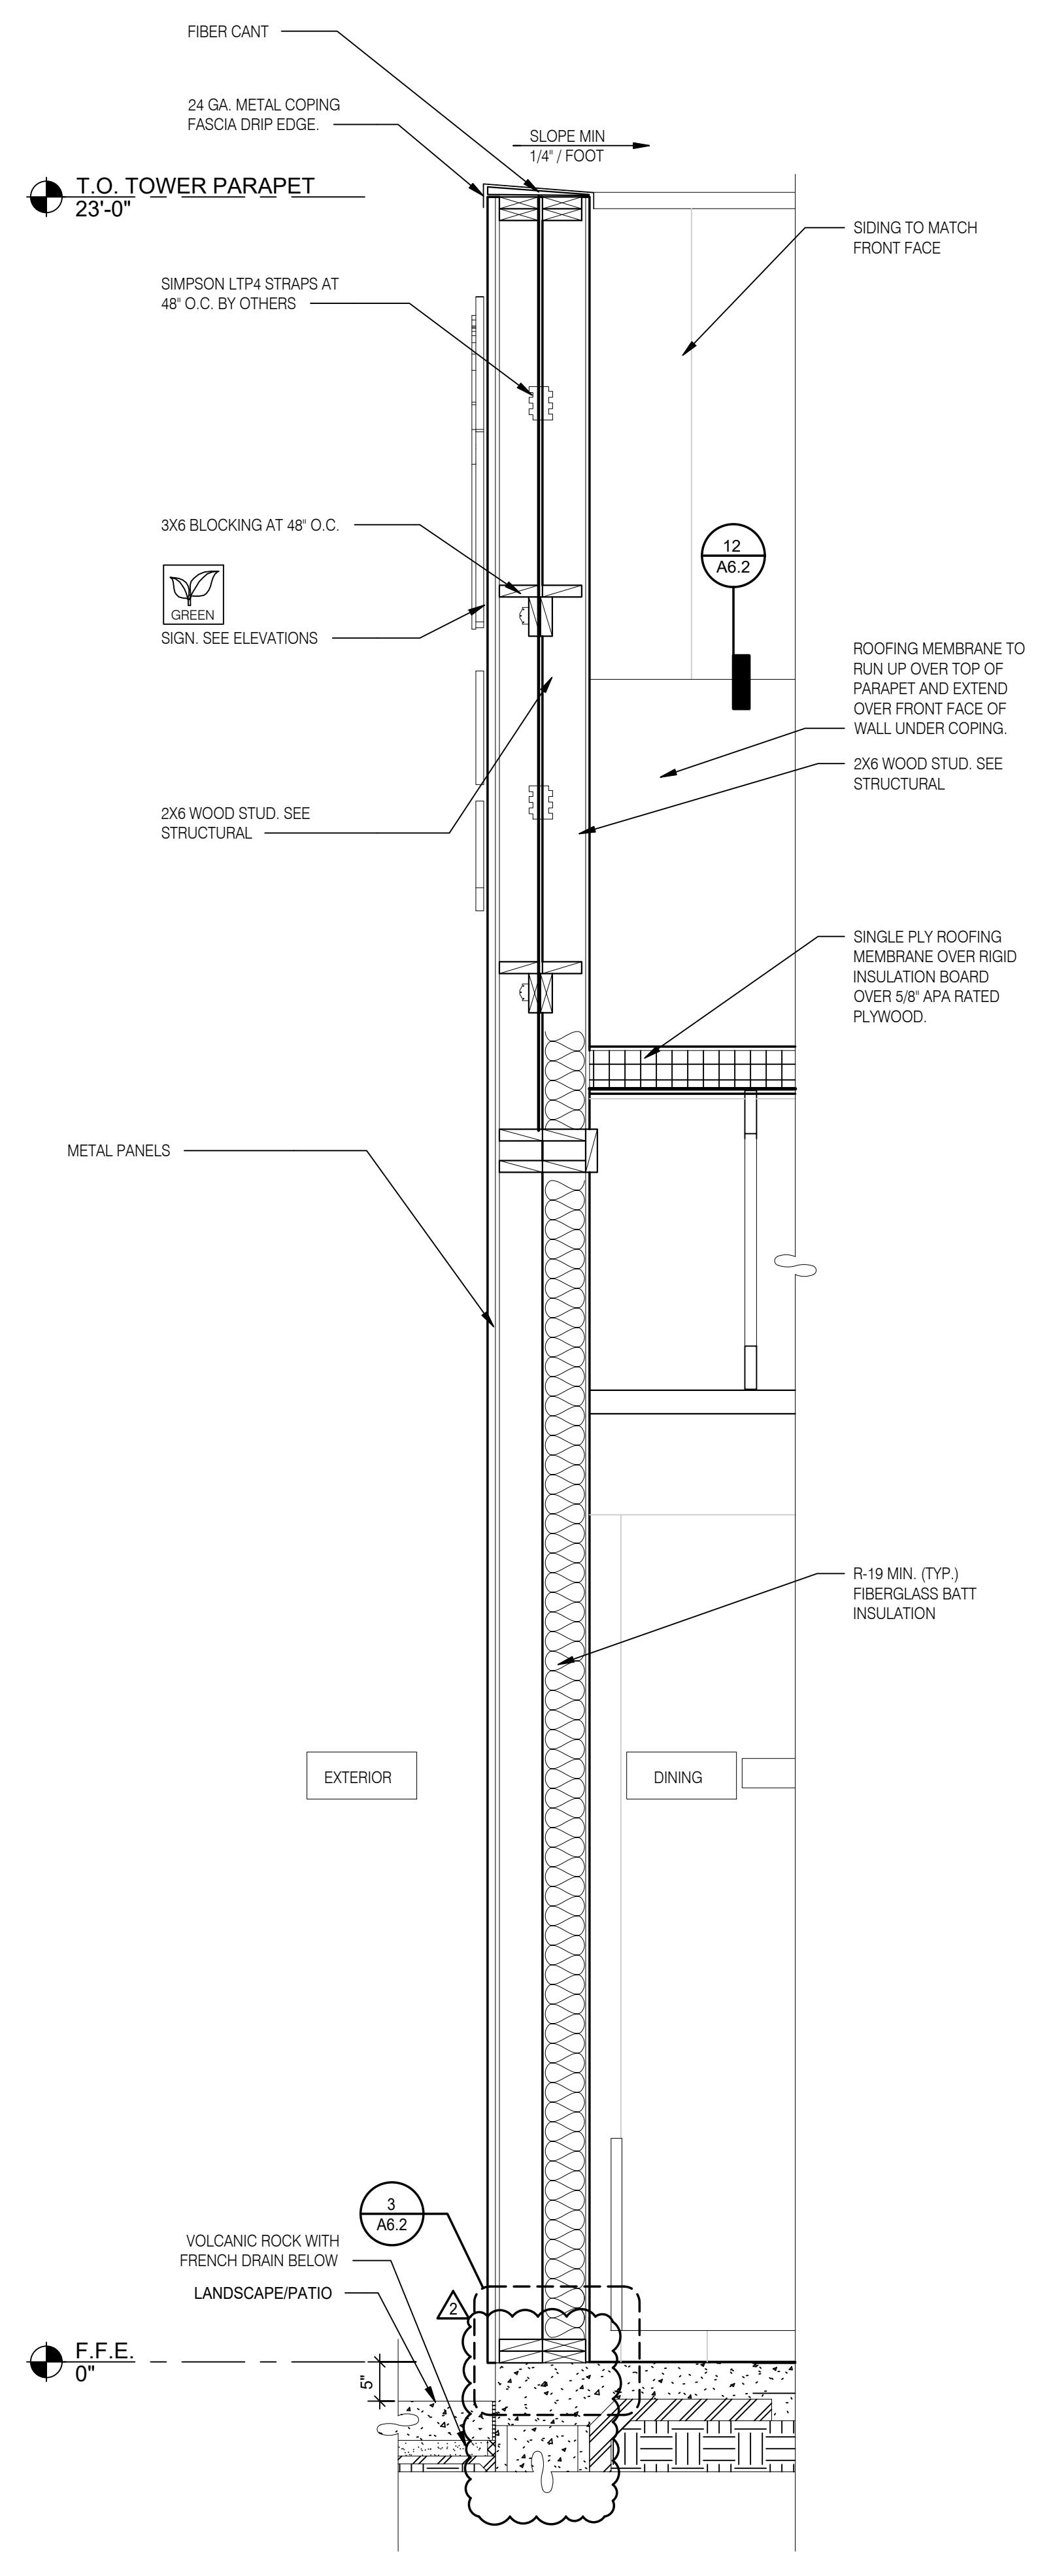

SECTION AT DINING - TOWER 3/4" = 1'-0" **B**

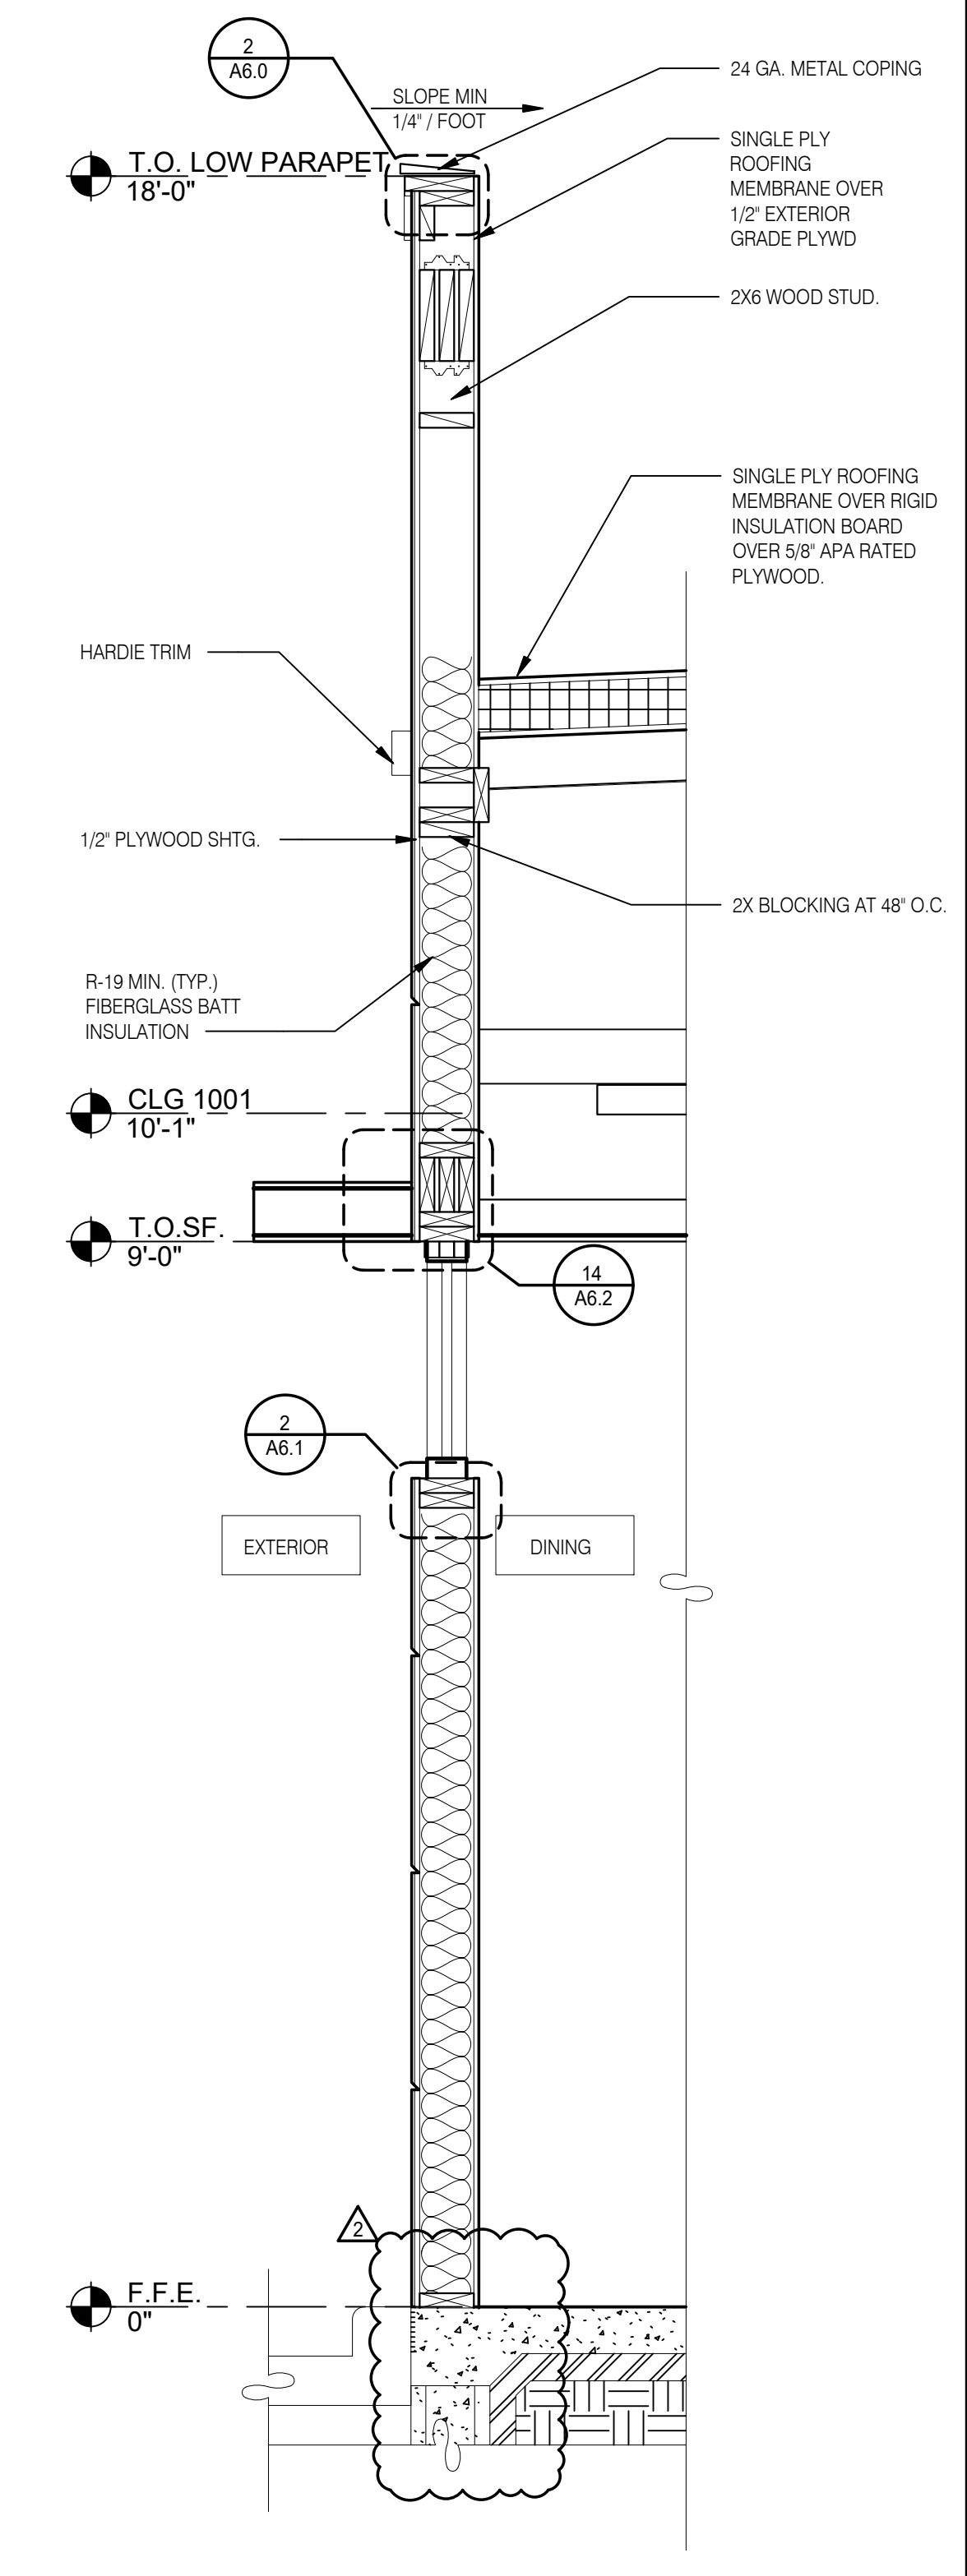

WALL SECTION AT DINING 3/4" = 1'-0" **A**

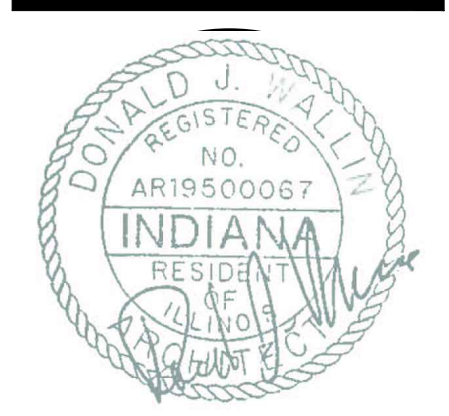

DATE	REMARKS
02/14/2022	ISSUED FOR REVIEW
02/16/2022	ISSUED FOR PERMIT
02/22/2022	ISSUED FOR BID
03/10/2022	HVAC REVISIONS
03/29/2022	BID REVISIONS

CONTRACT DATE:
BUILDING TYPE: END. MED40
PLAN VERSION: MARCH 2021


SITE NUMBER: TBD
STORE NUMBER: TBD
PA/PM: DJW
DRAWN BY: CLL
JOB NO.: 21122

TACO BELL
5501 Grape Rd
Mishawaka, IN 46545




ENDEAVOR 2.0
WALL
SECTIONS


A5.2

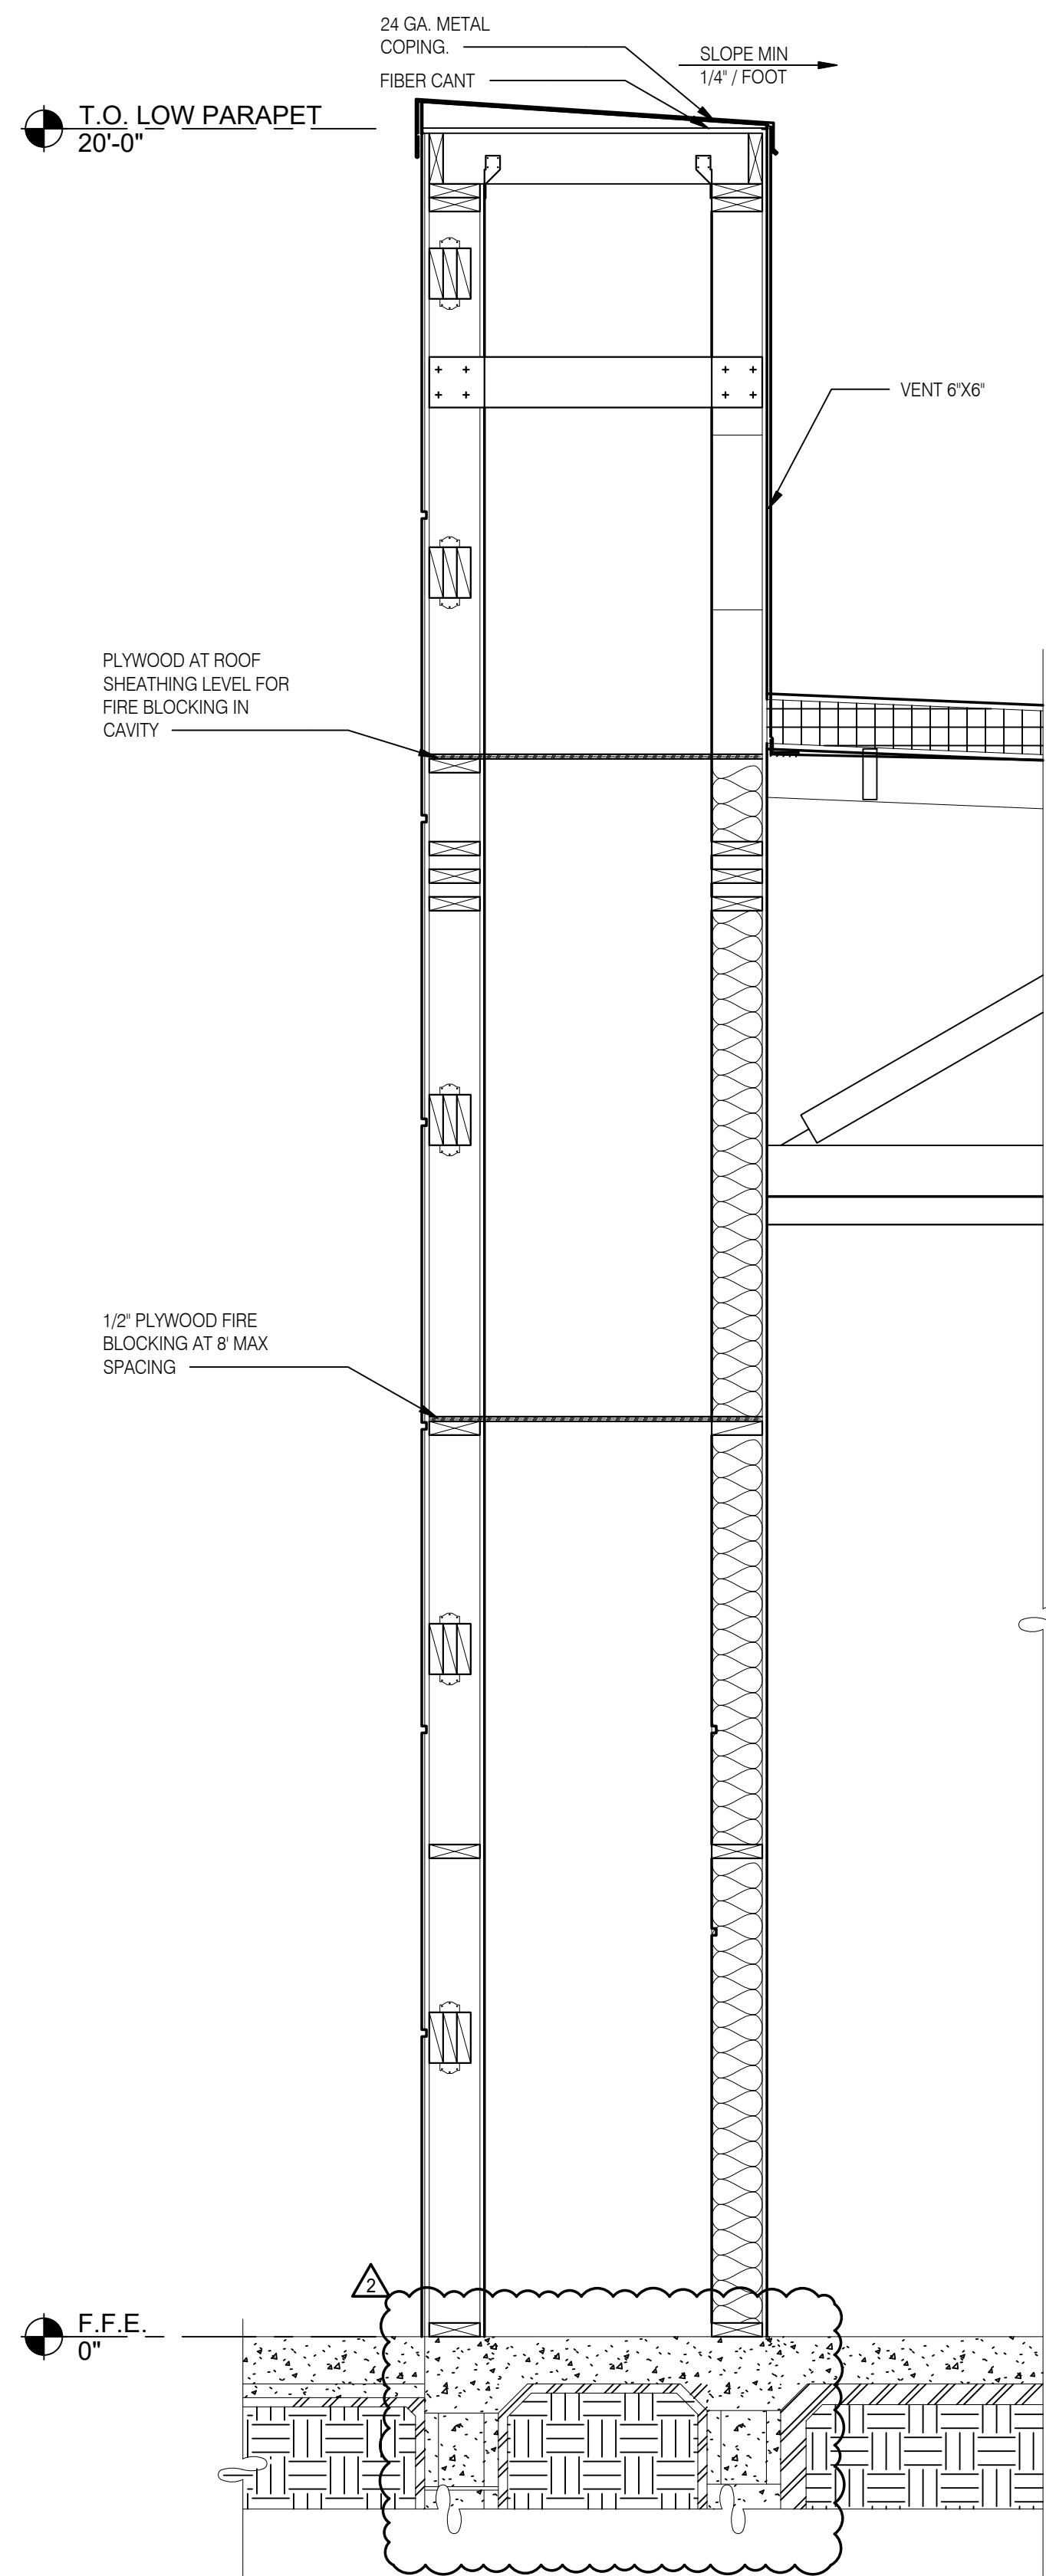


FRONT WALL SECTION 3/4" = 1'-0" **D**

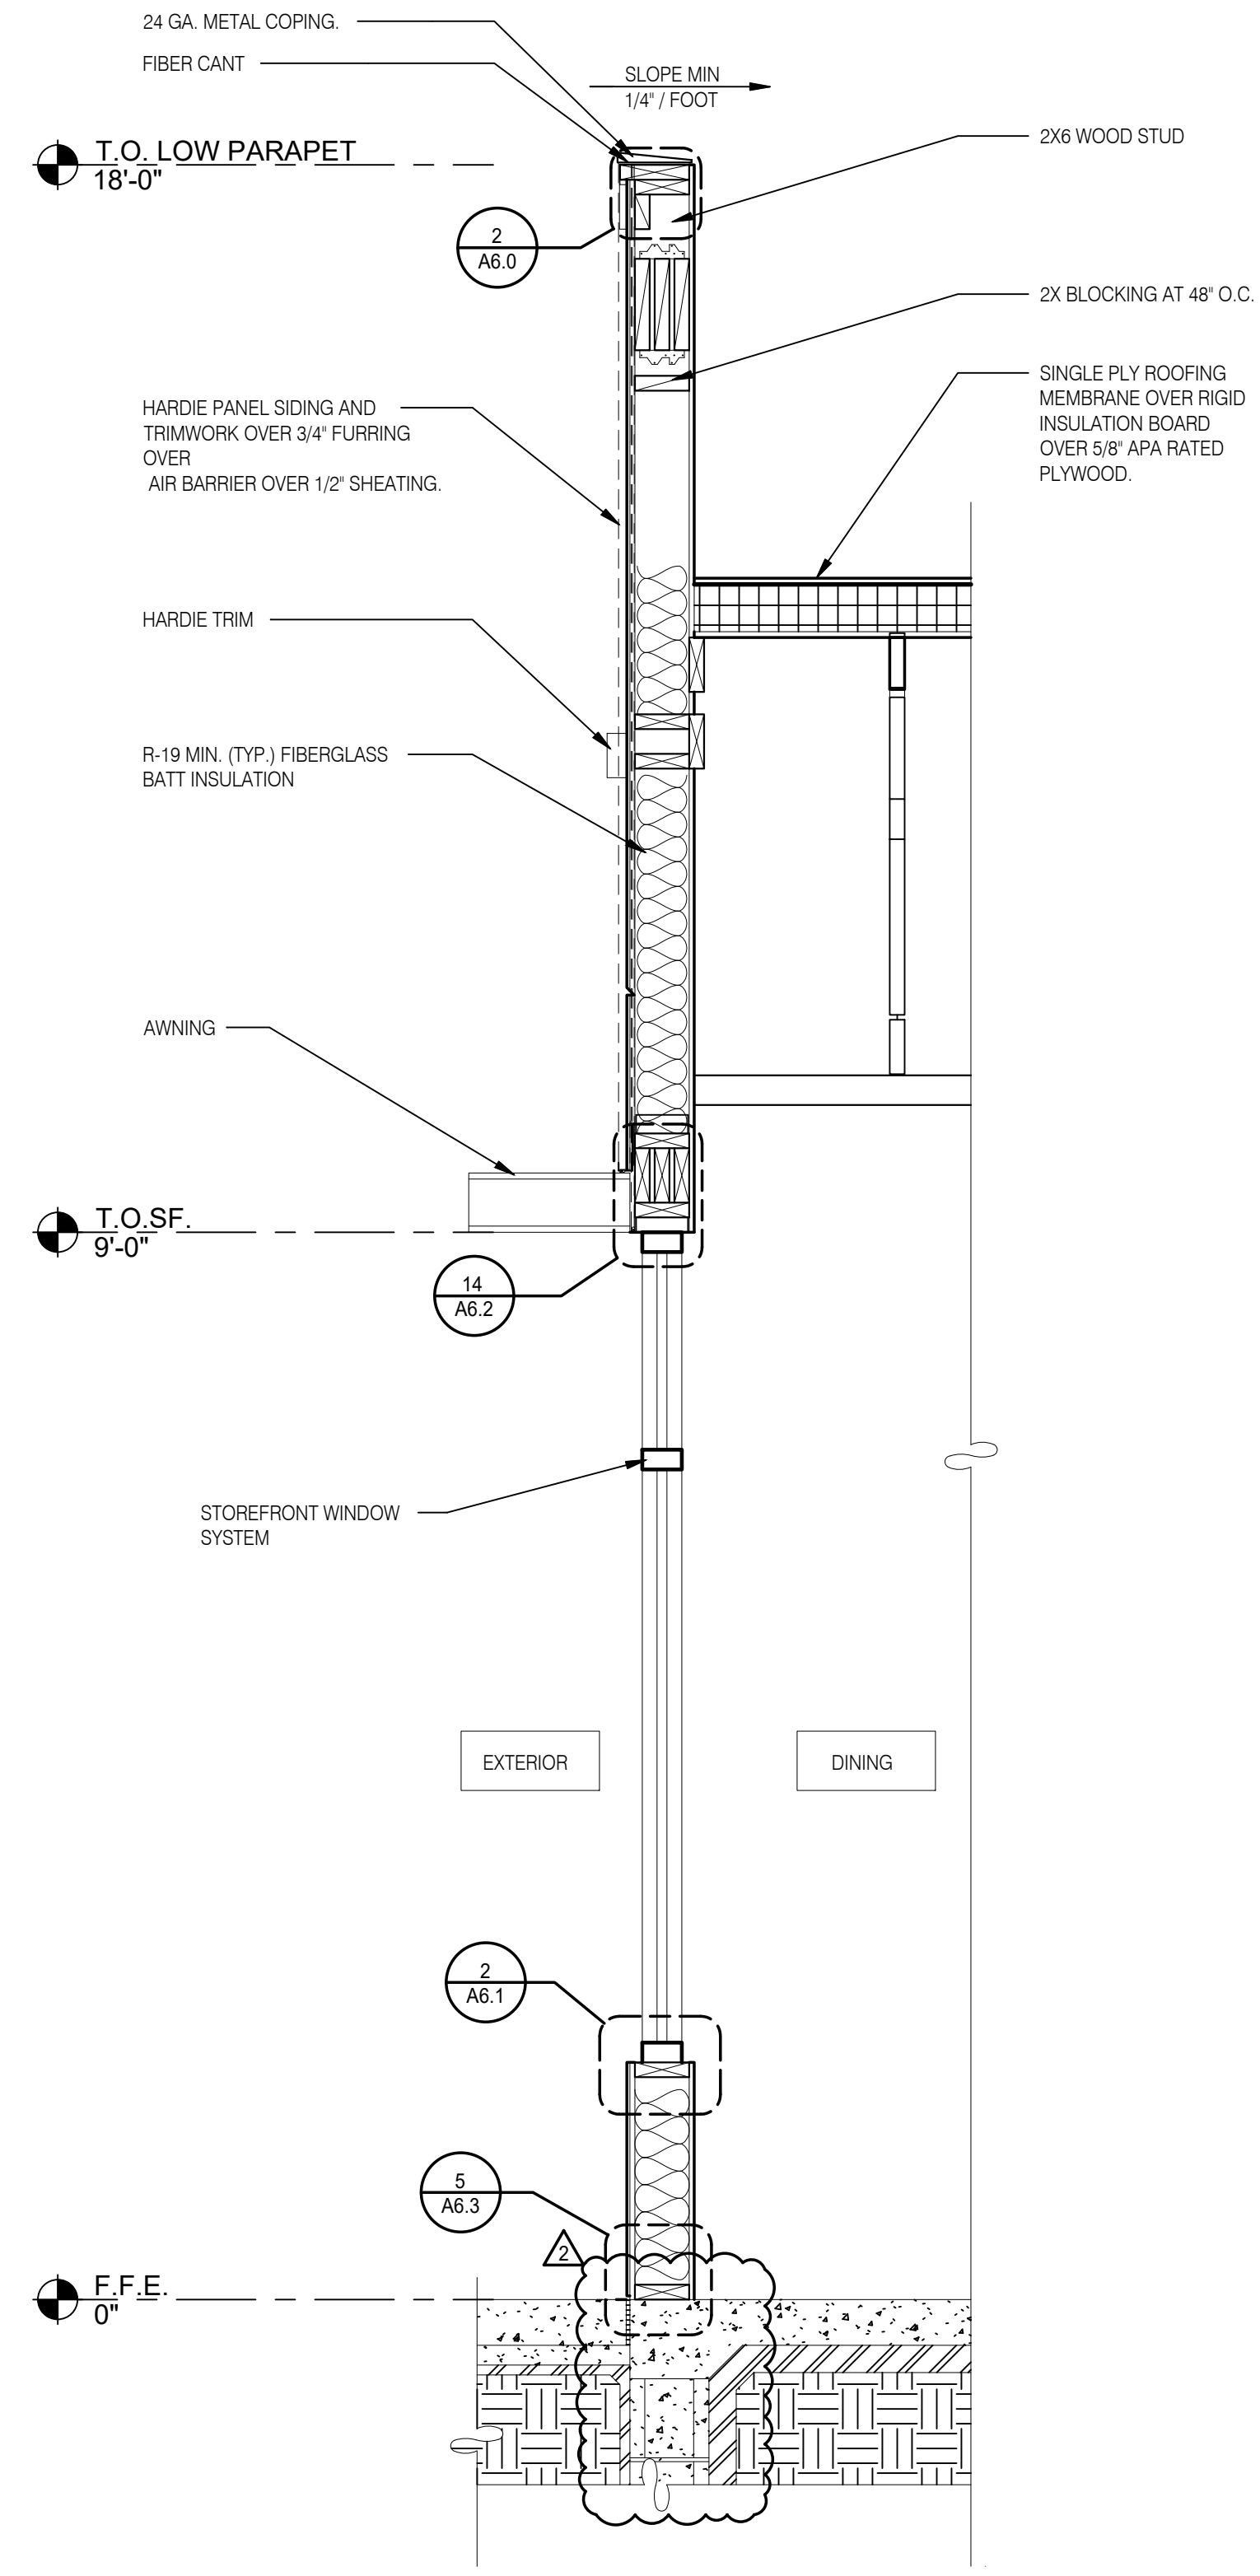

FRONT WALL SECTION 3/4" = 1'-0" **C**

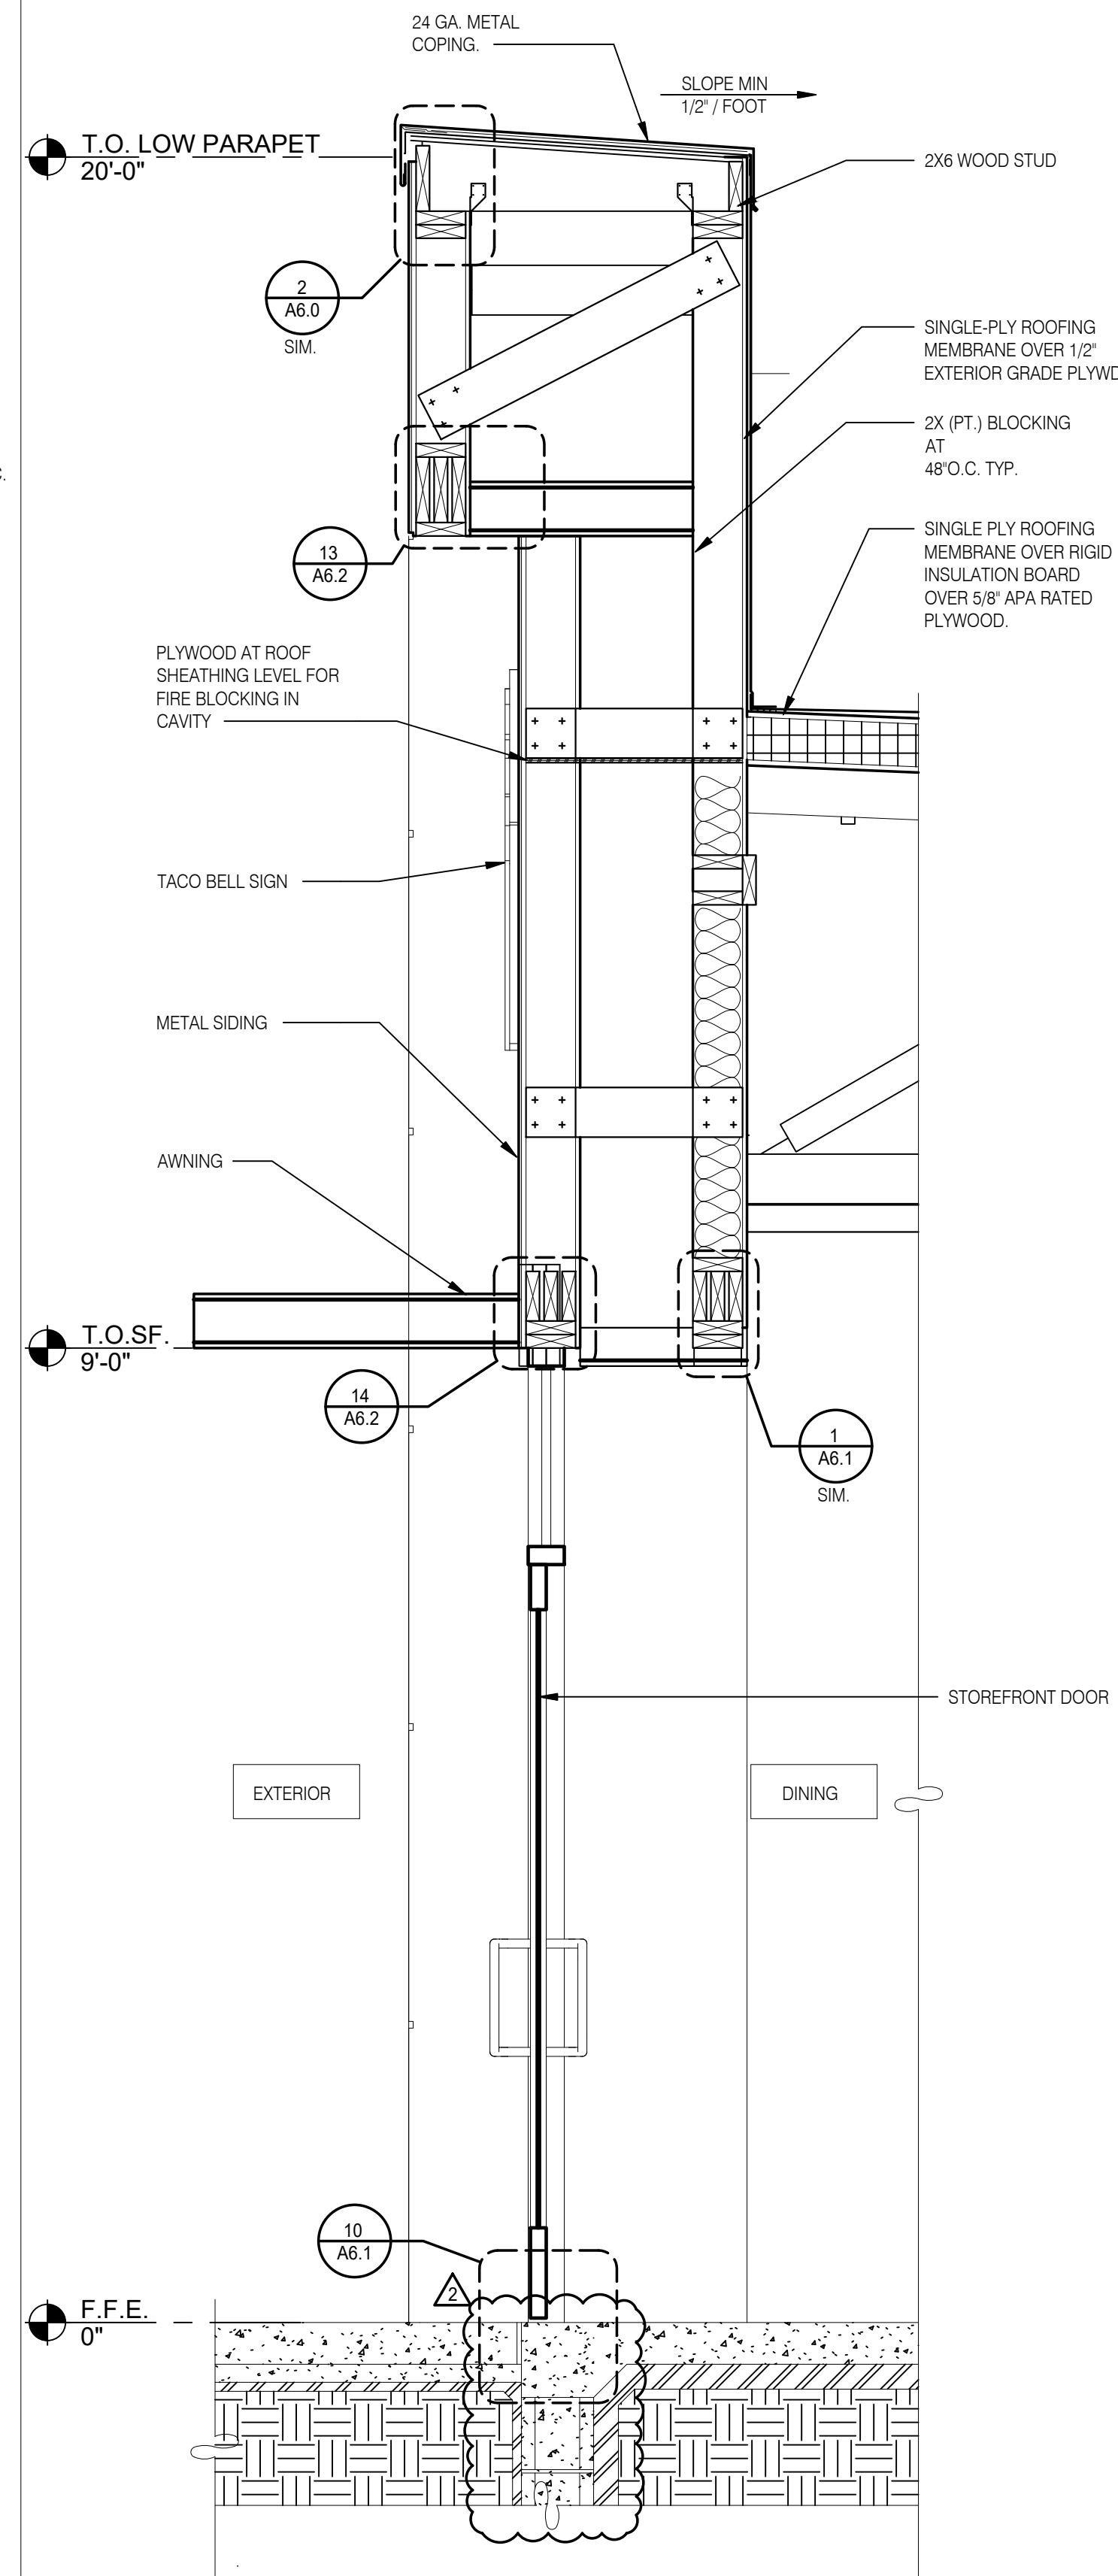

WALL SECTION AT DINING DOOR 3/4" = 1'-0" **B**

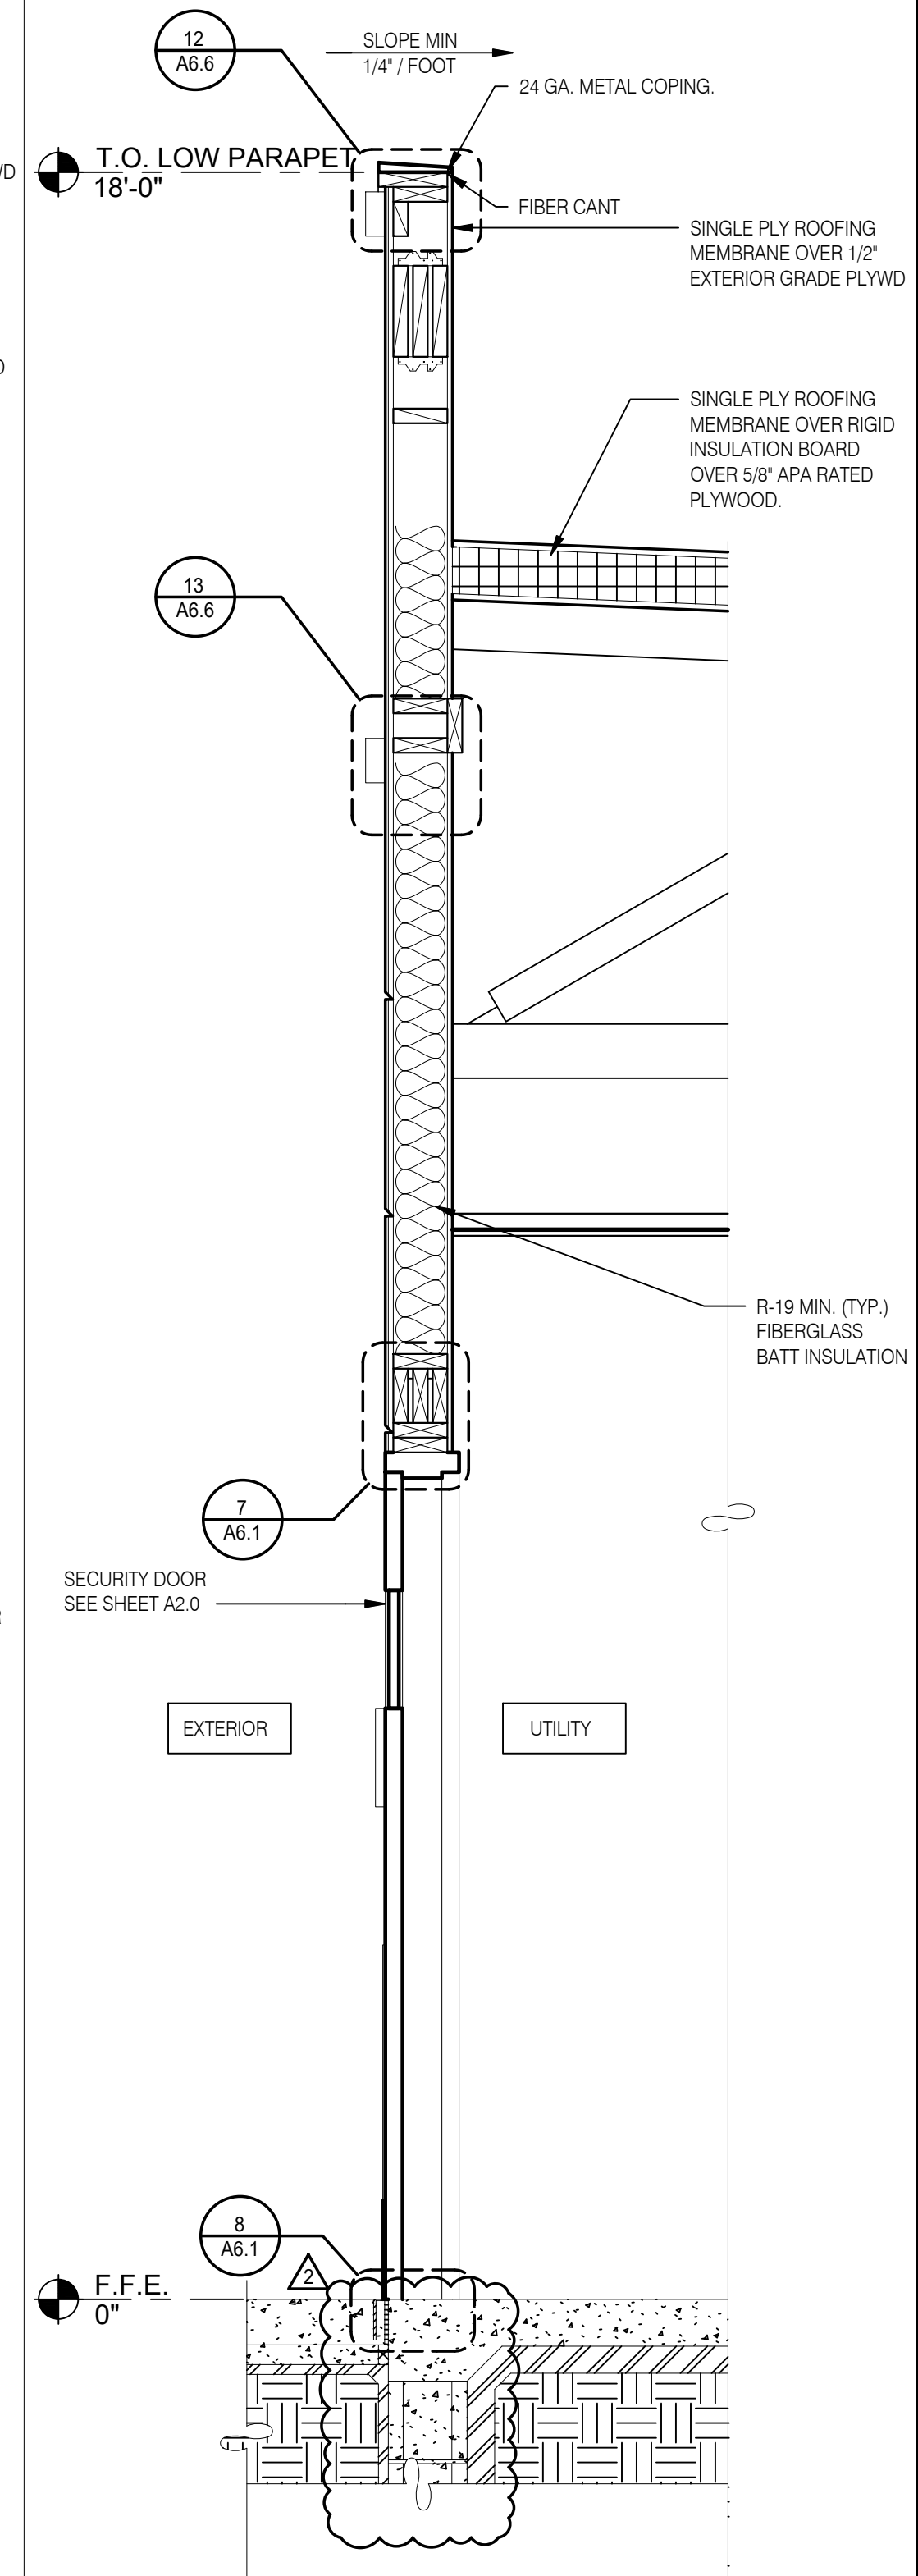

WALL SECTION AT SERVICE DOOR 3/4" = 1'-0" **A**



DATE	REMARKS
02/14/2022	ISSUED FOR REVIEW
02/16/2022	ISSUED FOR PERMIT
02/22/2022	ISSUED FOR BID
03/10/2022	HVAC REVISIONS
03/29/2022	BID REVISIONS

CONTRACT DATE:
 BUILDING TYPE: END. MED40
 PLAN VERSION: MARCH 2021


SITE NUMBER: TBD
 STORE NUMBER: TBD
 PA/PM: DJW
 DRAWN BY: CLL
 JOB NO.: 21122

TACO BELL
 5501 Grape Rd
 Mishawaka, IN 46545




ENDEAVOR 2.0
WALL SECTIONS

A5.3

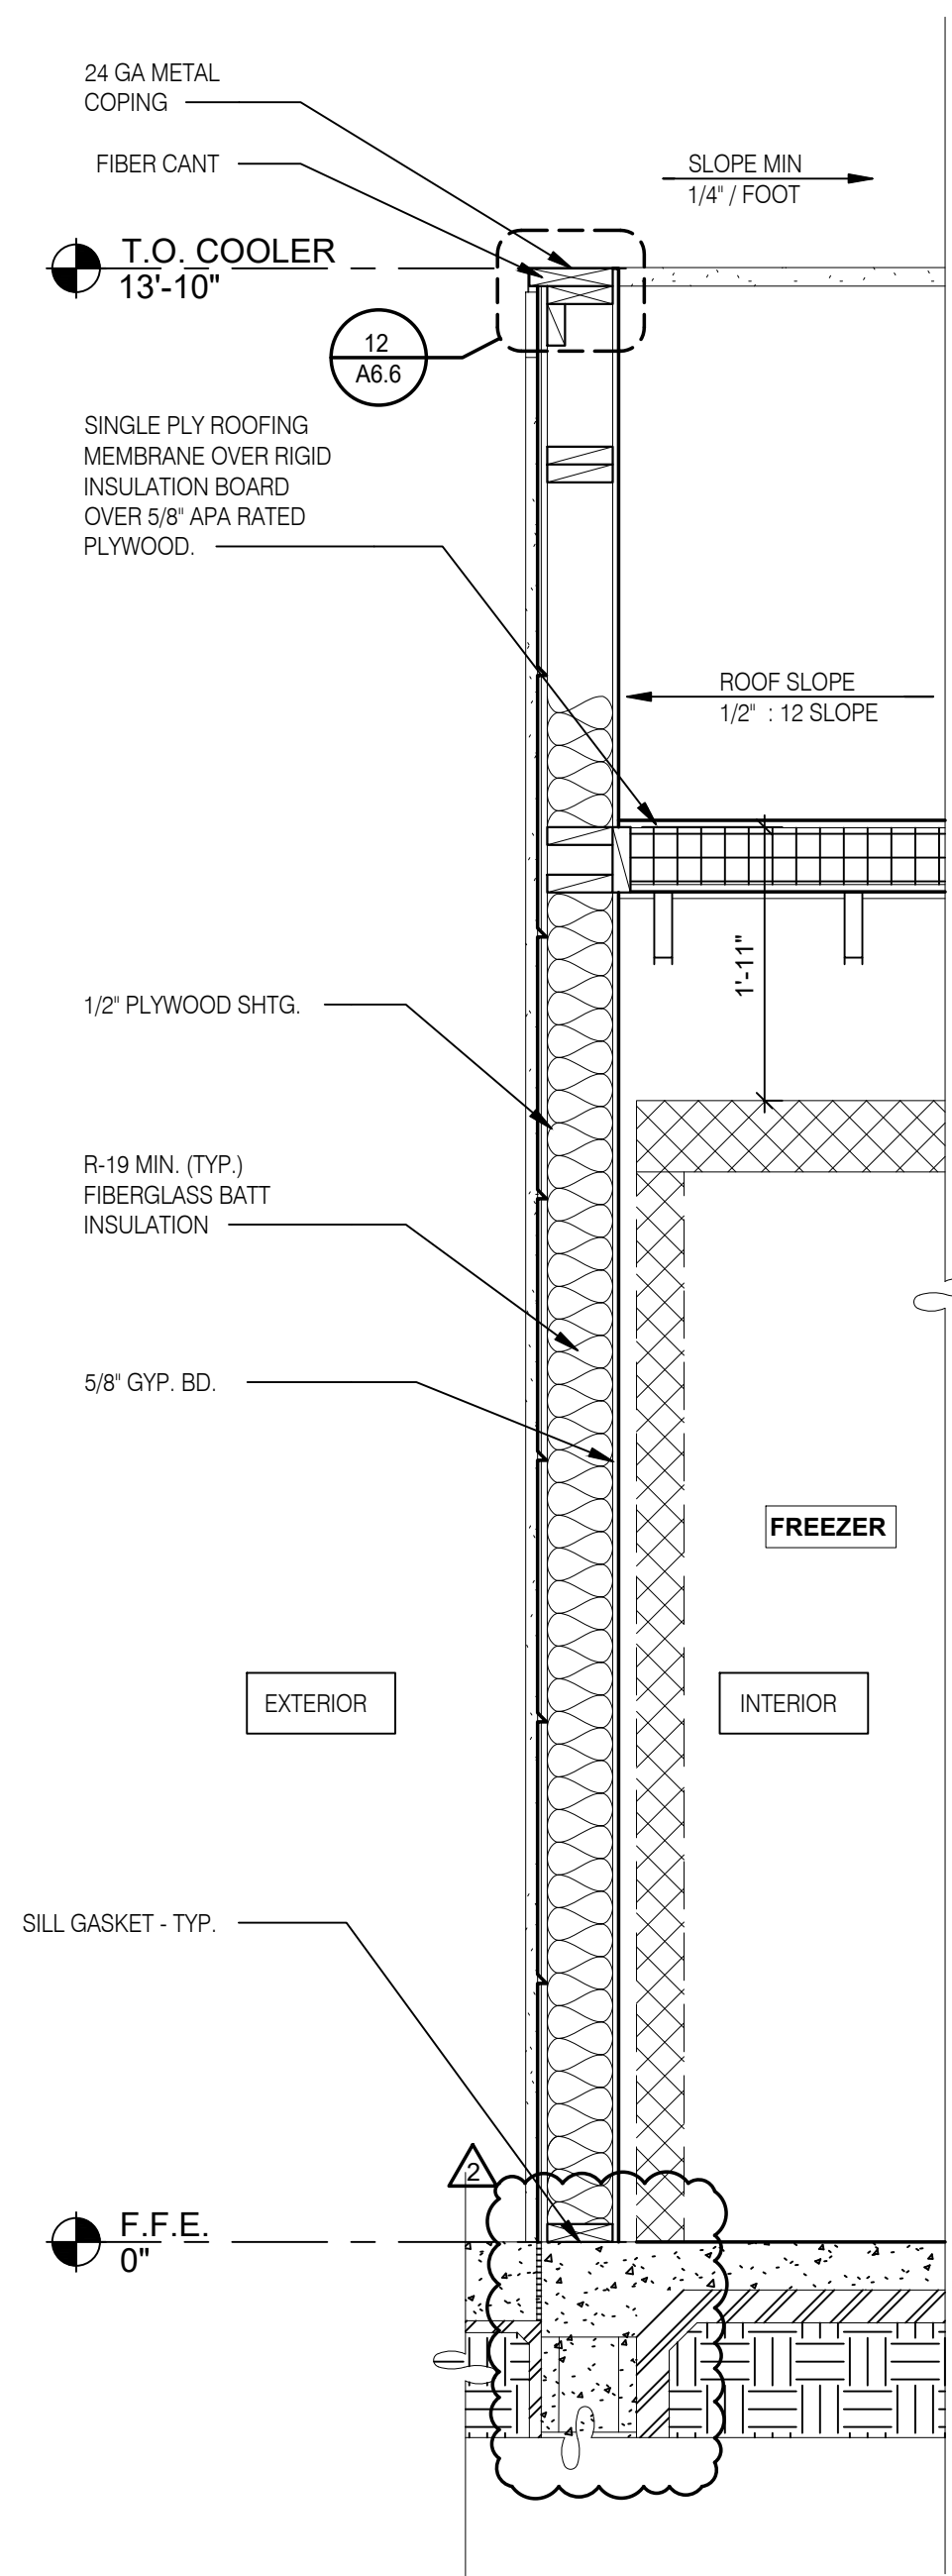

WALL SECTION 3/4" = 1'-0" B

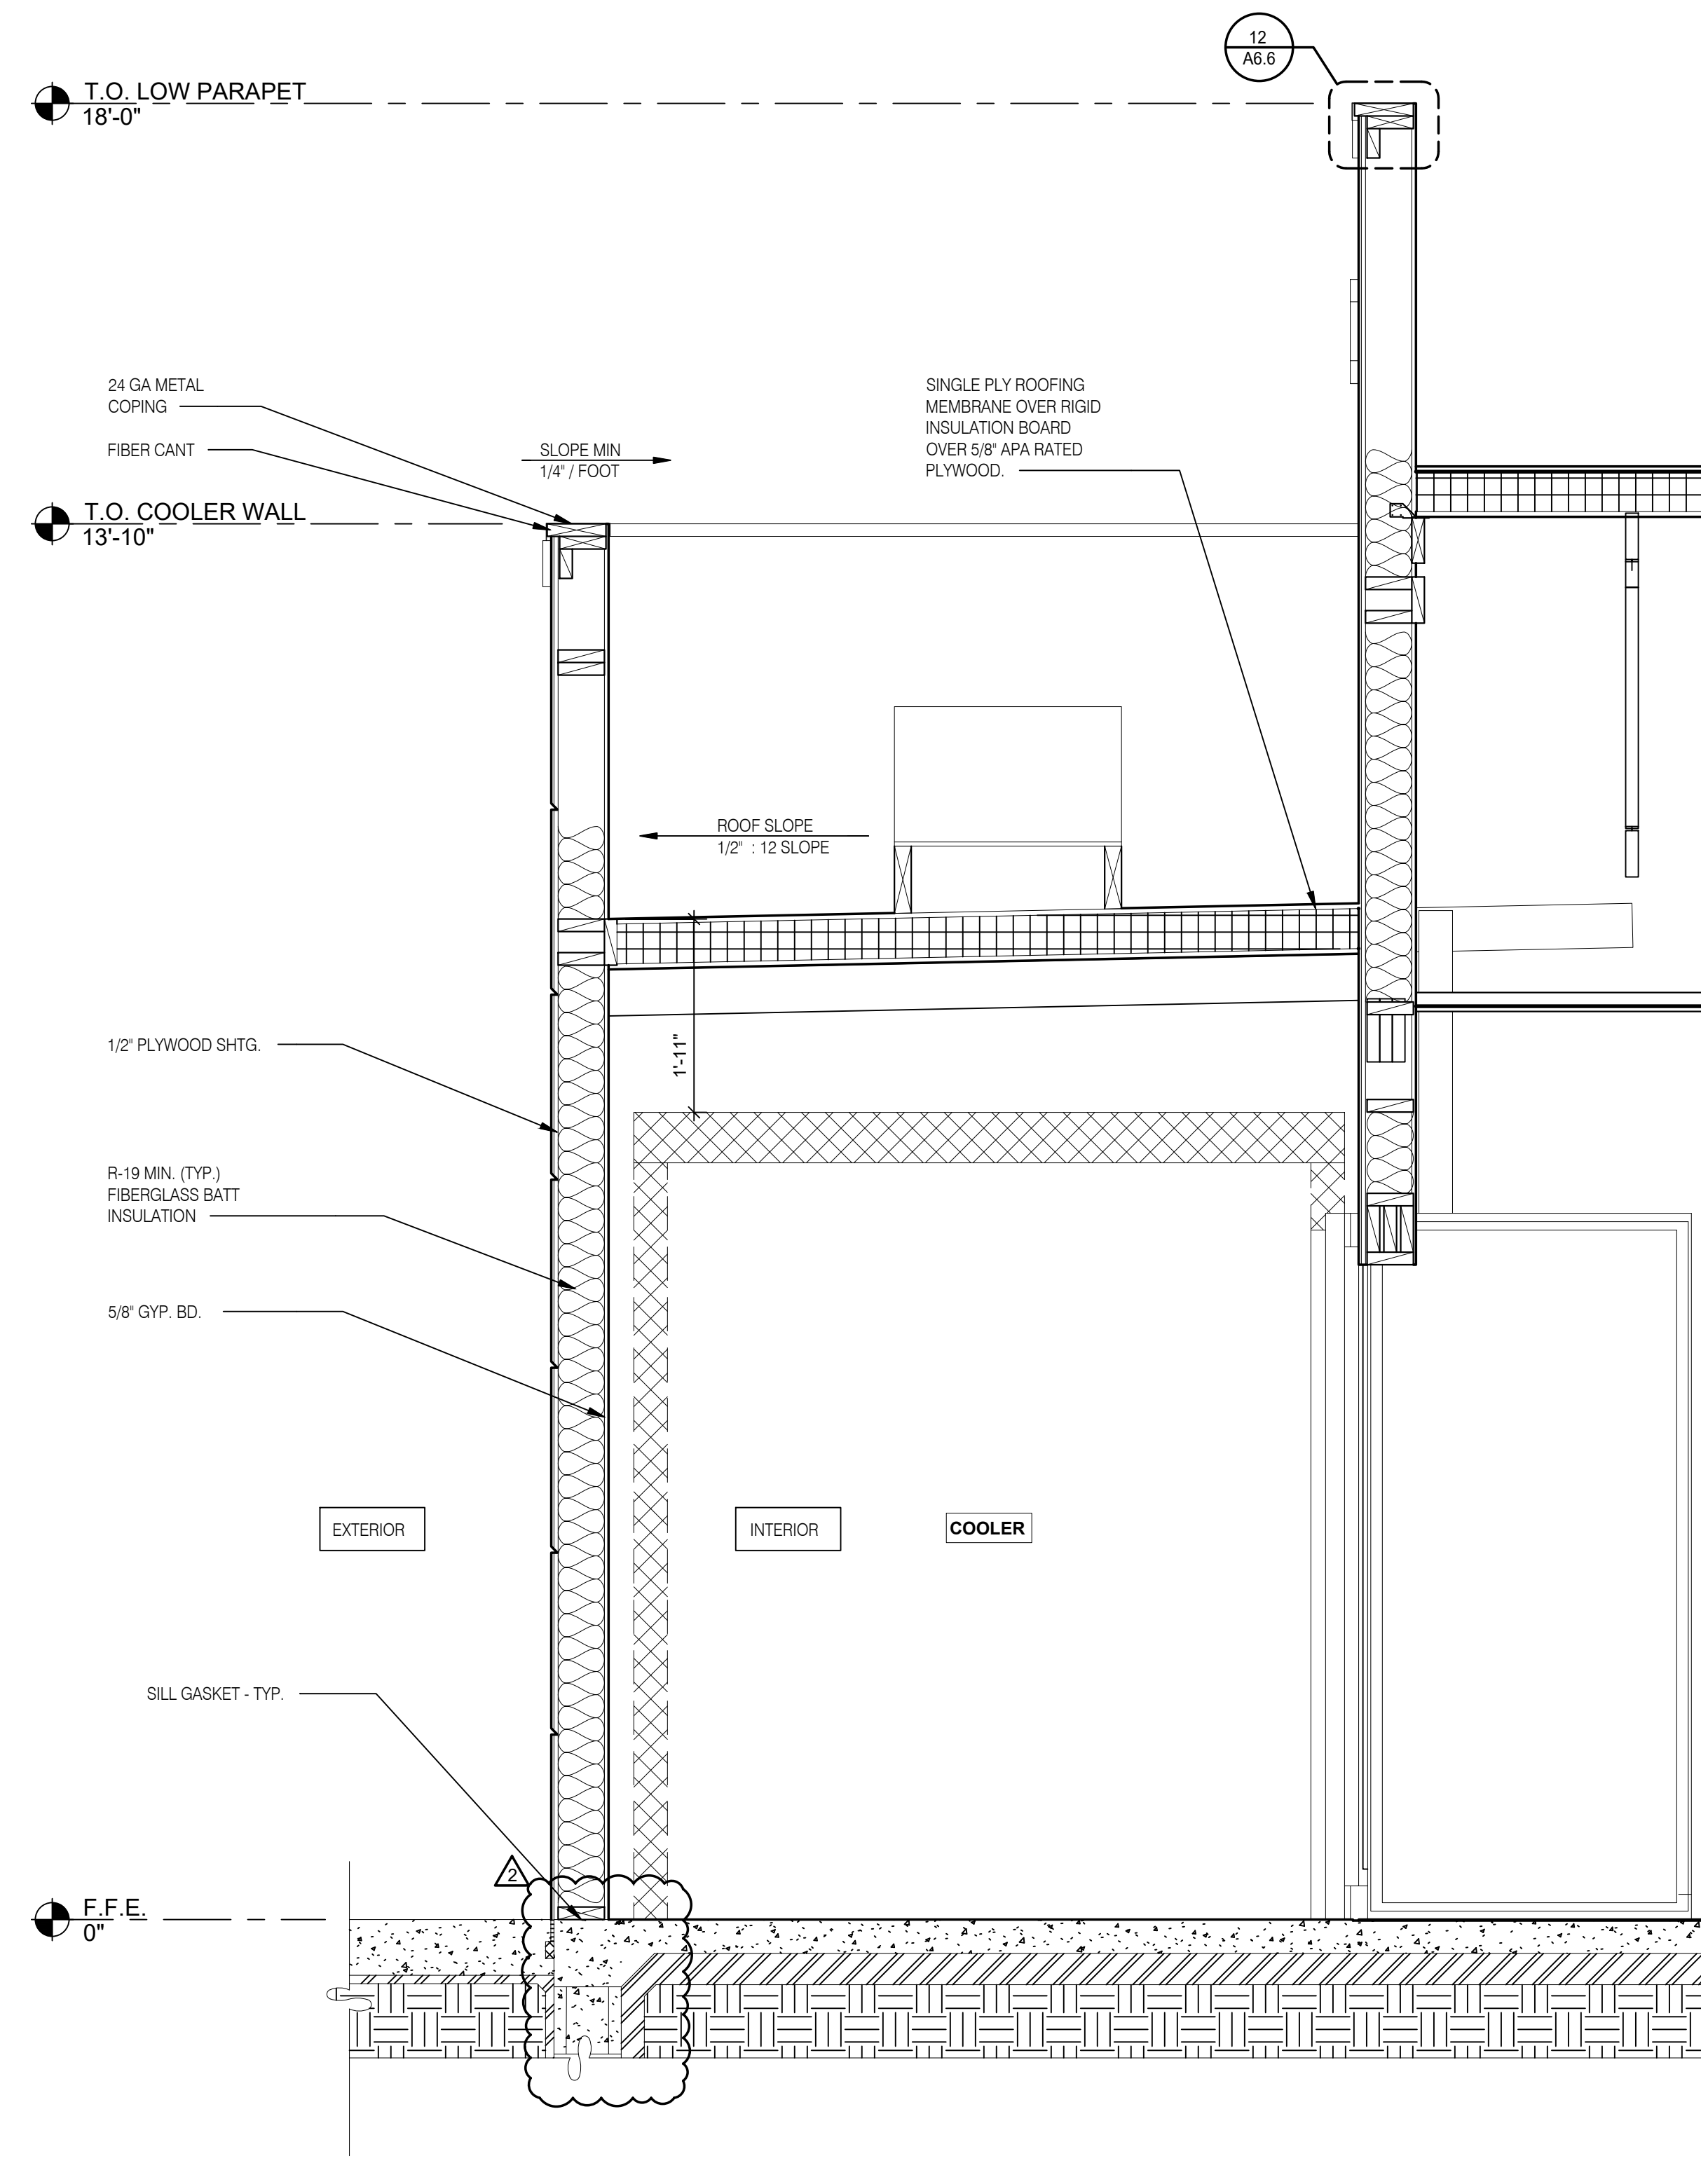

WALL SECTION AT COOLER 3/4" = 1'-0" A



DATE	REMARKS
02/14/2022	ISSUED FOR REVIEW
02/16/2022	ISSUED FOR PERMIT
02/22/2022	ISSUED FOR BID
03/10/2022	HVAC REVISIONS
03/29/2022	BID REVISIONS

CONTRACT DATE:
 BUILDING TYPE: END. MED40
 PLAN VERSION: MARCH 2021

SITE NUMBER: TBD
 STORE NUMBER: TBD
 PA/PM: DJW
 DRAWN BY: CLL
 JOB NO.: 21122

TACO BELL
 5501 Grape Rd
 Mishawaka, IN 46545



ENDEAVOR 2.0
 WALL
 SECTIONS

A5.4